


KEYED NOTES

INDICATED CASES FED FROM ABOVE THROUGH VERTICAL RACEWAY/COLUMN WRAP. REC SHALL PROVIDE CIRCUIT TO JUNCTION BOX IN JOIST SPACE. REC SHALL PROVIDE CONDUIT AND WIRING TO MAKE FINAL TERMINATIONS AT REQUIRED CASES. COORDINATE CONDUIT DROPS WITHIN 10' OF OTHER TRADES (I.E. REFRIGERATION, PLUMBING). REFER TO ESD-RRIBSD-04 FOR SERVICES CASE SINGLE WIDE ISLANDS. REFER TO ESD-RRIBSD-04A FOR LOW DOUBLE WIDE ISLAND CASES. REFER TO E SERIES SHEETS FOR ESD-0. REFER TO KROGER REFRIGERATION DRAWINGS FOR RIBDS.

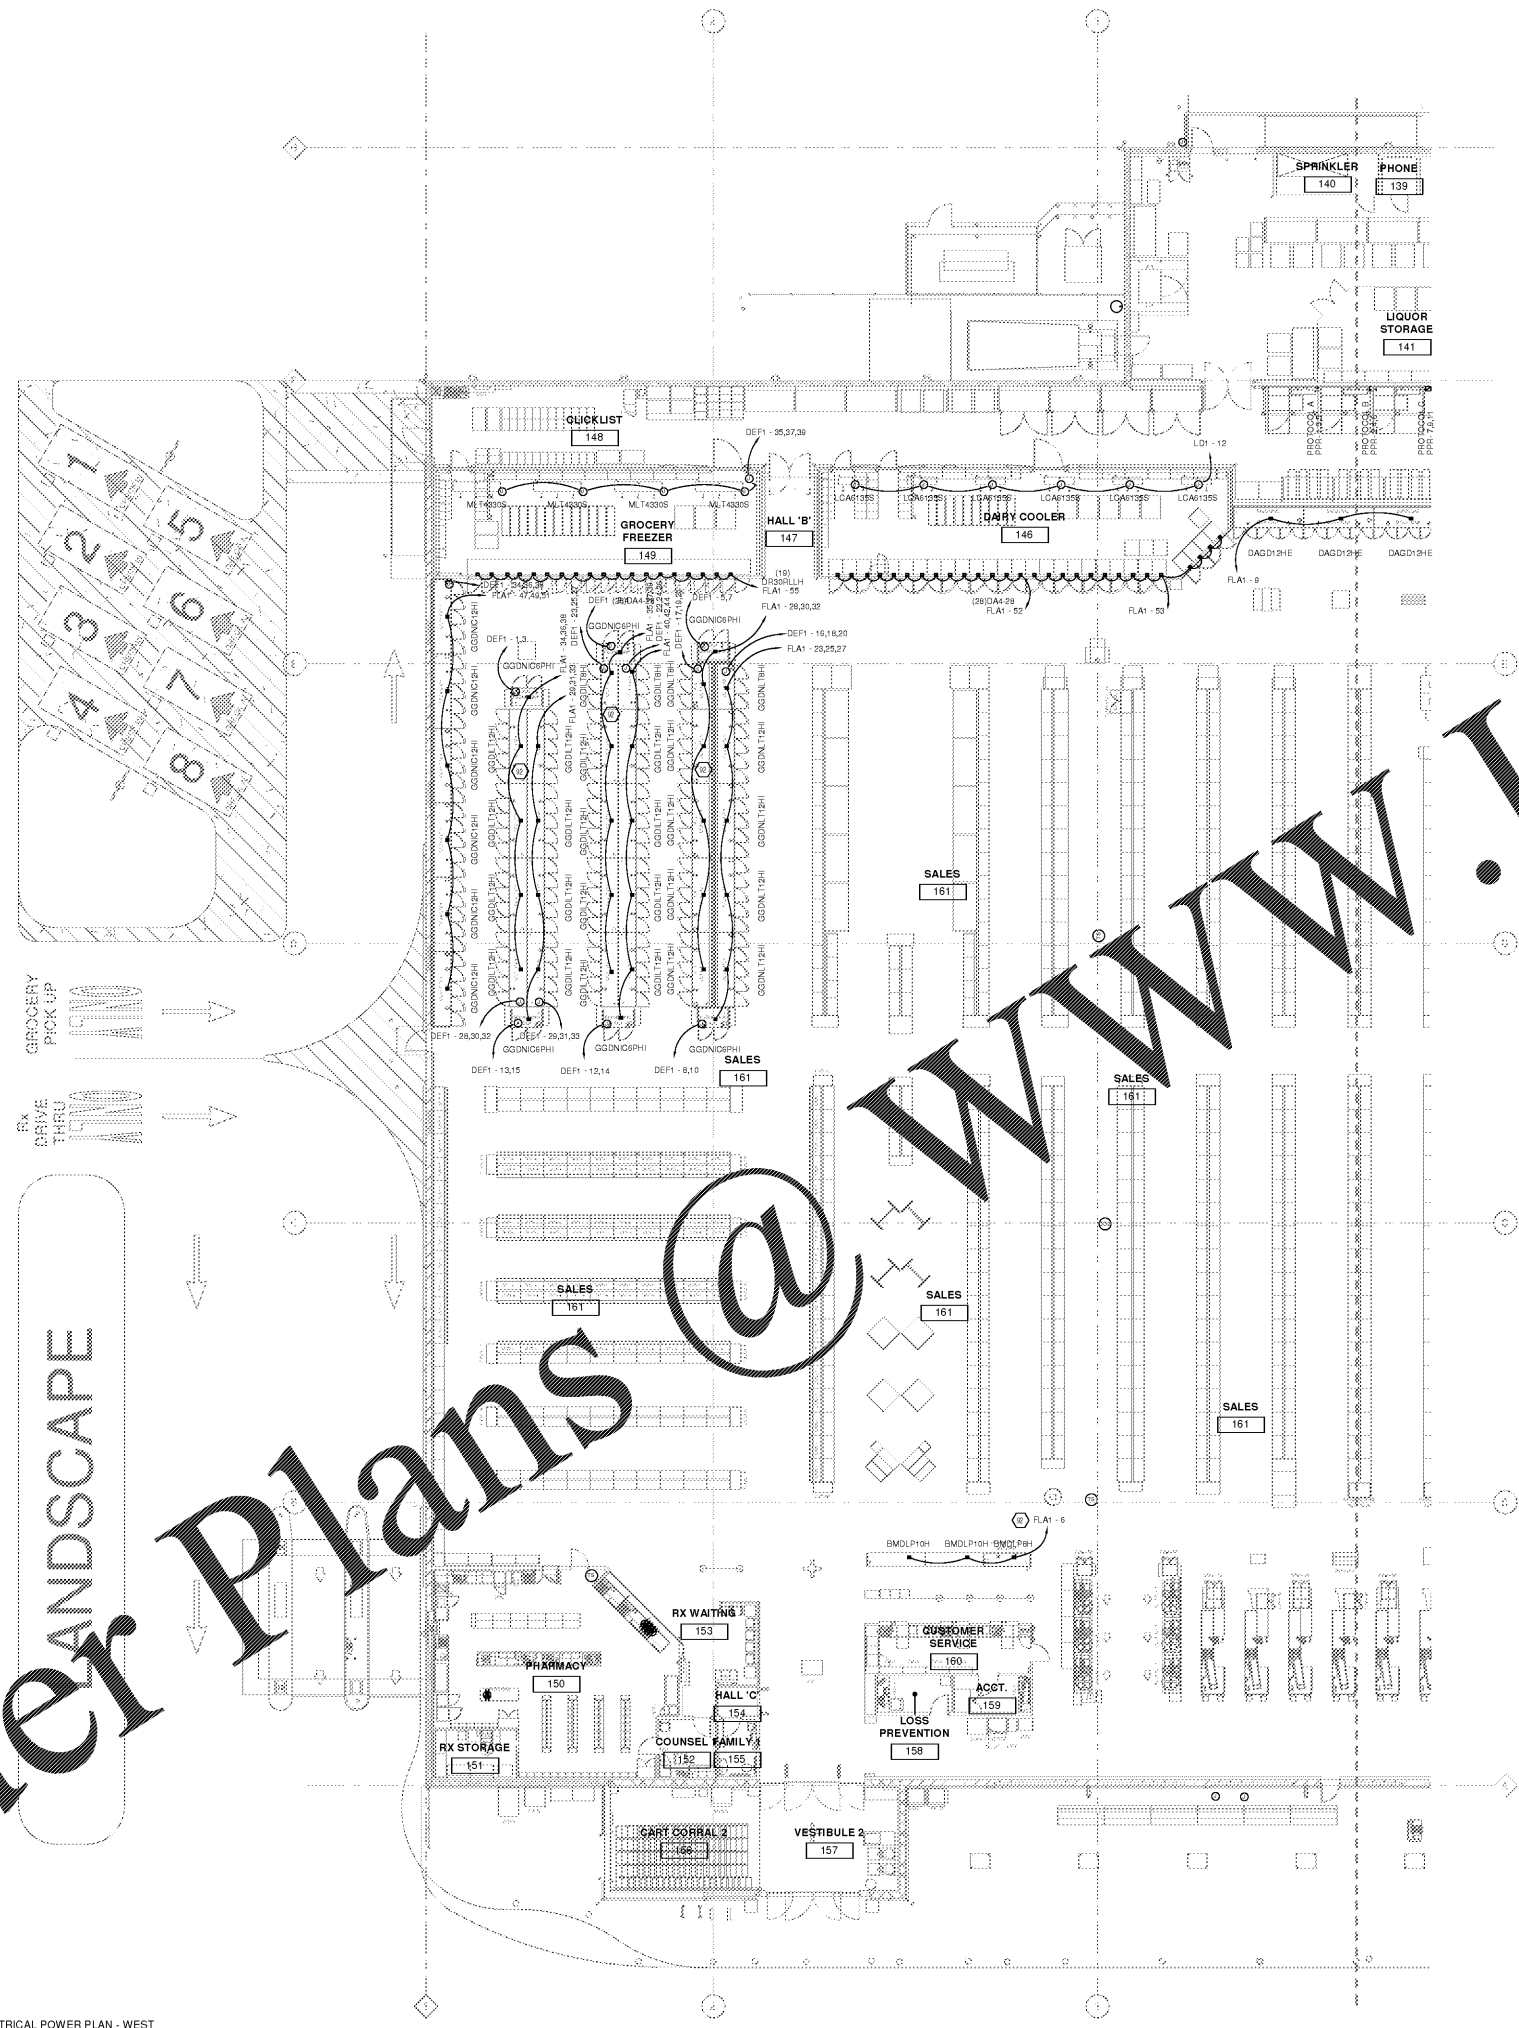

OWNER'S REVIEW OF SERVICE: All notes, specifications, drawings, and instruments provided by the Consultant are instruments of service. Any review, change, specification, or note on these drawings shall be the responsibility of the Consultant. The Consultant shall not be responsible for any errors or omissions in these drawings. 11/10/2018 2:28:17 PM


REFRIGERATION ELECTRICAL POWER PLAN - WEST
3/32" = 1'-0"



2" REFERENCE LINE

Order Plans @ www.LDILine.com

CONSULTANTS
 CINCINNATI 603 Vine Street, Suite 200, Cincinnati, OH 45202
 DENVER 1475 Broadway, Suite 1000, Denver, CO 80202
 SEATTLE 805 4th Avenue, Suite 1000, Seattle, WA 98104

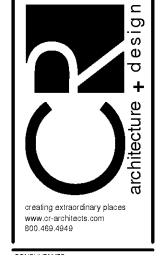

MECHANICAL/ELECTRICAL ENGINEERS
 WWW.KHENGERS.COM
 LEWINGTON, KENTUCKY
 LOUISVILLE, KENTUCKY
 NEW YORK, NEW YORK

OWNER

DATE	ISSUE
10/25/2018	50% OWNER REVIEW
11/01/2018	100% B/PERMIT

DATE	REVISION

PROJECT TITLE
KROGER STORE R543
 MERCURY BLVD.
 HAMPTON, VA
 COMMISSIONING: 5/17/2018
 ISSUE DATE: 10/23/2018
 SHEET TITLE
REFRIGERATION ELECTRICAL POWER PLAN - WEST

SHEET NO.
E1.3.1a
 ©2019 Architectural Artworks, Inc.