


KEYED NOTES

INDICATED CASES FED FROM ABOVE THROUGH VERTICAL RACEWAYS/COLUMN WRAP. RECS SHALL PROVIDE CIRCUIT TO JUNCTION BOX IN JOIST SPACE. REC SHALL PROVIDE CONDUIT AND WIRING TO MAKE FINAL TERMINATIONS AT REQUIRED CASES. COORDINATE CONDUIT DROPS WITHIN 1" OF OTHER TRADES (I.E. REFRIGERATION, PLUMBING). REFER TO ESD-SPRSD-38 FOR SERVICE CASES/SINGLE WIDE ISLANDS. REFER TO ESD-SPRSD-38A FOR LOW/DUAL WIDE ISLAND CASES. REFER TO E SERIES SHEETS FOR ESD-38. REFER TO KROGER REFRIGERATION DRAWINGS FOR RISDS.

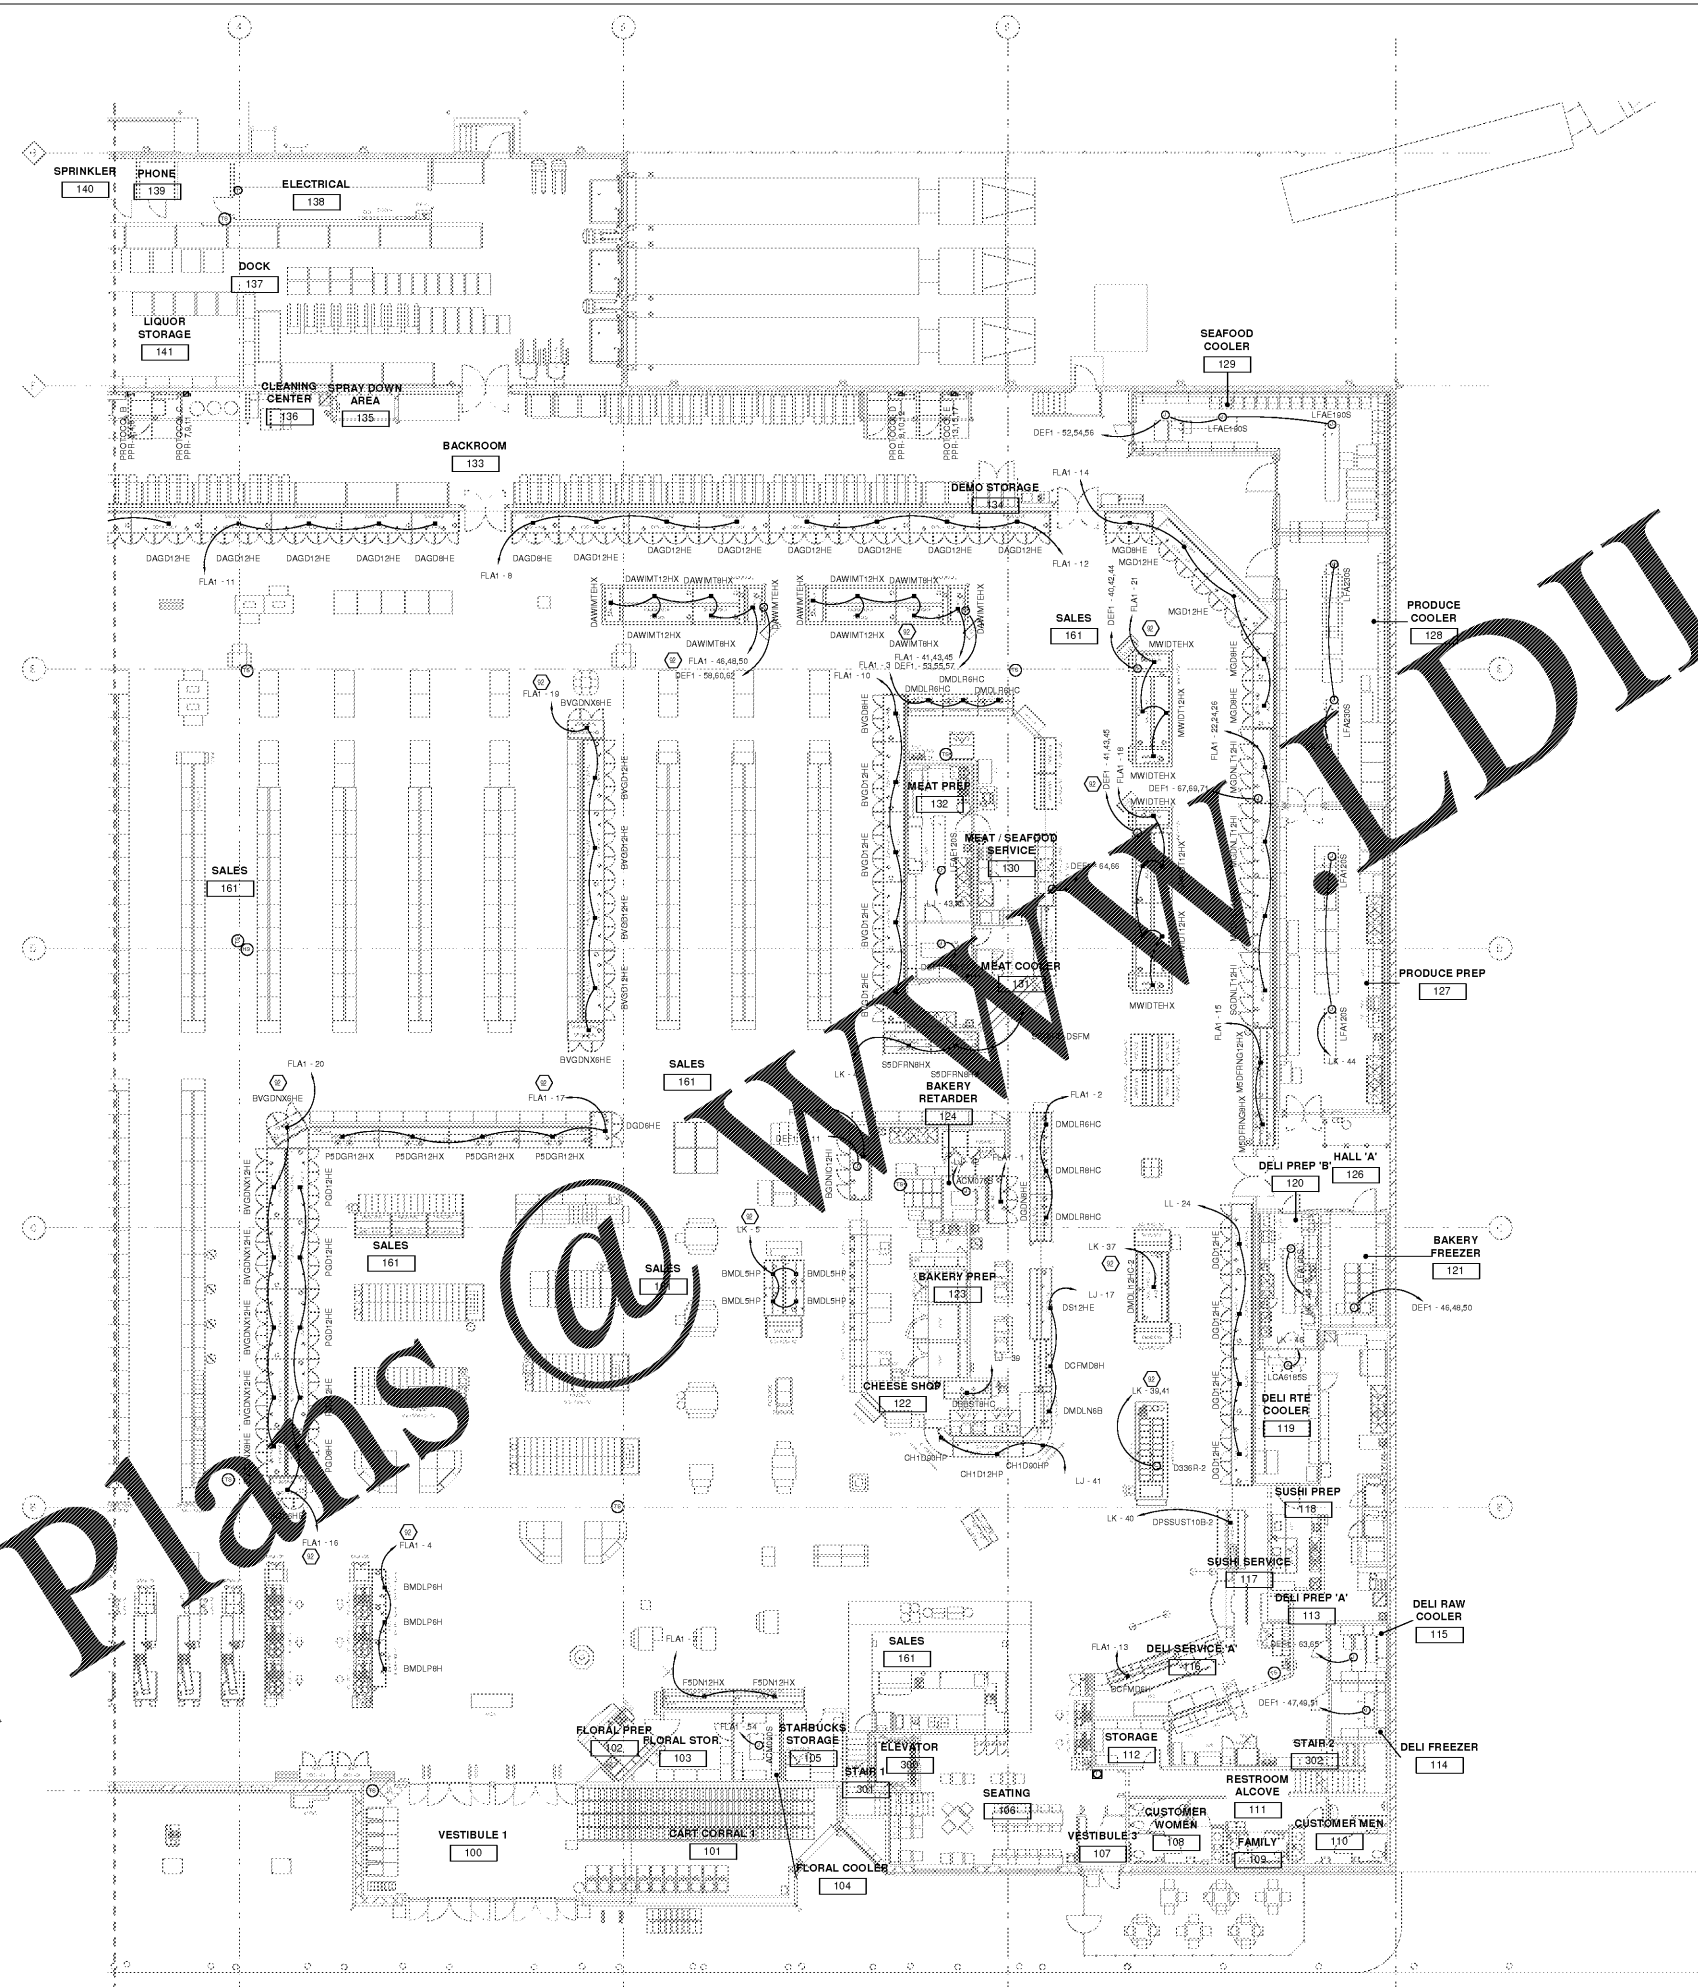

Order Plans @ WWW.LDILine.com

OWNER: KROGER STORE R543
 PROJECT TITLE: KROGER STORE R543
 DATE: 10/23/2019
 SHEET TITLE: REFRIGERATION ELECTRICAL POWER PLAN - EAST

REFRIGERATION ELECTRICAL POWER PLAN - EAST
 3/32" = 1'-0"

CR architecture + design

creating extraordinary places
 www.cr-architects.com
 800-450-6343

CONSULTANTS

SEKHLH ENGINEERS

MECHANICAL/ELECTRICAL ENGINEERS
 WWW.KHENGERS.COM
 LEVINGTON, KENTUCKY
 LOUISVILLE, KENTUCKY
 NEW YORK, NEW YORK

150 ALEXANDRIA PARK SUITE 11
 FT. THOMAS, KENTUCKY 40325
 502-253-9255
 502-442-8256 FAX

OWNER

Kroger

DATE: 10/23/2019
 ISSUE: 10/23/2019
 10% OWNER REVIEW
 100% SUBMIT

DATE	REVISION

PROJECT TITLE: KROGER STORE R543
 MERCURY BLVD. HAMPTON, VA

COMMISSIONING: 5/17/15
 ISSUE DATE: 10/23/2019
 SHEET TITLE: REFRIGERATION ELECTRICAL POWER PLAN - EAST

SHEET NO: E1.3.1b



2" REFERENCE LINE