


**GENERAL REFRIGERANT GAS
DETECTION SYSTEM NOTES**

- A. PROVIDE DANFOSS DGS REFRIGERANT GAS DETECTION SENSORS.
- B. SENSORS SHALL NOT BE INSTALLED IN FRONT OF AN EVAPORATOR. INSTALL IN EVAPORATOR RETURN AIRFLOW ON SIDEWALL OR ON CEILING. IN ROOMS WITH MULTIPLE EVAPORATORS, SENSORS SHOULD BE MOUNTED ON THE CENTRAL LINE BETWEEN ADJACENT EVAPORATORS.
- C. INSTALL SYSTEM PER MANUFACTURER'S RECOMMENDATIONS. PROVIDE COMPLETE AND OPERATIONAL SYSTEM INCLUDING ALL WIRING, CONDUIT, SENSORS, CONTROLLER, ALARMS, AND ACCESSORIES REQUIRED.

KEYED NOTES

LD4 CONNECT SENSOR TO NEAREST RLD5 PANEL.

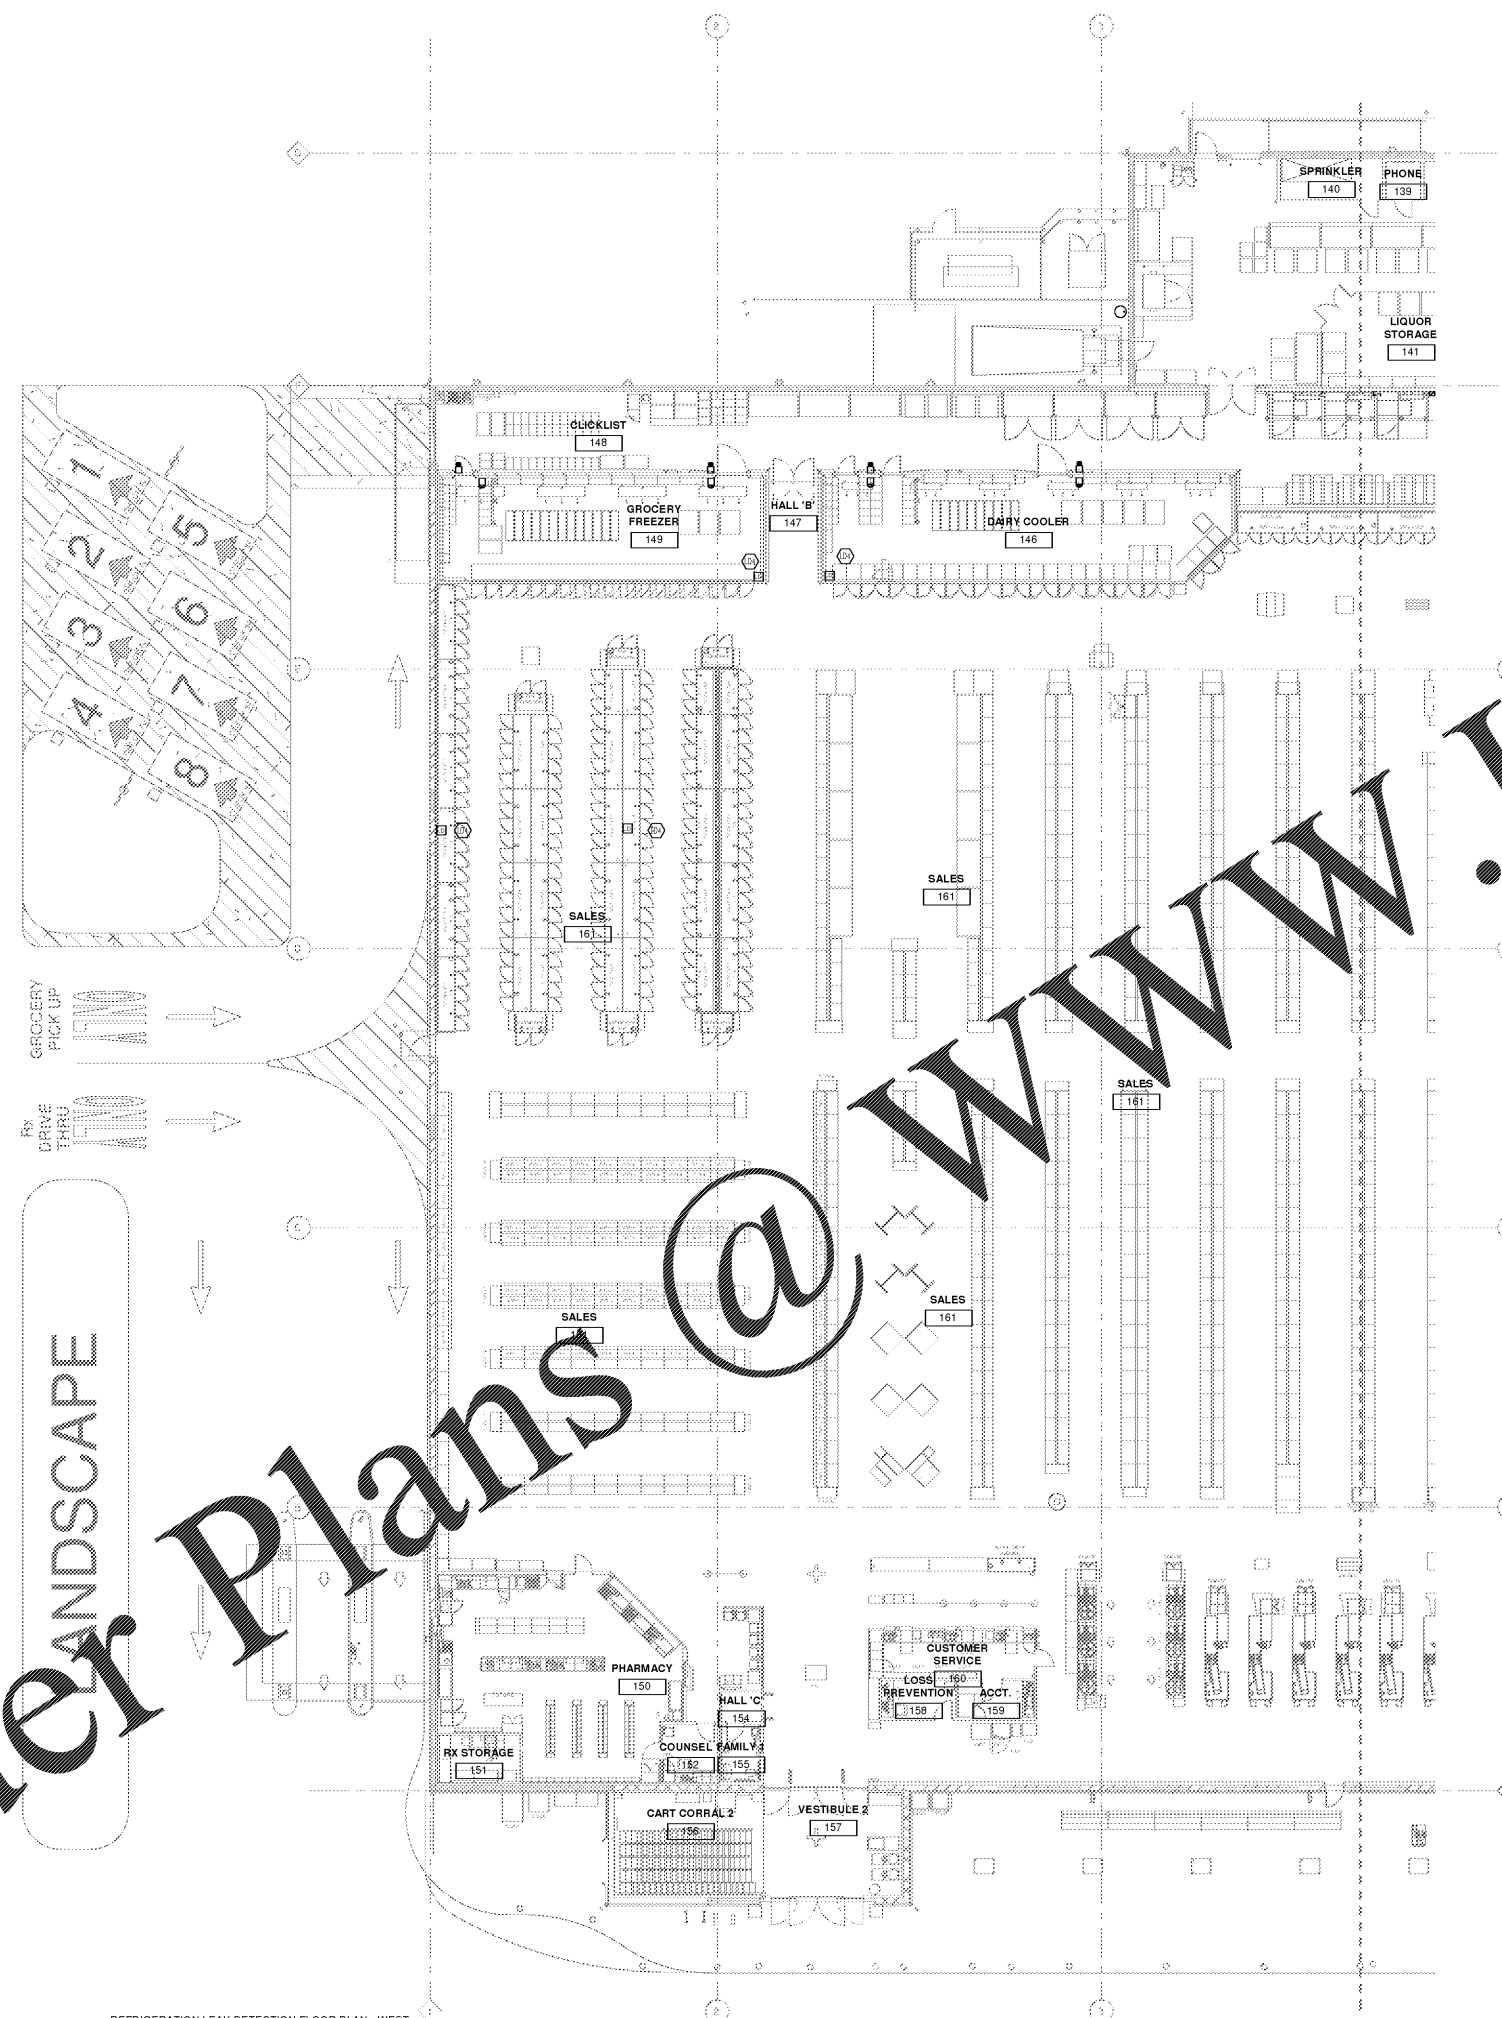


OWNER'S USE ONLY
 THIS DOCUMENT IS THE PROPERTY OF THE CONSULTANT AND IS NOT TO BE REPRODUCED OR COPIED IN ANY MANNER WITHOUT THE WRITTEN CONSENT OF THE CONSULTANT. THE CONSULTANT ASSUMES NO LIABILITY FOR ANY DAMAGE, INCLUDING CONSEQUENTIAL DAMAGES, ARISING FROM THE USE OF THIS DOCUMENT.

REFRIGERATION LEAK DETECTION FLOOR PLAN - WEST
3/32" = 1'-0"

CINCINNATI 603 Vine Street, Suite 200, Cincinnati, OH 45202
 DENVER 1875 Broadway, Suite 200, Denver, CO 80202
 HOUSTON 5310 West Loop South, Suite 400, Houston, TX 77056
 LOS ANGELES 1000 Wilshire Blvd., Suite 200, Los Angeles, CA 90024
 MIAMI 100 Biscayne Blvd., Suite 200, Miami, FL 33132
 MINNEAPOLIS 1000 Hennepin Avenue, Suite 200, Minneapolis, MN 55402
 NEW YORK 100 West Street, Suite 200, New York, NY 10038
 PHOENIX 1000 North Central Expressway, Suite 200, Phoenix, AZ 85004
 PORTLAND 1000 Commercial Street, Suite 200, Portland, OR 97204
 RICHMOND 1000 East Main Street, Suite 200, Richmond, VA 23219
 SEATTLE 1000 First Avenue, Suite 200, Seattle, WA 98101



MECHANICAL/ELECTRICAL
 ENGINEERS
 WWW.KHENGERS.COM
 LEWISTON, KENTUCKY
 LOUISVILLE, KENTUCKY
 NEW YORK, NEW YORK

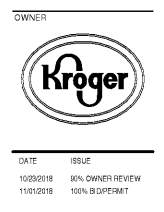

DATE	REVISION
10/23/2018	5% OWNER REVIEW
11/01/2018	100% B/PERMIT

PROJECT TITLE
**KROGER STORE
R543**
 MERCURY BLVD.
 HAMPTON, VA
 COMMISSIONING: 5/17/15
 ISSUE DATE: 10/23/2018
 SHEET TITLE
**REFRIGERATION
LEAK DETECTION
FLOOR PLAN -
WEST**
 SHEET NO.
EM1.2a

Order Plans @ WWW.LDILine.com