




RULE JOY TRAMMELL RUBIC
ARCHITECTURE INTERIOR DESIGN
300 Galleria Parkway Suite 740 Atlanta Georgia 30303
770-661-1492 (phone) 770-661-1493 (fax)
www.rjtinteriordesign.com

PRINTED	
DATE 11/01/18	ISSUE/REVISION Issued for Permit



ISSUED FOR CONSTRUCTION
ENLARGED BOH PARTITION PLAN
EXTENDED STAY AMERICA
COMMISSION NO: 18-276-G
DRAWING NO:
A3.11
FOOLER, GA

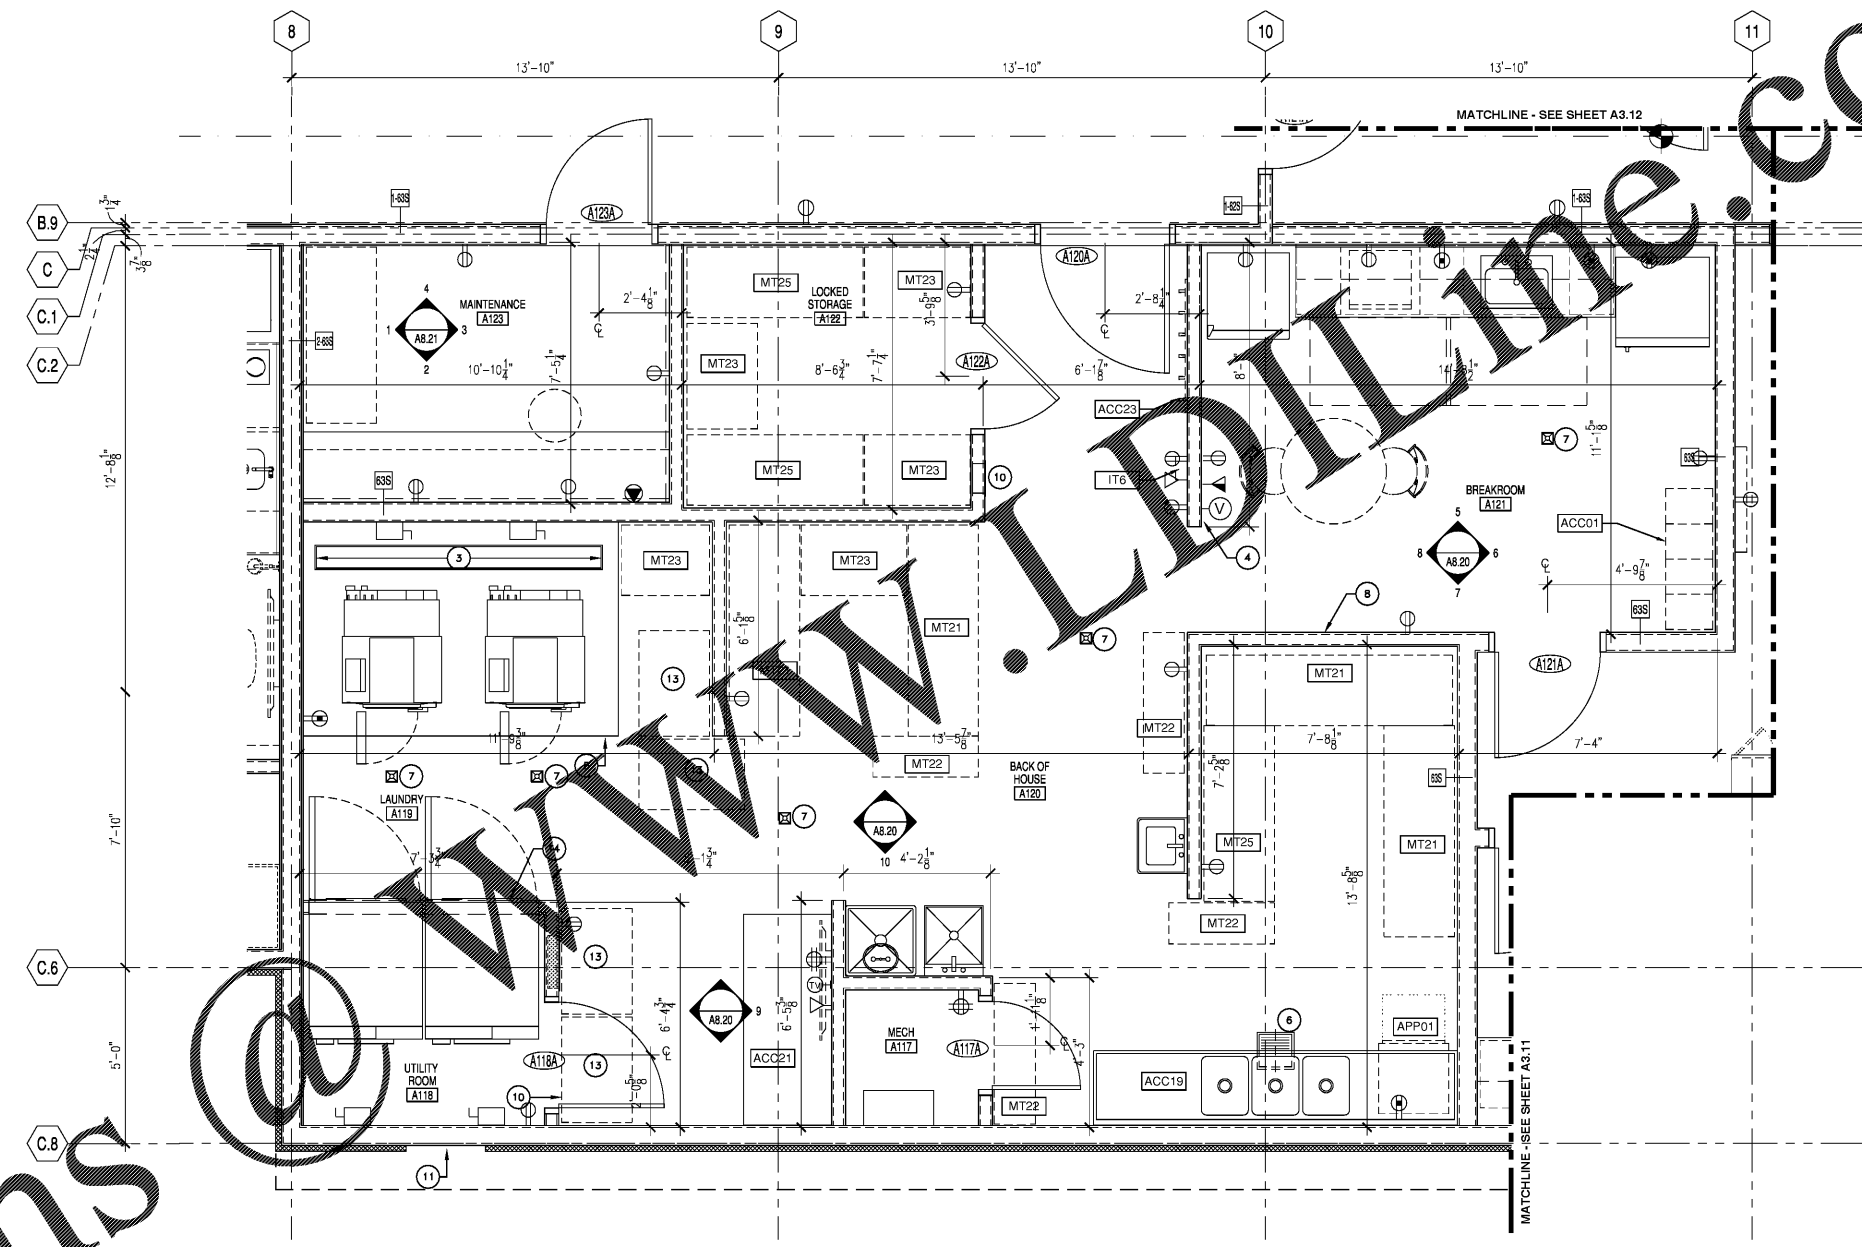

1 ENLARGED BOH PARTITION PLAN
Scale: 1/2"=1'-0"

ENLARGED PLAN KEY NOTES

- | | |
|---|--|
| <ul style="list-style-type: none"> ① PROVIDE STRUCTURAL STEEL SUPPORTS FOR COUNTERTOPS IN STAY-PLAY LAUNDRY; TYPICAL. ② INSTALL ROLLER SHADE (WT21) ON OFFICE SIDE OF WINDOW ③ LAUNDRY TROUGH 12" DEEP X 8-1/2" WIDE. PROVIDE REQUIRED LINT TRAPS PER MANUFACTURER'S REQUIREMENTS. PROVIDE COVER PLATES - APPROPRIATELY SIZED TO ALLOW REMOVAL OF FOR SERVICING. ④ WALL PHONE ⑤ 16"-18" HIGH EQUIPMENT CURB - REFER TO COMMERCIAL WASHER MANUF. FOR REQUIREMENTS ⑥ FLOOR SINK - COORDINATE WITH LOCAL HEALTH CODE FOR REQUIREMENTS ⑦ FLOOR DRAIN, SEE DIFFERENTIATION MATRIX FOR TYPES | <ul style="list-style-type: none"> ⑧ VERIFY REQUIRED WALL OPENING WITH DRYER MANUFACTURERS ⑨ FIRE EXTINGUISHER CABINET ⑩ AIR INTAKE ABOVE DOOR - COORDINATE WITH DRYER MANUF. FOR AREA REQUIREMENTS. ⑪ DRYER EXHAUST LOUVERS - COORDINATE WITH MANUFACTURERS FOR REQUIRED LOUVER AREAS WITHIN ROOM ⑫ INTAKE LOUVER ⑬ MOVEABLE LAUNDRY CART |
|---|--|
- XXXX REFER TO LEGENDS & DIFFERENTIATION MATRIX ON SHEETS AT.06-AT.07 FOR ITEM INFORMATION.

GENERAL NOTES

- 1. DIMENSIONS ARE TO FACE OF STUD.
 - 2. REFER TO EOS DRAWINGS FOR FLOOR DRAIN LOCATIONS.
 - 3. REFER TO INTERIOR ELEVATIONS FOR POWER/DATA LOCATIONS.
 - 4. REFER TO AT.06-AT.07:
- | | |
|----|-----------------------------------|
| A. | FINISHES |
| B. | TOILET ACCESSORIES |
| C. | EQUIPMENT |
| D. | PLUMBING FIXTURES |
| E. | POWER/COMMUNICATION SYMBOL LEGEND |
- 4. WALL PARTITION TYPE SHALL BE 62, UNO.

Order Plans

WWW.LEADLINE.COM