


INTERIOR ELEVATION GENERAL NOTES

- DIMENSIONS ARE TO FACE OF CYP. BOARD, UNO.
- REFER TO SHEETS AT.06 & AT.07 FOR:
 - FINISHES
 - TOILET ACCESSORIES
 - EQUIPMENT
 - PLUMBING FIXTURES
 - INTERIOR ELEVATION SYMBOL LEGEND
 - MILLWORK FINISH LEGEND
- SEE REFLECTED CEILING PLANS FOR CEILING FIXTURE AND DIFFUSER TYPES & LOCATIONS.
- SEE FINISH PLANS FOR FINISH LIMITS.
- SEE SHEET AT.04A & AT.04B FOR TYPICAL ADA CLEARANCES & MOUNTING REQUIREMENTS.
- SEE SHEET A9.01 FOR DOOR SCHEDULE & ELEVATIONS. SEE A5.30 FOR WINDOW ELEVATIONS.
- REFER TO INTERIOR ELEVATIONS FOR BATHROOM ACCESSORY MOUNTING HEIGHTS & POSITIONS.
- REFER TO INTERIOR ELEVATIONS FOR WALL-MOUNTED DEVICE LOCATIONS. ALL OUTLETS CENTERED @ 18" A.F.F., UNL.O. ALL SWITCHES CENTERED @ 48" A.F.F., UNL.O.
- WHERE SWITCHES AND/OR OUTLETS ARE ADJACENT, PLACE IN MULTI-GANG BOX, NOT MULTIPLE SINGLE-GANG BOXES.
- SEE COMPLETE FLOOR PLANS IN A1 SERIES FOR ROOM TYPE LOCATIONS.

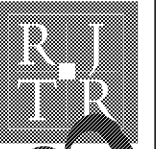

RULE JOY TRAMMELL RUBIO
 ARCHITECTURE INTERIOR DESIGN
 300 California Parkway Suite 740 Atlanta Georgia 30303
 770-661-1492 (phone) 770-661-1493 (fax)
 www.rjtinteriordesign.com

PRINTED

DATE	ISSUE/REVISION
11/01/18	Issued for Permit




ISSUED FOR CONSTRUCTION

SS-K ADA - INTERIOR ELEVATIONS


EXTENDED STAY AMERICA

FOOLER, GA


COMMISSION NO: 18-276-6
 DRAWING NO:
A8.06

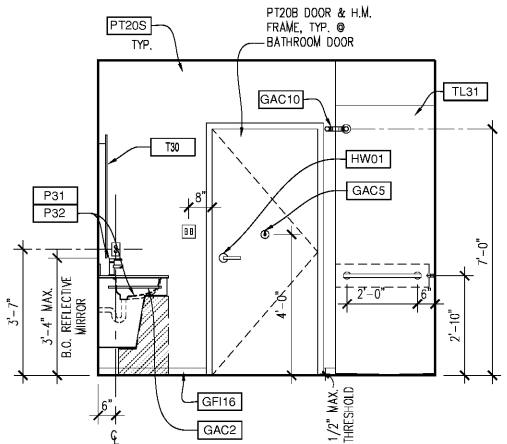


11 ADA ROLL-IN SHOWER ELEVATION
 Scale: 1/2"=1'0"

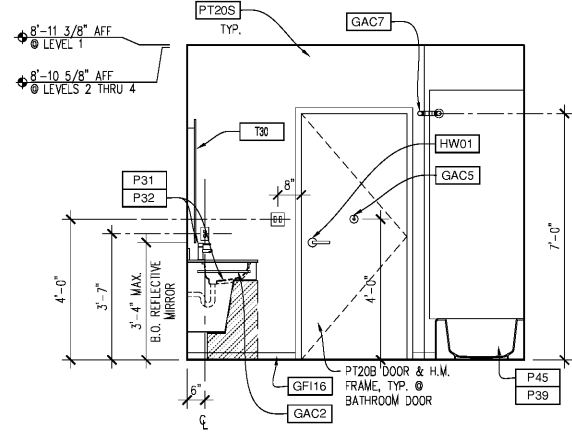


8 ADA BATHROOM ELEVATION
 Scale: 1/2"=1'0"

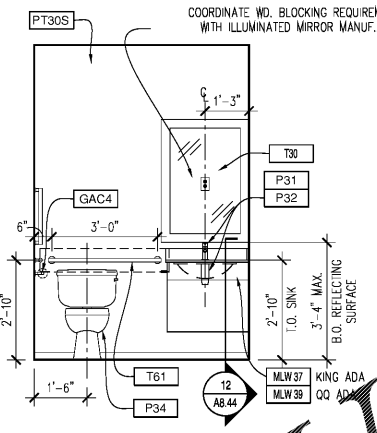


7 ADA LAVATORY ELEVATION
 Scale: 1/2"=1'0"

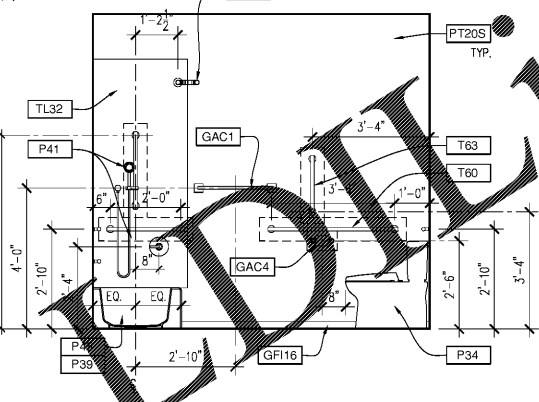


6 ADA BATHROOM ELEVATION
 Scale: 1/2"=1'0"

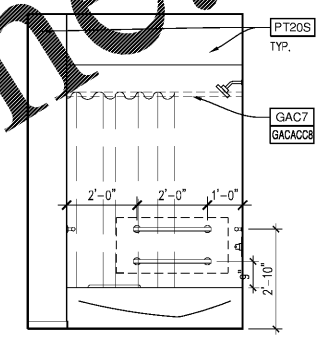


5 ADA TUB ELEVATION
 Scale: 1/2"=1'0"

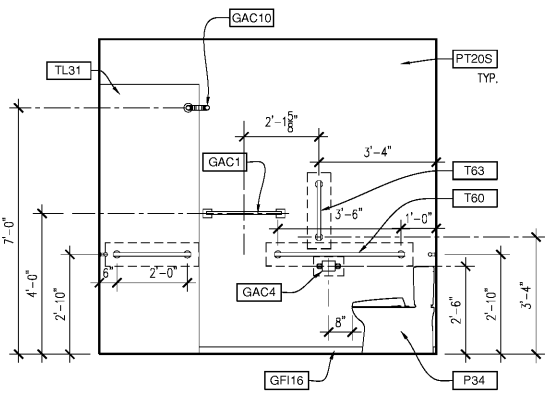


10 ADA ROLL-IN SHOWER ELEVATION
 Scale: 1/2"=1'0"

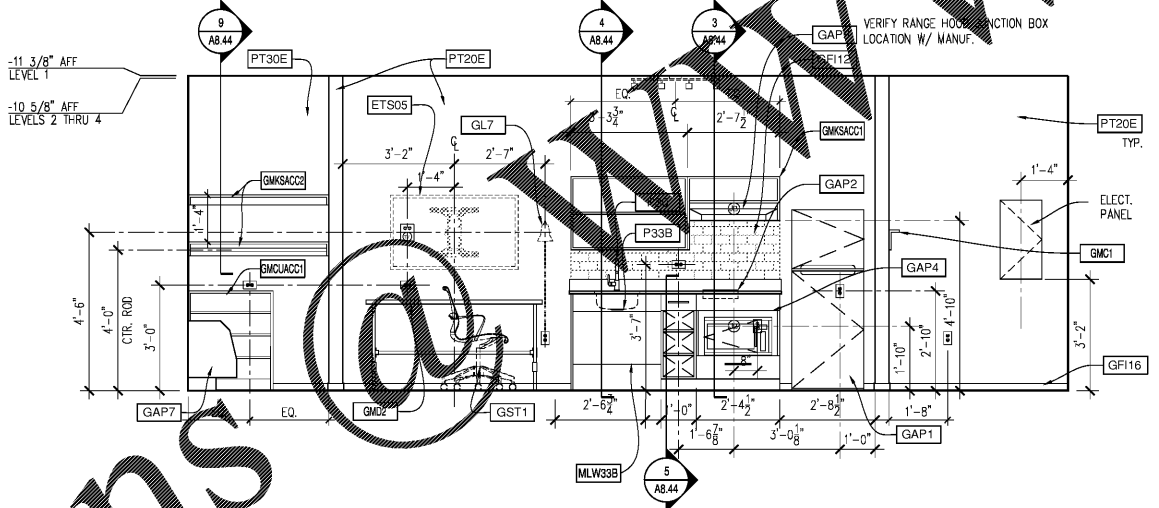


4 KITCHENETTE WALL ELEVATION
 Scale: 1/2"=1'0"

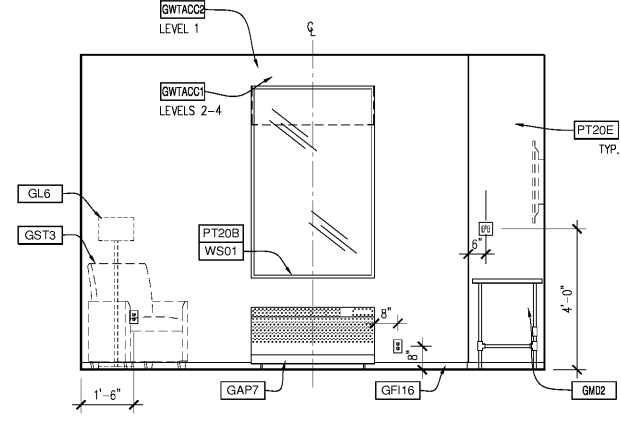


3 EXTERIOR WALL ELEVATION
 Scale: 1/2"=1'0"

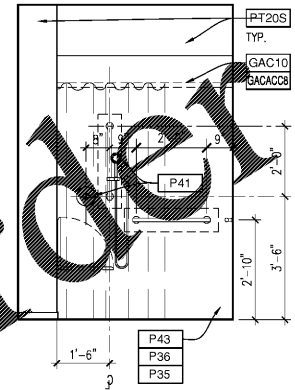

9 ADA ROLL-IN SHOWER ELEVATION
 Scale: 1/2"=1'0"

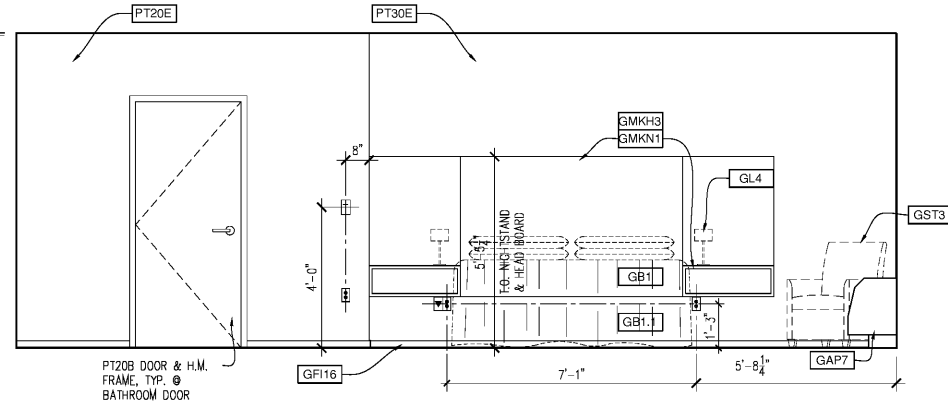

2 BATHROOM ENTRY ELEVATION
 Scale: 1/2"=1'0"

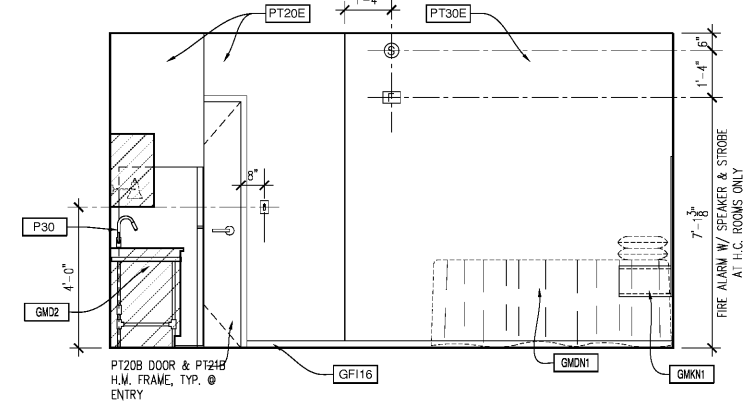

1 BED WALL ELEVATION
 Scale: 1/2"=1'0"

Order Plans @ WWW