



RULE JOY TRAMMELL RUBIO
ARCHITECTURE INTERIORDSIGN
 300 Galleria Parkway Suite 740 Atlanta, Georgia 30338
 770-661-1492 (phone) 770-661-1493 (fax)
 www.rjtrdesign.com

THIS DRAWING IS THE PROPERTY OF RULE JOY TRAMMELL RUBIO ARCHITECTURE INTERIORDSIGN. IT IS TO BE USED ONLY FOR THE PROJECT AND SITE SPECIFICALLY IDENTIFIED HEREIN. ANY REUSE OR REPRODUCTION OF THIS DRAWING WITHOUT THE WRITTEN PERMISSION OF RULE JOY TRAMMELL RUBIO ARCHITECTURE INTERIORDSIGN IS STRICTLY PROHIBITED.

PRINTED


DATE	ISSUE/REVISION
11/01/18	ISSUED FOR PERMIT




EXTENDED STAY AMERICA
 POOLER, GEORGIA

MECHANICAL ROOF PLAN
 COMMISSION NO: 18-120.00
 DRAWING NO:

M1.2

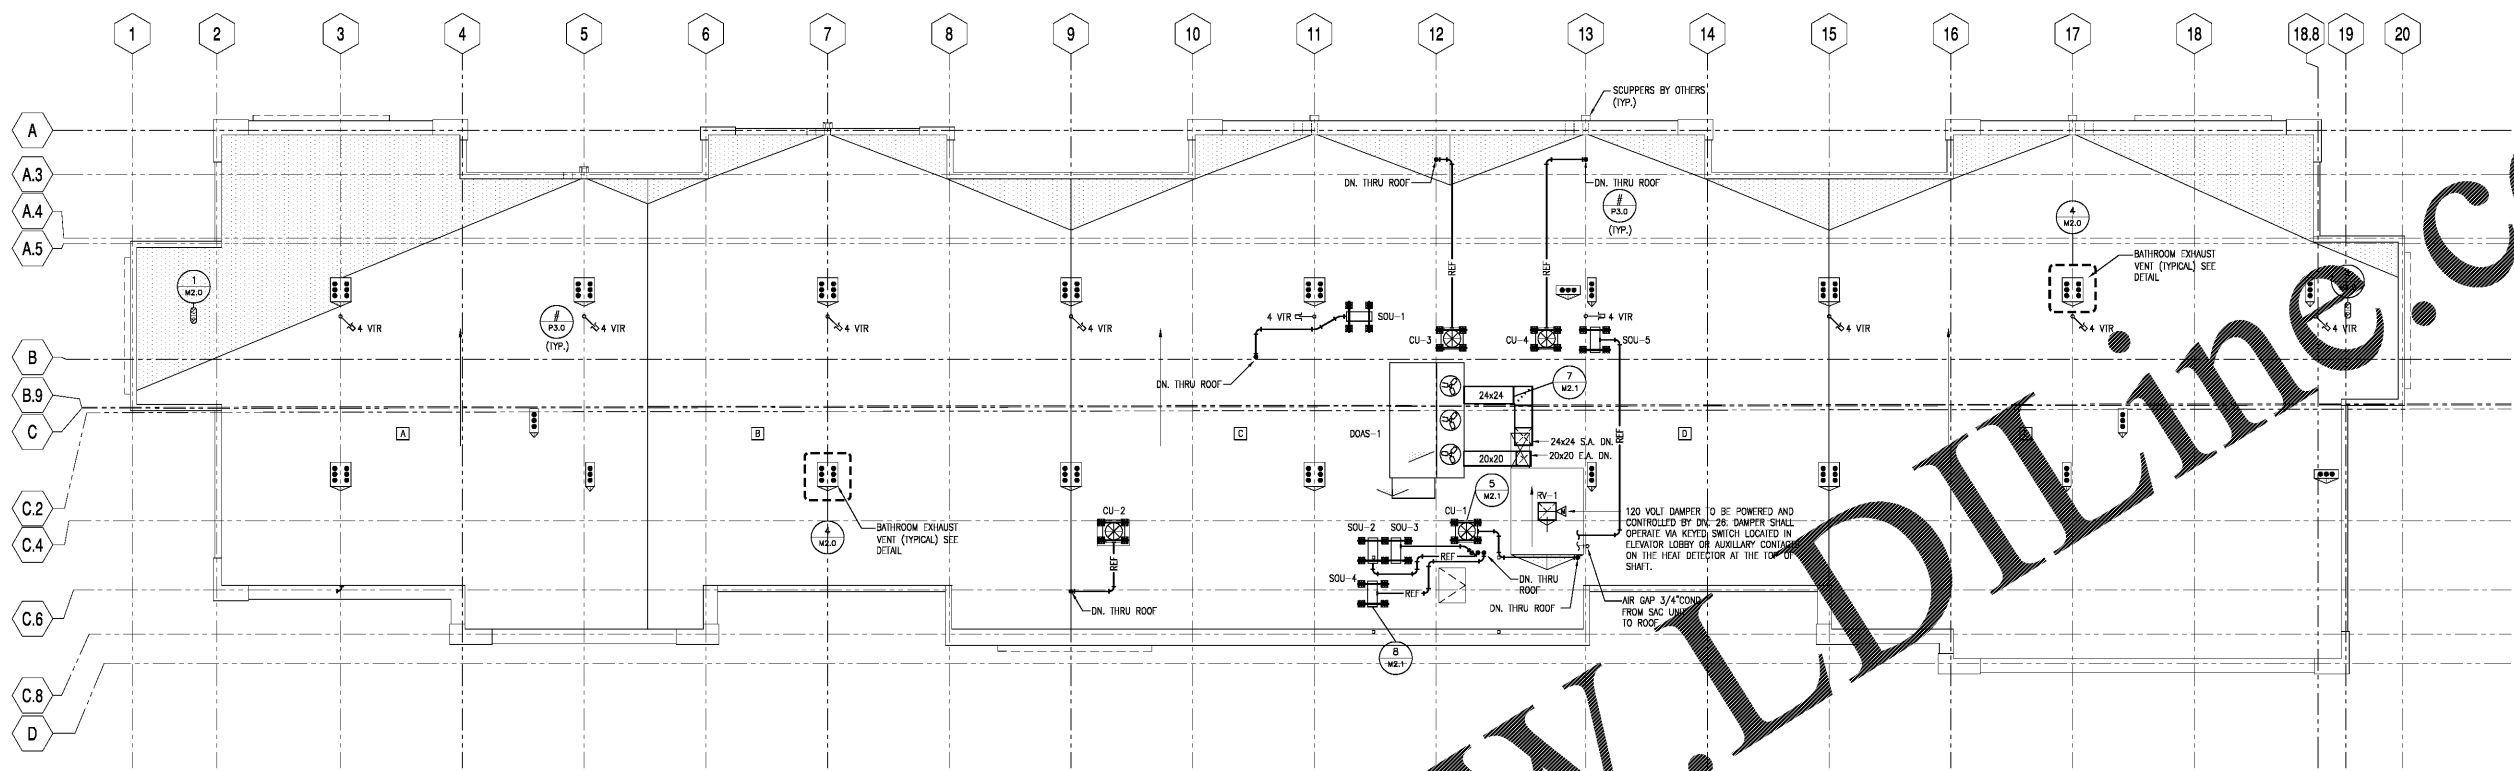

 1 ROOF PLAN - MECHANICAL
 SCALE: 1/8" = 1'-0"



Order Plans @ WWW.LDLINE.COM