



**RULE JOY TRAMMELL RUBIO**  
 ARCHITECTURE INTERIORDSIGN  
 300 Galleria Parkway Suite 740 Atlanta, Georgia 30338  
 770-661-1492 (phone) 770-661-1493 (fax)  
 www.rjtrdesign.com

PRINTED	
DATE	ISSUE/REVISION
11/01/18	ISSUED FOR PERMIT




**EXTENDED STAY AMERICA**

POOLER, GEORGIA


LEVEL 1 ENLARGED HVAC PLAN

COMMISSION NO: 18-120.00  
 DRAWING NO:

**M1.3**

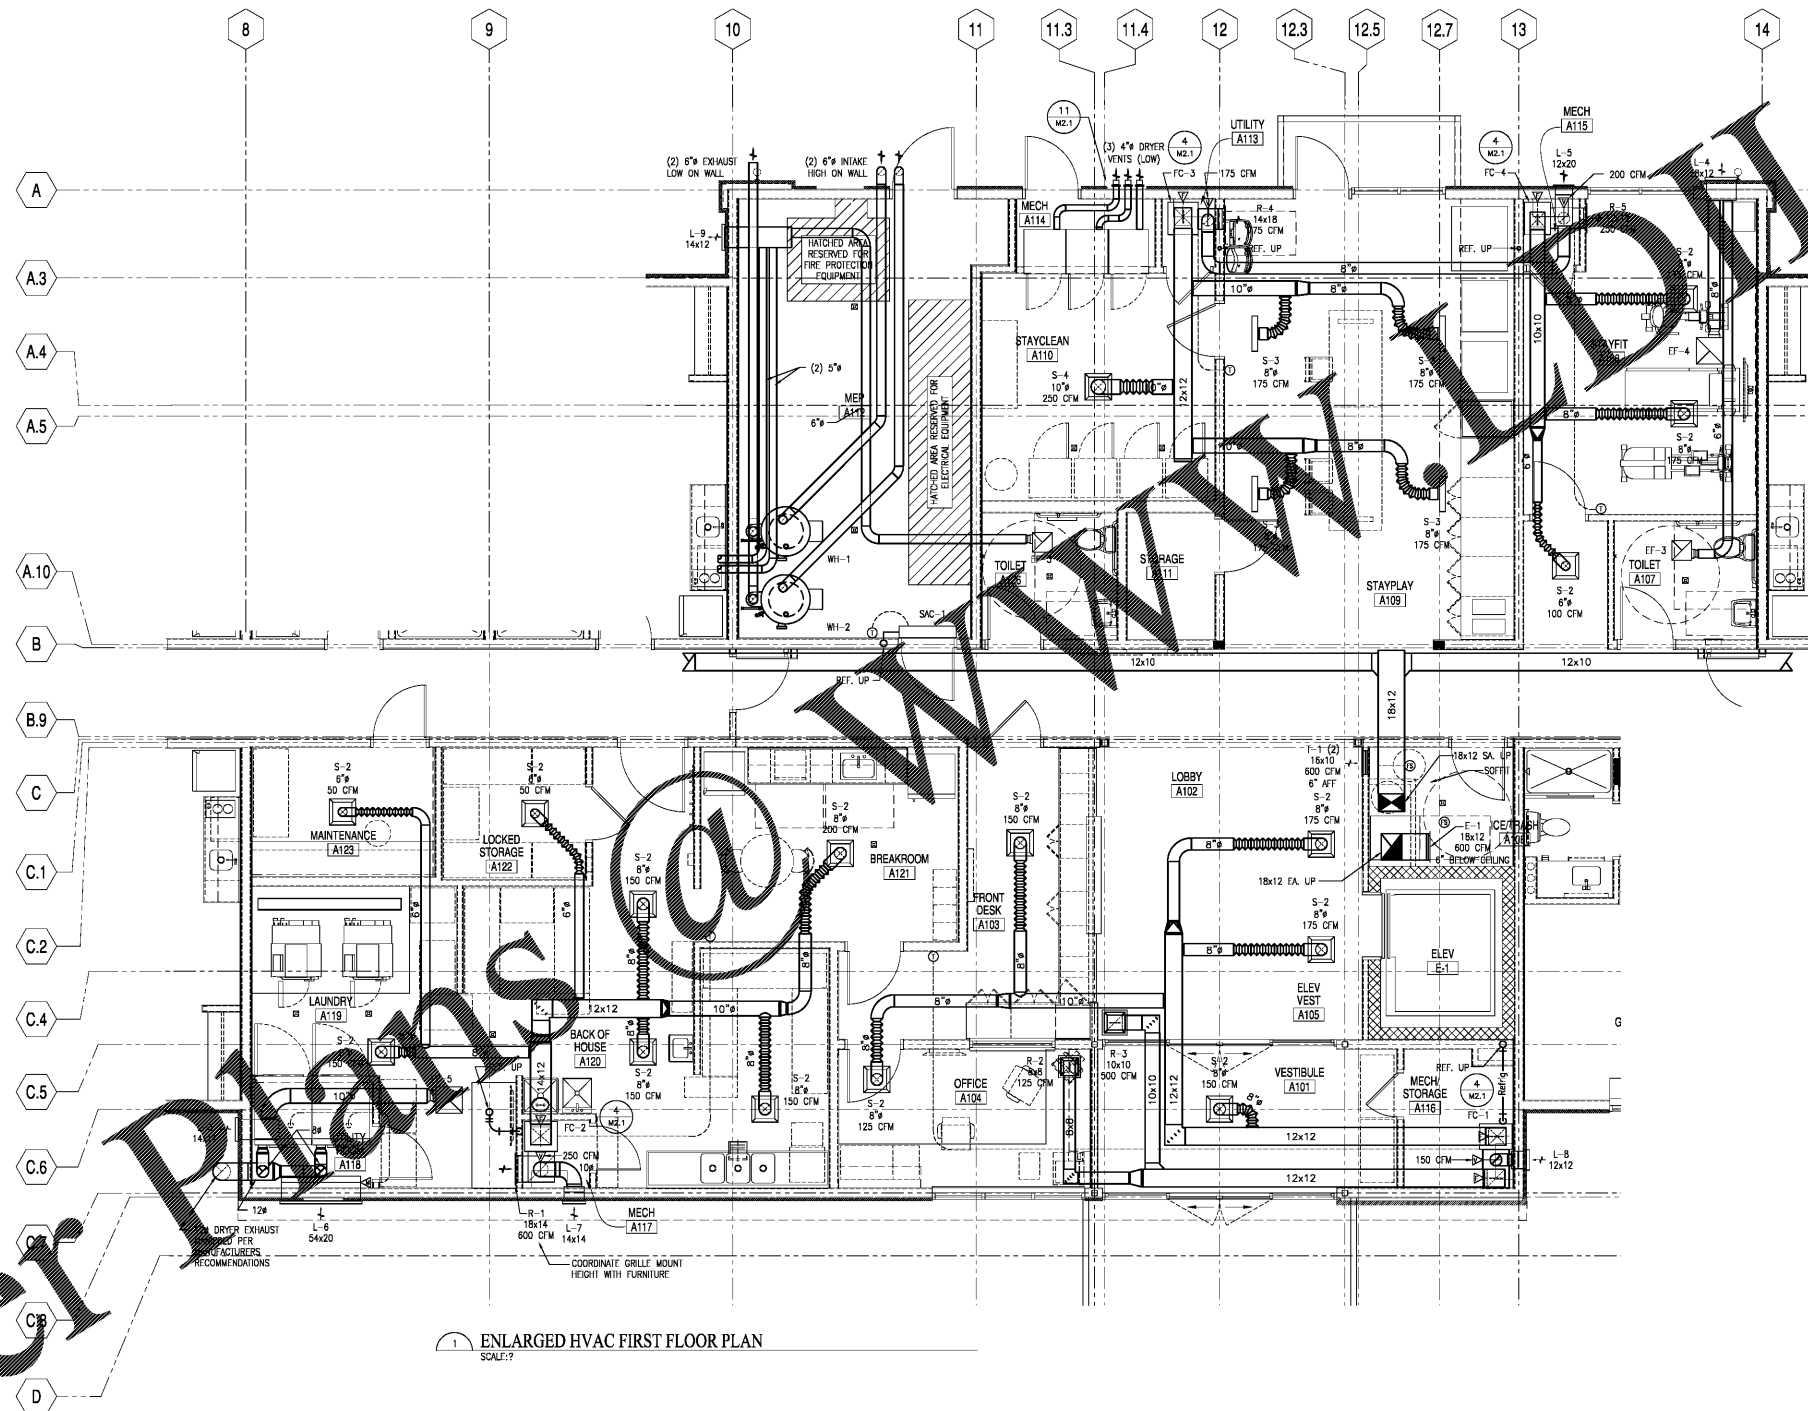

 1 ENLARGED HVAC FIRST FLOOR PLAN  
 SCALE: ?



Order Plans @ [www.rjtrdesign.com](http://www.rjtrdesign.com)