





**RULE JOY TRAMMELL RUBIO**  
 ARCHITECTURE INTERIOR DESIGN  
 300 Galleria Parkway Suite 740 Atlanta, Georgia 30329  
 770-661-1492 (phone) 770-661-1493 (fax)  
 www.rjtdesign.com

PRINTED  
 DATE 11/01/18  
 ISSUE/REVISION ISSUED FOR PERMIT

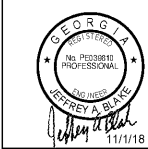

LEVEL TWO FLOOR PLAN - LIGHTING  
**EXTENDED STAY AMERICA**  
 POOLER, GA

COMMISSION NO. 18-120.00  
 DRAWING NO. **E202**

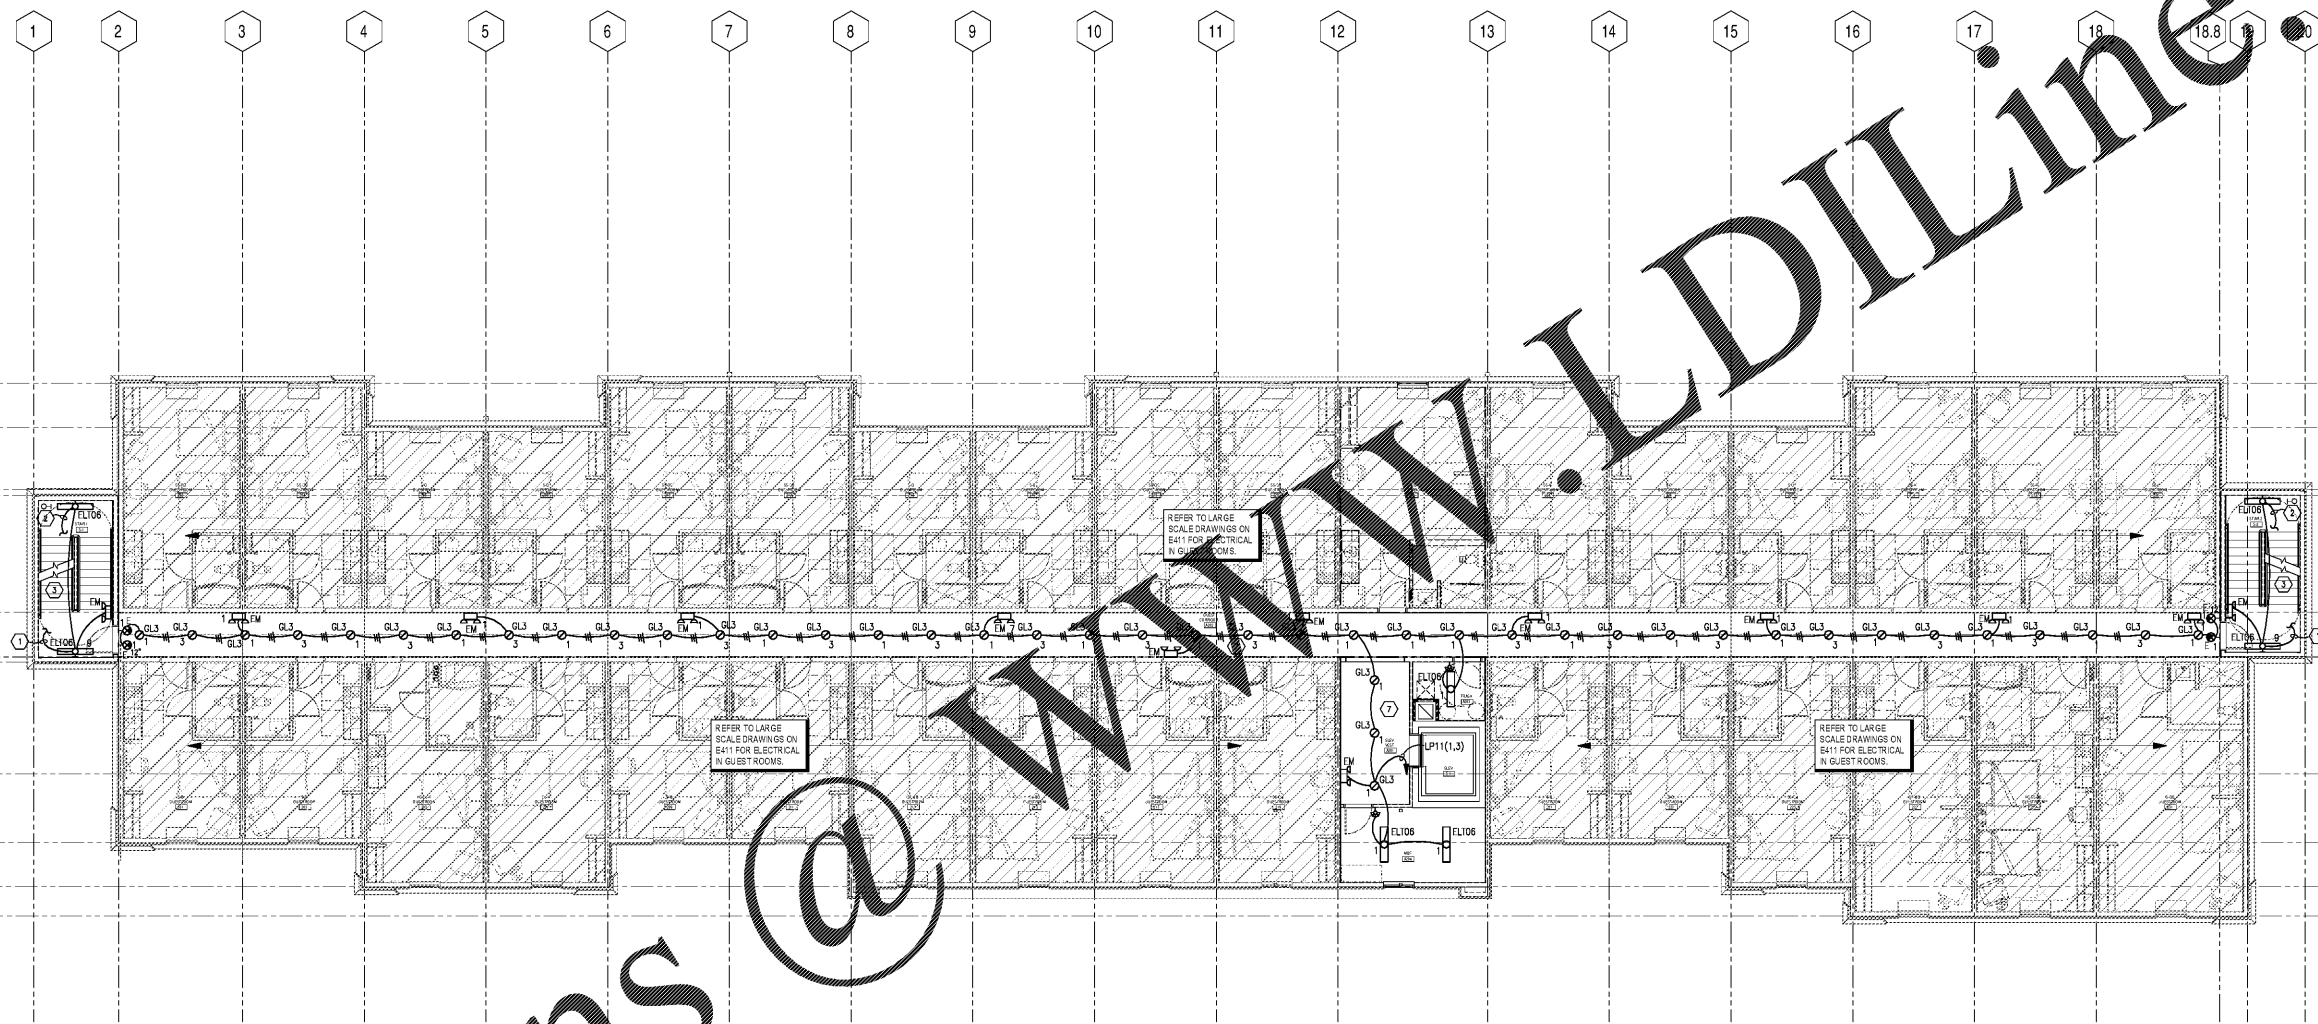

LEVEL TWO FLOOR PLAN - LIGHTING  
 E202

**SHEET NOTES**

- 1 FROM LIGHT AT STAIR BELOW.
- 2 TO LIGHT AT STAIR ABOVE.
- 3 LIGHTS IN STAIRWELL SHALL BE WIRED FOR ALWAYS ON OPERATION.
- 4 PROVIDE 120V CONNECTIONS FOR SIGN. COORDINATE ROUGH-IN LOCATIONS AND QUANTITY WITH SIGN SUPPLIER. PROVIDE DISCONNECT AS REQUIRED BY NEC.
- 5 ROUTE THROUGH LIGHTING CONTROL CONTACTOR. SEE E701.
- 6 INSTALL SIGN CONTROL CONTACTOR AND LIGHTING CONTROL NEXT TO PANEL LP41.
- 7 CORRIDOR LIGHTING SHALL BE CIRCUITED FOR ALWAYS ON OPERATION.

**GENERAL NOTES**

- A. SEE DRAWING E701 FOR LIGHT FIXTURE SCHEDULE.
- B. EXIT, EMERGENCY, AND NIGHT LIGHTS SHALL BE CIRCUITED TO UNSWITCHED CONDUCTOR.
- C. PROVIDE ALL BRANCH CIRCUIT WIRING AS REQUIRED FOR COMPLETE INSTALLATION AND OPERATION. PROVIDE ALL 0-10V WIRING AS REQUIRED FOR COMPLETE INSTALLATION AND OPERATION. 0-10V WIRING SHALL BE IN CONDUIT WHERE CEILINGS ARE EXPOSED OR BE PLENUM RATED CABLE ABOVE ACCESSIBLE CEILINGS AND COMPLY WITH NEC CLASS 2 WIRING METHODS.
- D. PROVIDE A SEPARATE NEUTRAL FOR EACH CIRCUIT. MULTI-WIRE BRANCH CIRCUITS ARE NOT PERMITTED UNLESS NOTED OTHERWISE.
- E. LIGHTING CONTROL SYSTEM OCCUPANCY SENSORS ARE SHOWN FOR BIDDING PURPOSES. SYSTEM SUPPLIER SHALL PROVIDE SHOP DRAWINGS INDICATING BEST SENSOR PLACEMENT AND QUANTITIES FOR PROPER COVERAGE AND OPERATION TO COMPLY WITH REQUIREMENTS.
- F. REFER TO ARCHITECTURAL REFLECTED CEILING PLANS FOR EXACT LOCATIONS OF LIGHT FIXTURES.
- G. REFER TO ARCHITECTURAL DRAWINGS FOR LOCATIONS OF EXITS AND CHEVRON ARROW INDICATIONS.
- H. VERIFY CEILING CONSTRUCTION WITH ARCHITECTURAL DRAWINGS AND GENERAL CONTRACTOR. PROVIDE ALL NECESSARY MOUNTING HARDWARE FOR COMPLETE INSTALLATION OF LIGHT FIXTURES.
- I. WHERE RECESSED FIXTURES ARE INSTALLED IN FIRE RATED CEILINGS, PROVIDE FIRE RATED BOX OR ENCLOSURE AS REQUIRED BY CODE TO MAINTAIN RATING OF CEILING.
- J. COORDINATE LIGHT FIXTURE LOCATIONS AND RACKWAY INSTALLATION WITH MECHANICAL EQUIPMENT AND DUCTWORK AND PIPING SYSTEMS PRIOR TO ROUGH-IN. LIGHT FIXTURE LOCATIONS TAKE PRECEDENCE.
- K. CAULK/SEAL ALL WALL PENETRATIONS WITH APPROPRIATE SEALANT. PENETRATIONS THROUGH FIRE RATED WALLS/CEILINGS SHALL BE SEALED WITH AN APPROVED FIRESTOP SYSTEM FOR THE RATING OF THE ASSEMBLY.
- L. DO NOT INSTALL CONDUITS EXPOSED ON EXTERIOR OF BUILDING. CONDUITS SHOWN ARE TO PROVIDE DESIGN INTENT OF CIRCUITING AND CONTROL.

Order Plans @ WWW.LDILine.com