



RULE JOY TRAMMELL RUBIO
 ARCHITECTURE INTERIOR DESIGN
 300 Galleria Parkway Suite 740 Atlanta, Georgia 30329
 770-661-1492 (phone) 770-661-1493 (fax)
 www.rtrdesign.com


PRINTED
 DATE 11/01/18
 ISSUE/REVISION ISSUED FOR PERMIT

JB Electrical Design, P.C.
 Electrical Consulting Engineers
 9330 Birchmont N.
 Minneapolis, MN 55445
 763.486.0965
 jrb@jb-electrical.com
 REG. Prof. No. 2013-063
 ©2018 by JB Electrical Design, P.C.




LEVEL THREE AND FOUR FLOOR PLANS - LIGHTING
EXTENDED STAY AMERICA
 POOLER, GA

COMMISSION NO. 18-120-00
 DRAWING NO:
E203

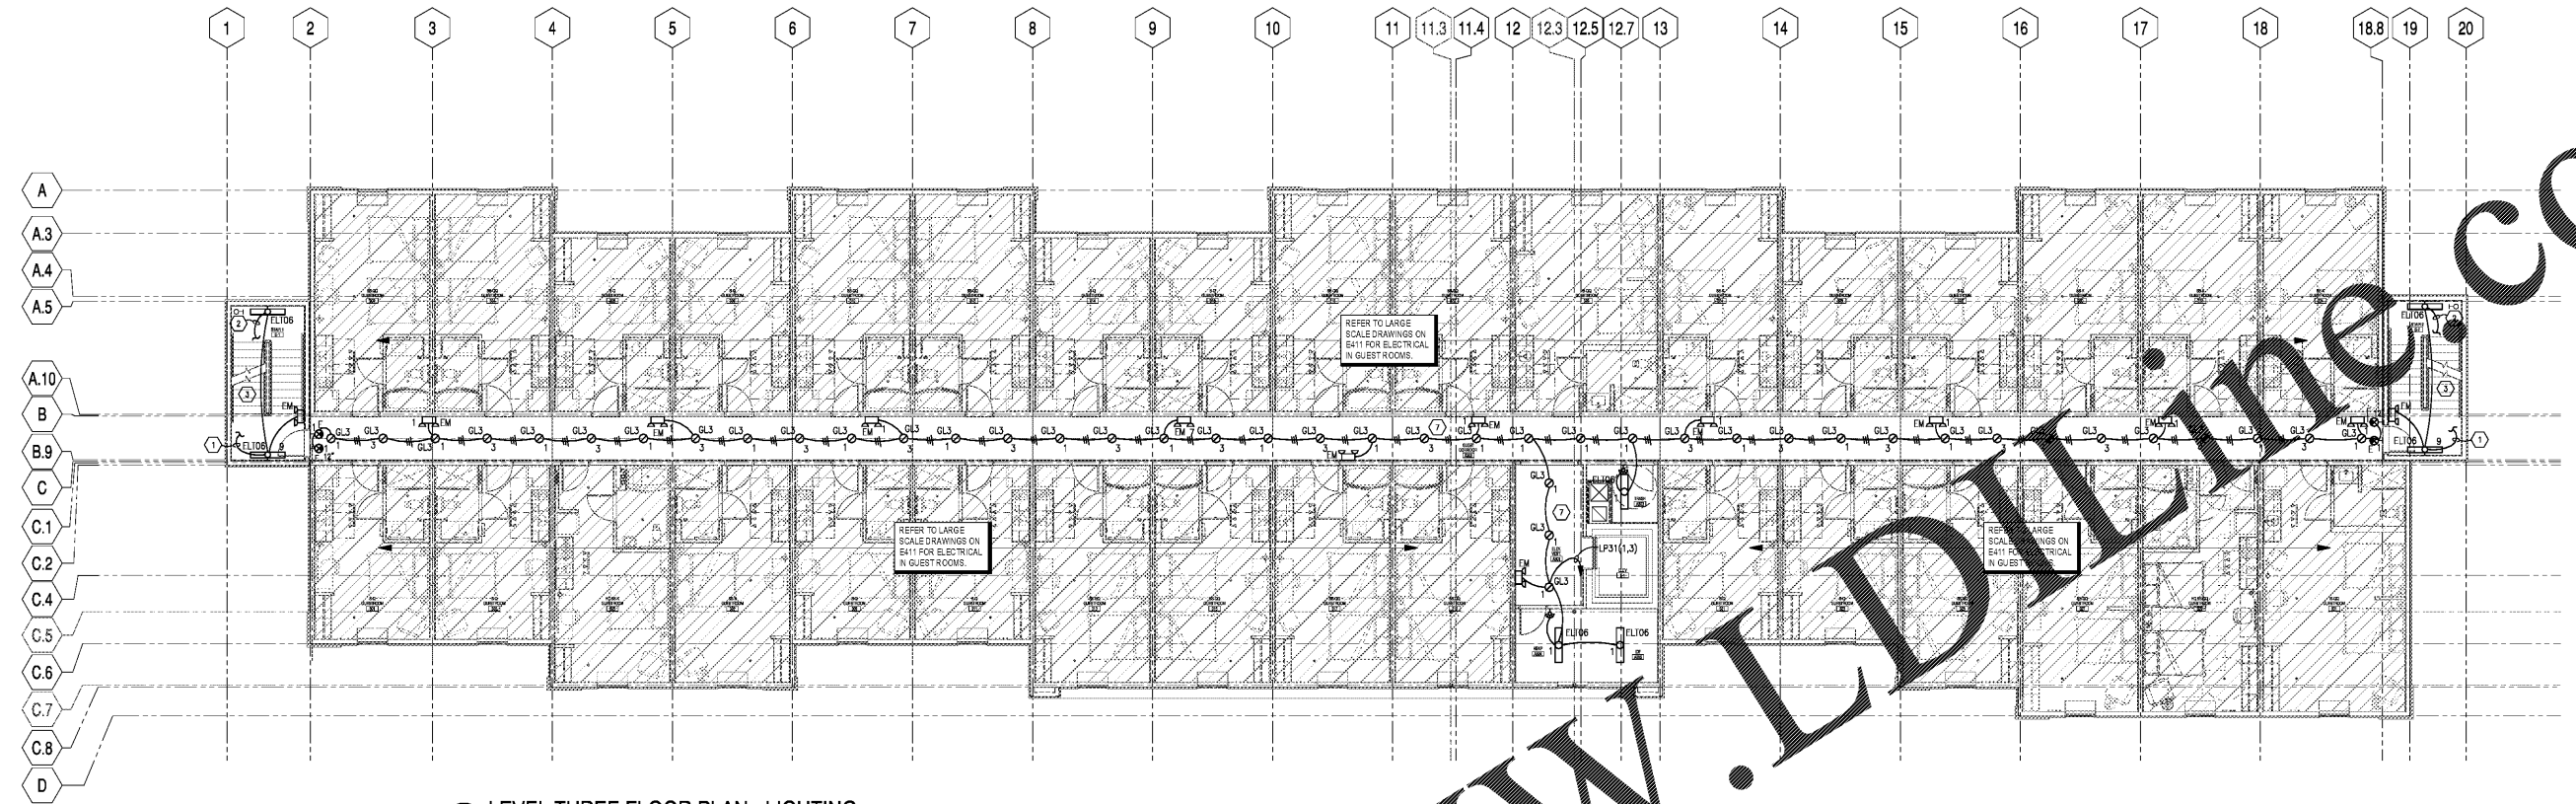

1 LEVEL THREE FLOOR PLAN - LIGHTING
 E203 1/8" = 1'-0"

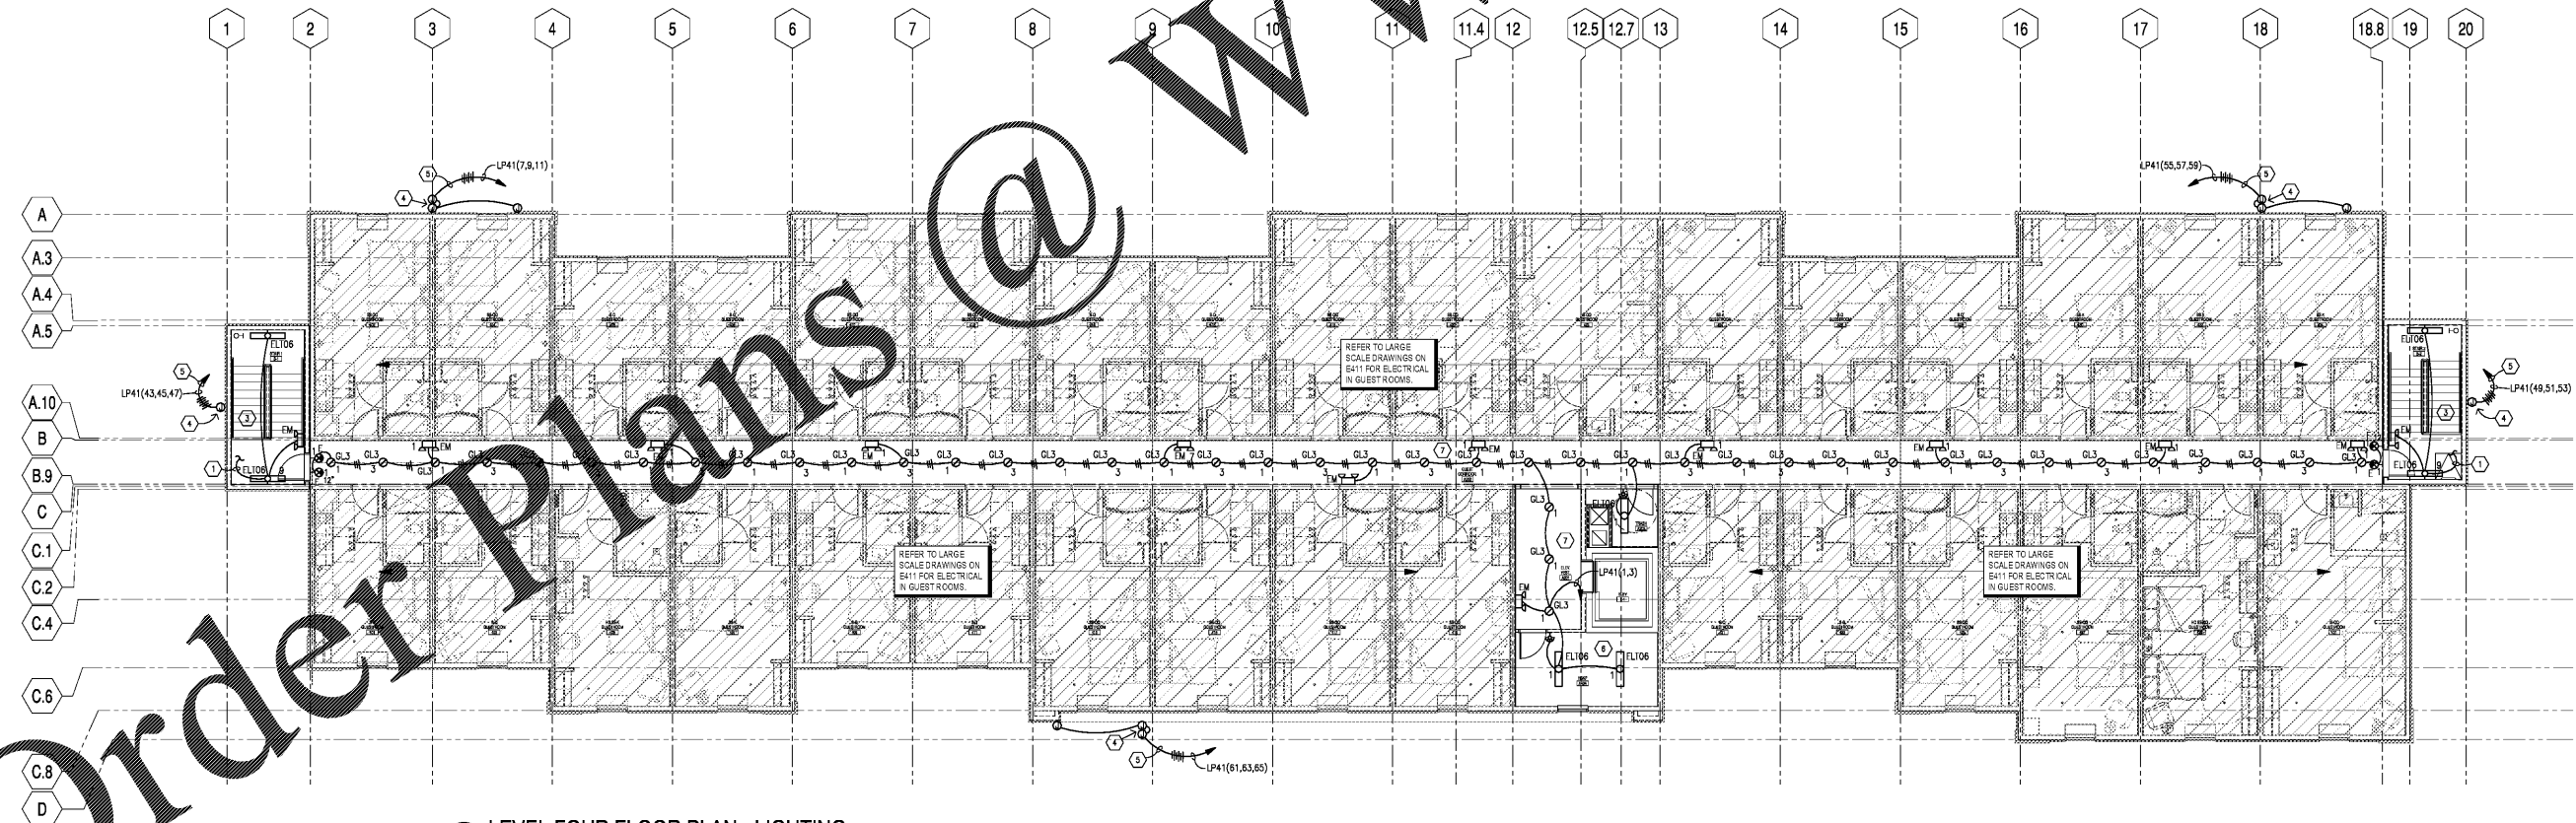

2 LEVEL FOUR FLOOR PLAN - LIGHTING
 E203 1/8" = 1'-0"

GENERAL NOTES
 A. REFER TO DRAWING E202 FOR GENERAL AND SHEET NOTES.

Order Plans @ WWW.LDLINE.COM