




RULE JOY TRAMMELL RUBIO
 ARCHITECTURE INTERIOR DESIGN
 300 Galleria Parkway Suite 740 Atlanta, Georgia 30329
 770-661-1492 (phone) 770-661-1493 (fax)
 www.rjtdesign.com


PRINTED
 DATE 11/01/18
 ISSUE/REVISION
 ISSUED FOR PERMIT

JB Electrical Design, P.C.
 Electrical Consulting Engineers
 9330 29th Ave N
 Minneapolis, MN 55445
 762.486.0965
 jrb@jb-electrical.com
 MEI Lic. No. 2013-062
 © 2018 by JB Electrical Design, P.C.

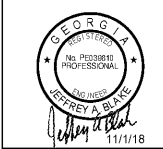


LEVEL THREE AND FOUR FLOOR PLANS - POWER & SYSTEMS
EXTENDED STAY AMERICA
 POOLIER, GA

COMMISSION NO. 18-120-00
 DRAWING NO:
E303

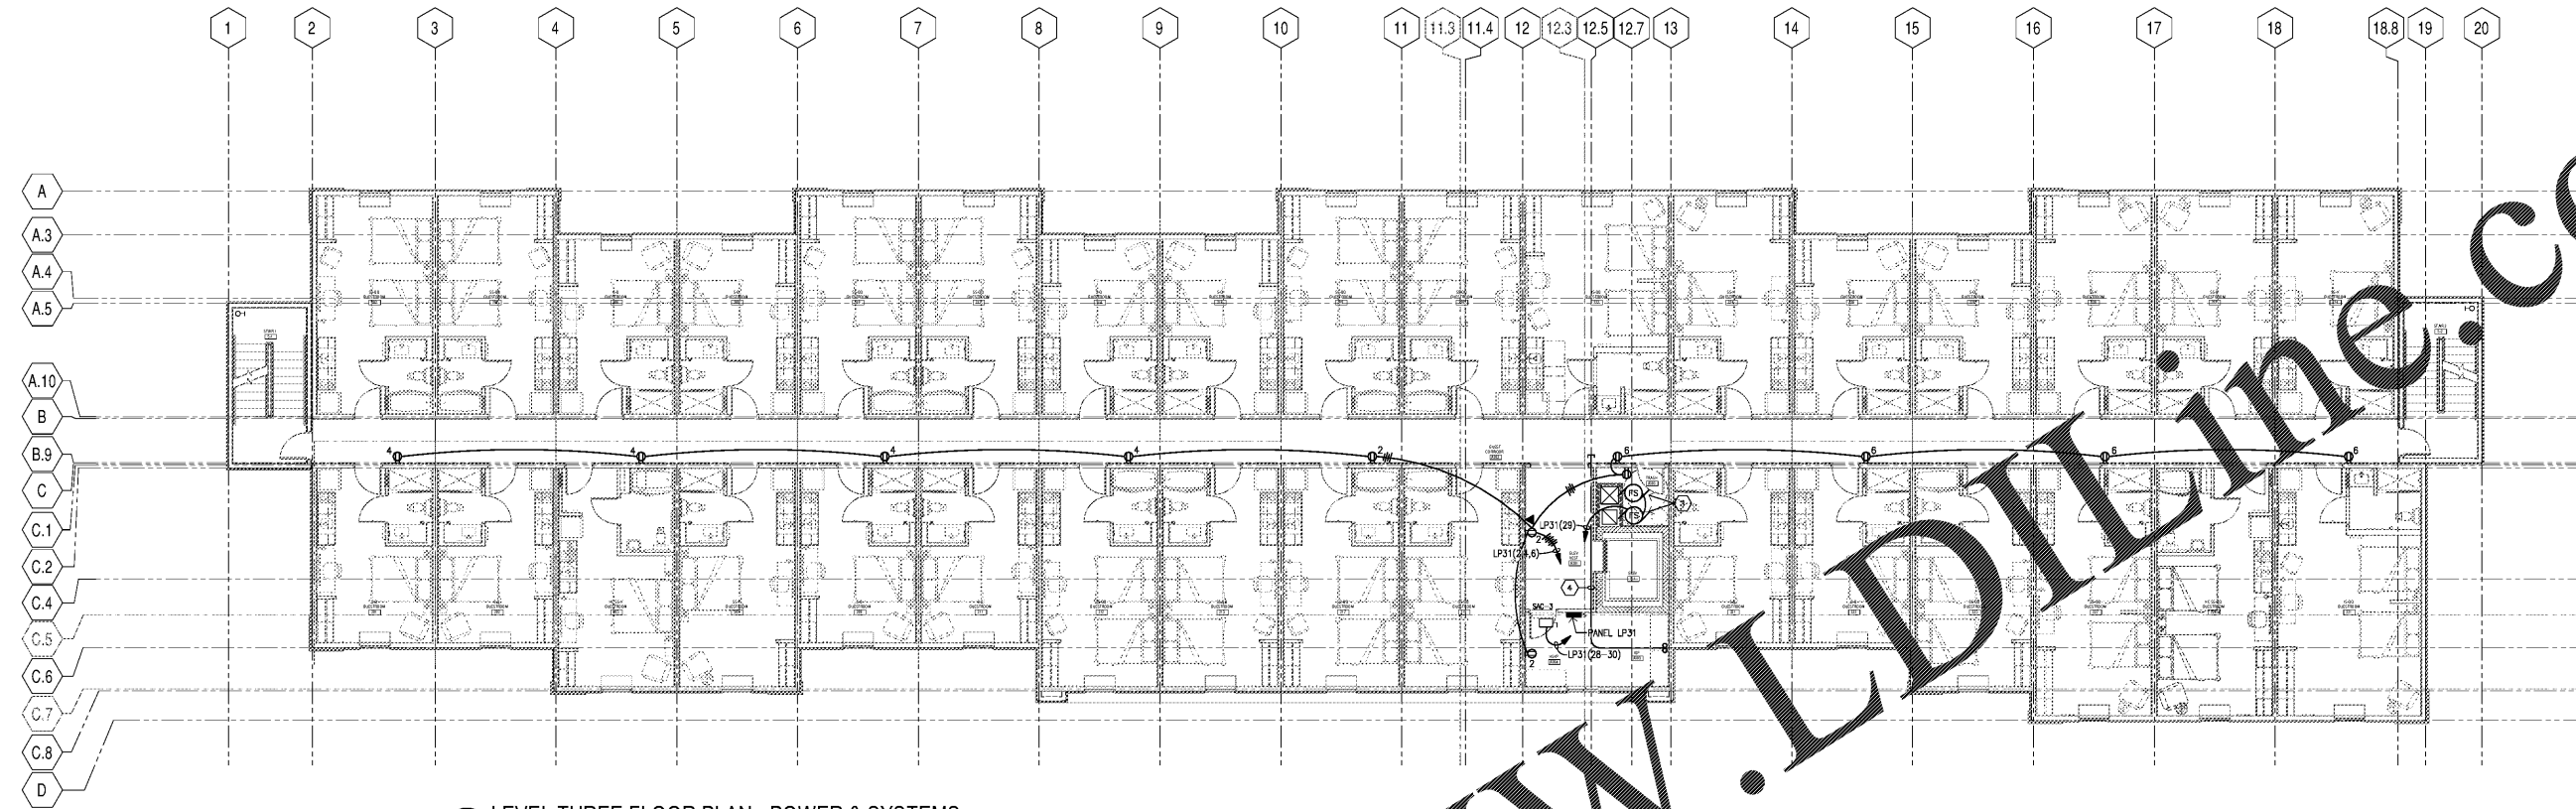

1 LEVEL THREE FLOOR PLAN - POWER & SYSTEMS
 E303 1/8" = 1'-0"

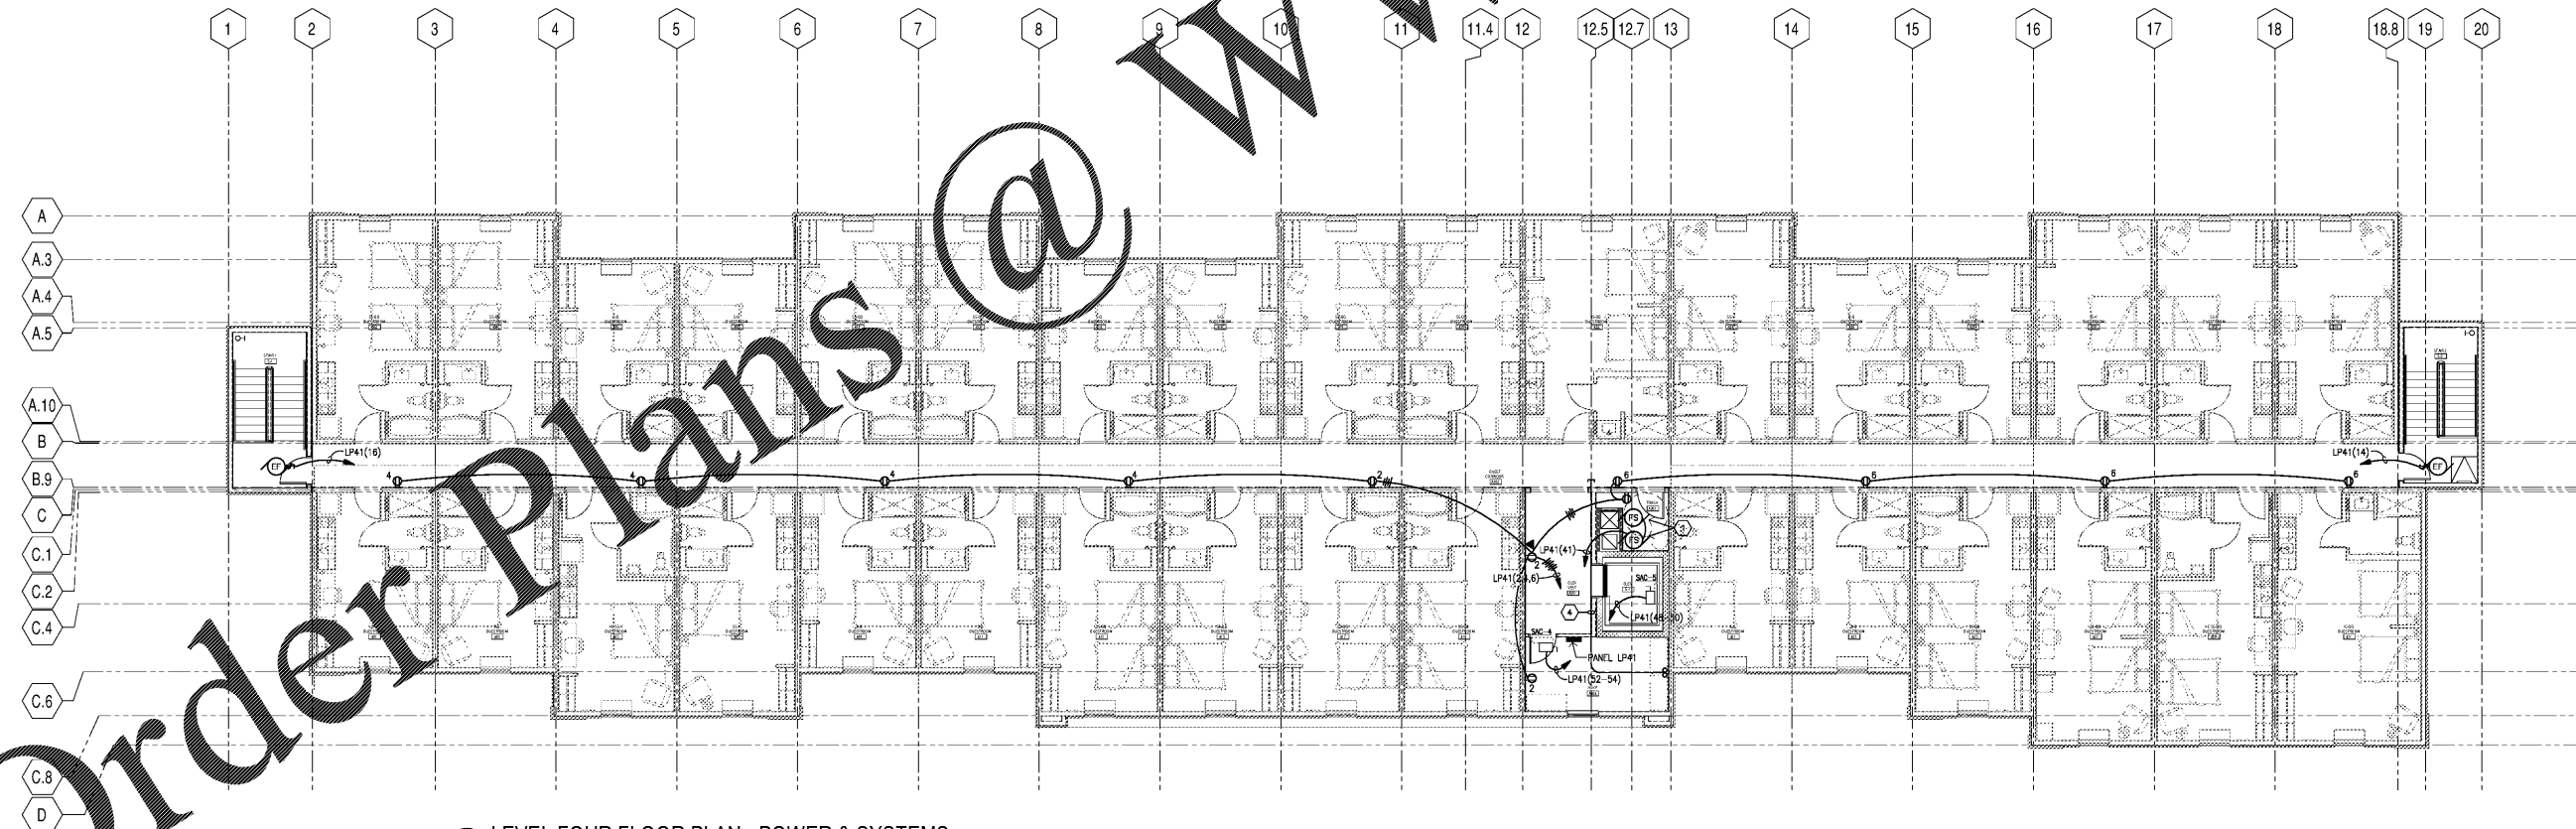

2 LEVEL FOUR FLOOR PLAN - POWER & SYSTEMS
 E303 1/8" = 1'-0"

GENERAL NOTES
 REFER TO DRAWING E302 FOR
 GENERAL AND SHEET NOTES.