




**RULE JOY TRAMMELL RUBIO**  
 ARCHITECTURE INTERIOR DESIGN  
 300 Galleria Parkway Suite 740 Atlanta, Georgia 30329  
 770-661-1492 (phone) 770-661-1493 (fax)  
 www.rjtdesign.com


DATE	ISSUE/REVISION
11/01/18	ISSUED FOR PERMIT

**JB Electrical Design, P.C.**  
 Electrical Consulting Engineers  
 9348 Birchmont N.  
 Minneapolis, MN 55445  
 762.486.0965  
 jrb@jb-electrical.com  
 MEI Lic. No. 2013.662  
 © 2018 by JB Electrical Design, P.C.

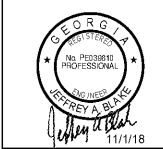


**EXTENDED STAY AMERICA**  
 POOLIER, GA

COMMISSION NO: 18-120-00  
 DRAWING NO:  
**E503**

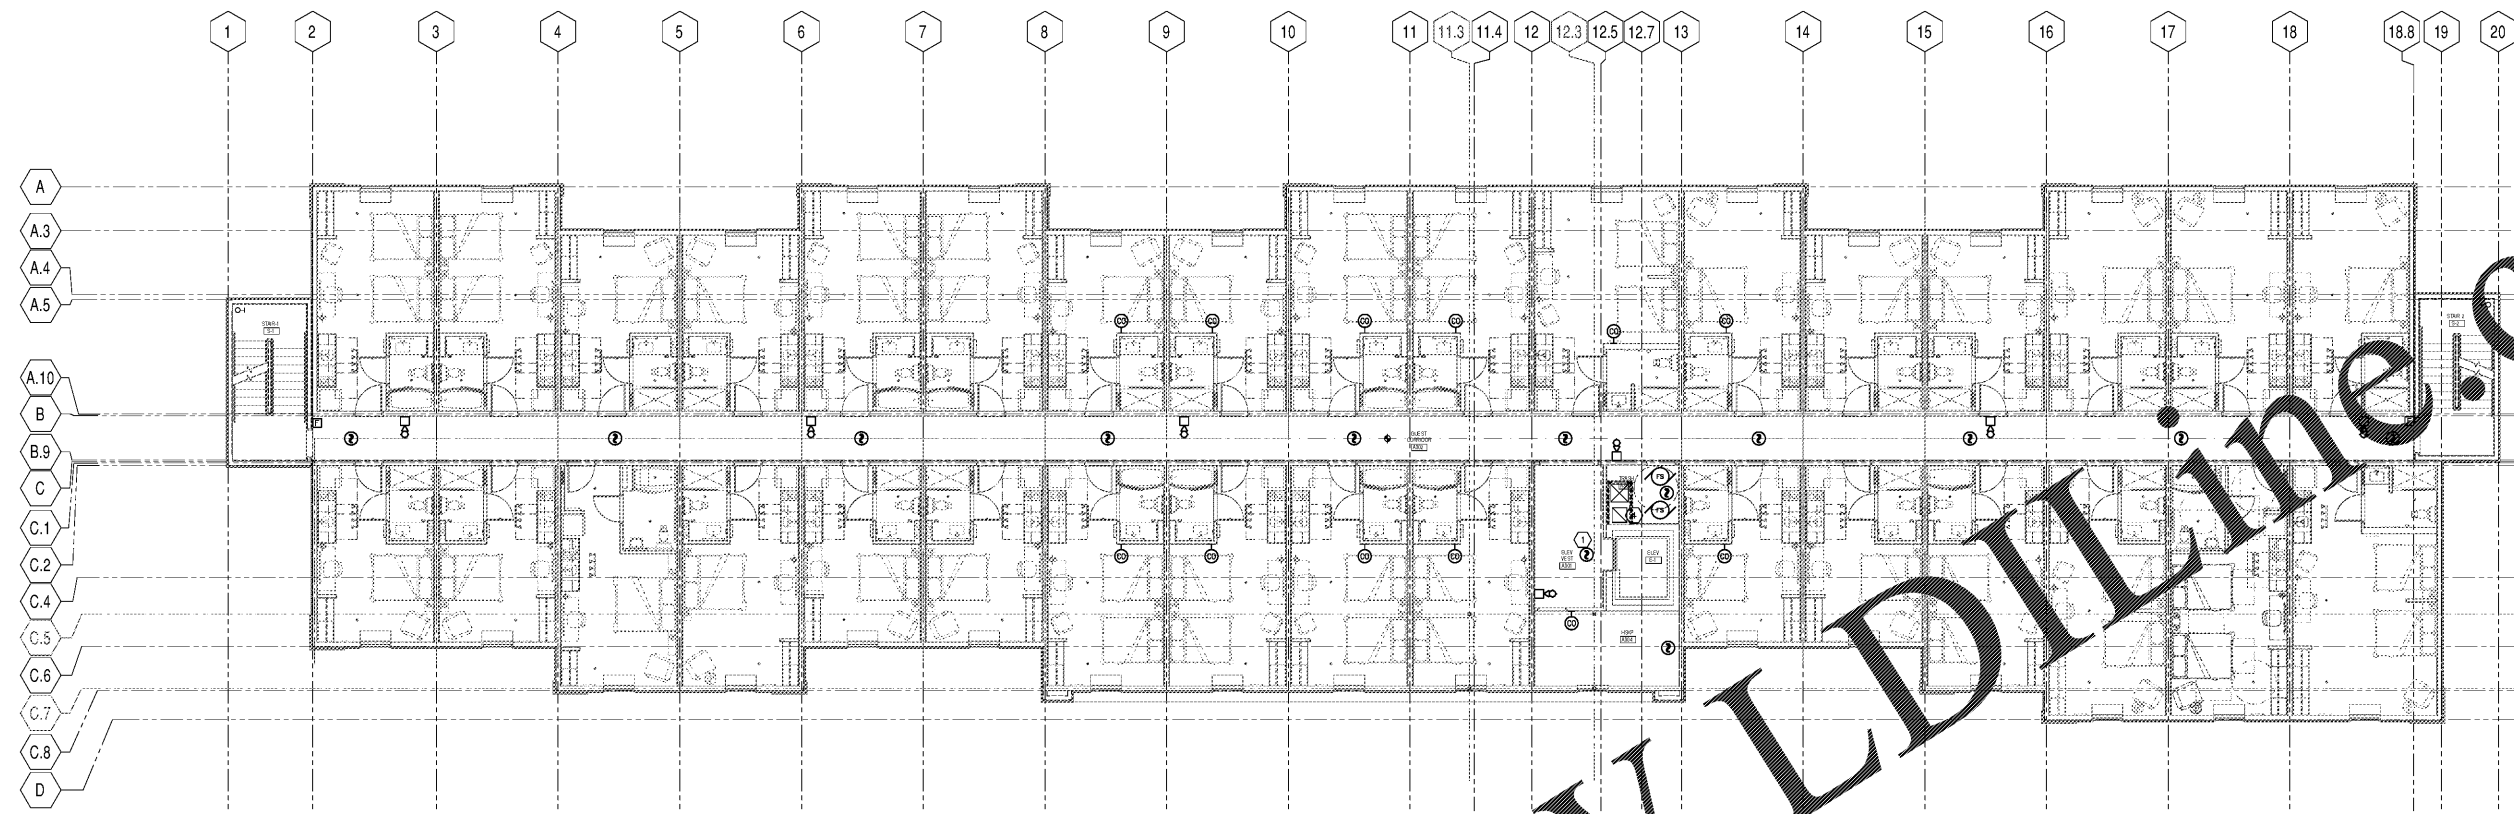

**1 LEVEL THREE FLOOR PLAN - FIRE ALARM**  
 1/8" = 1'-0"

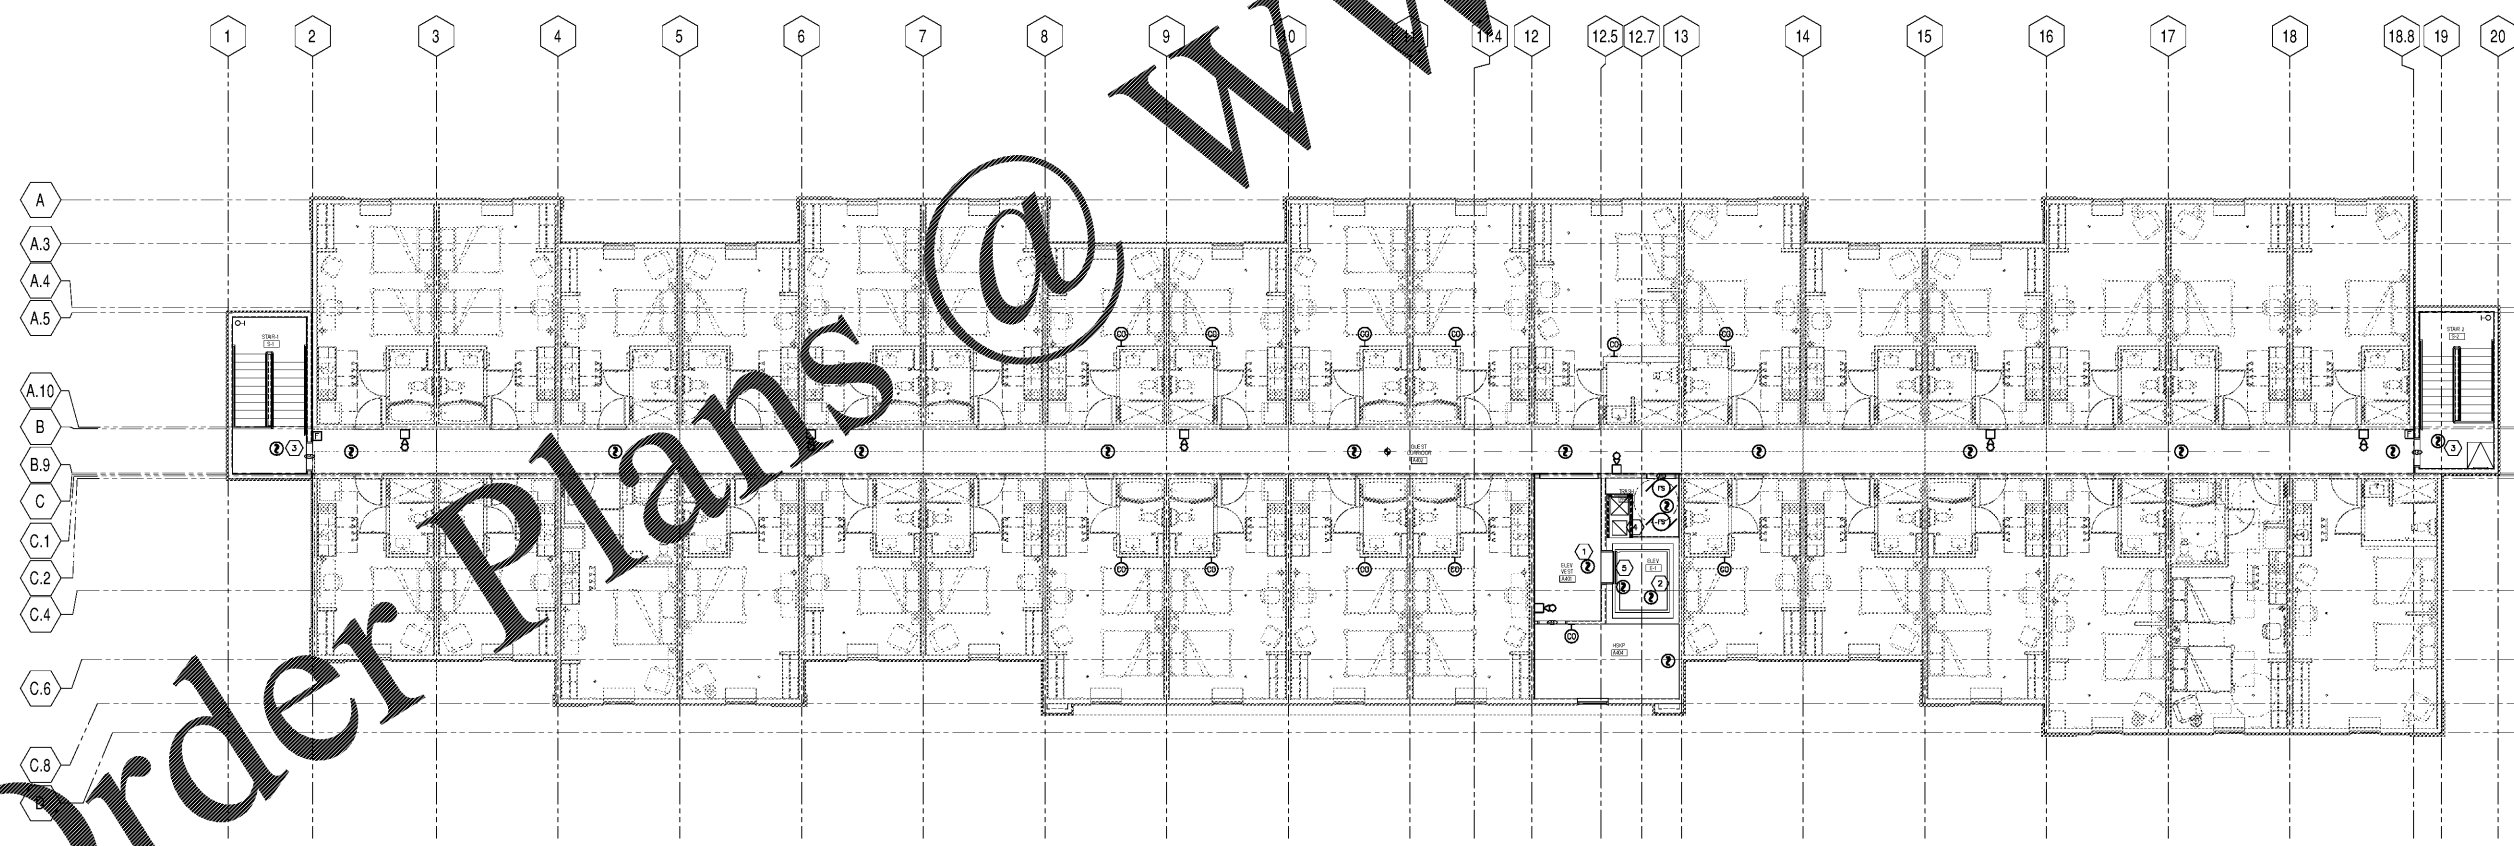

**2 LEVEL FOUR FLOOR PLAN - FIRE ALARM**  
 1/8" = 1'-0"

**GENERAL NOTES**  
 REFER TO DRAWING E502 FOR  
 GENERAL AND SHEET NOTES.

Order Plans @ [www.LDOnline.com](http://www.LDOnline.com)