



**RULE JOY TRAMMELL RUBIO**  
 ARCHITECTURE INTERIORDESIGN  
 300 Galleria Parkway Suite 740 Atlanta, Georgia 30338  
 770-661-1492 (phone) 770-661-1493 (fax)  
 www.rjtrdesign.com


THIS DRAWING IS THE PROPERTY OF RULE JOY TRAMMELL RUBIO ARCHITECTURE INTERIORDESIGN LLC AND MAY NOT BE REPRODUCED WITHOUT WRITTEN CONSENT.

PRINTED	
DATE	ISSUE/REVISION
11/01/18	ISSUED FOR PERMIT



**EXTENDED STAY AMERICA**  
 POOLER, GEORGIA

COMMISSION NO: 18-120.00  
 DRAWING NO:  
**P1.4**

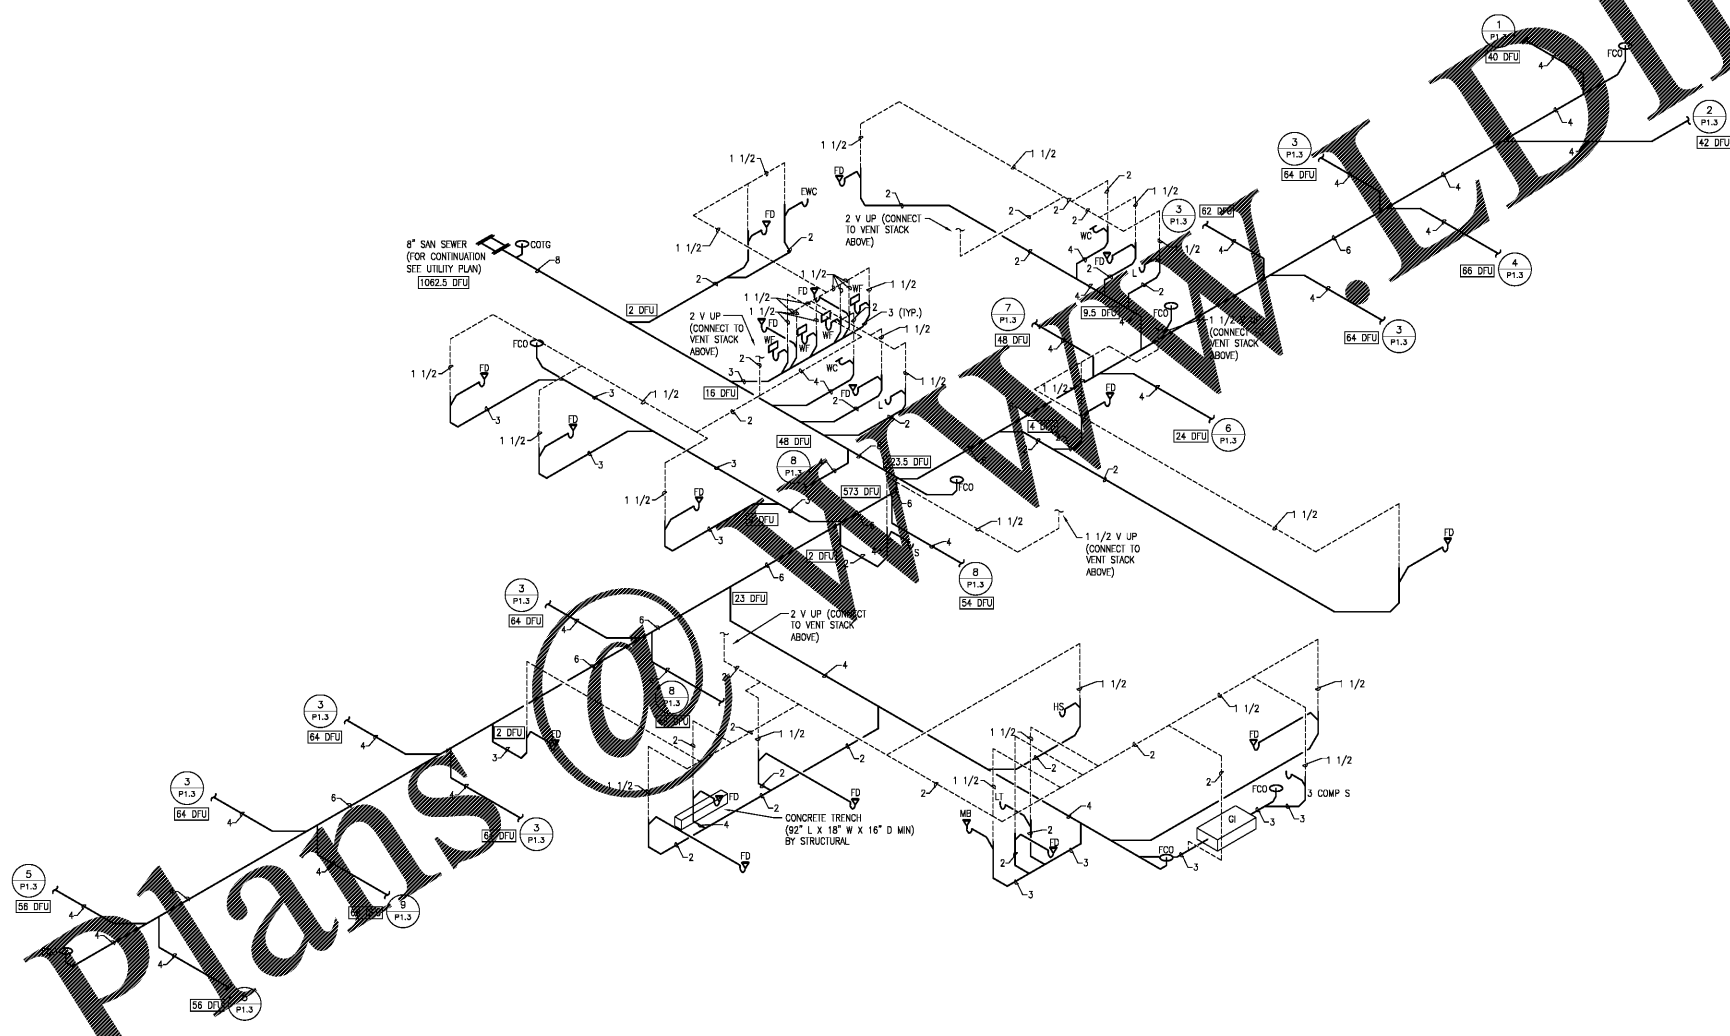

- PLUMBING INSTALLATION NOTES**
- 1 SLOPE ALL PIPING PER SPECIFICATION SECTION 2213.16
  - 2 ALL PLUMBING SYSTEMS DESIGN PER THE 2015 INTERNATIONAL PLUMBING CODE, VERIFY LOCAL CODE REQUIREMENTS.
  - 3 GENERAL FIXTURE CALLOUTS ARE SHOWN ON SANITARY PLANS. FIXTURE SPECIFIC CALLOUTS ARE SHOWN ON DOMESTIC WATER PLANS.

**1 OVERALL WASTE AND VENT DIAGRAM**  
 NO SCALE

Order Plans @ WWW.LDLine.com