




RULE JOY TRAMMELL RUBIO
 ARCHITECTURE INTERIOR DESIGN
 300 Galleria Parkway Suite 740 Atlanta, Georgia 30329
 770-661-1492 (phone) 770-661-1493 (fax)
 www.rjtdesign.com

DATE	ISSUE/REVISION
11/01/18	ISSUED FOR PERMIT


JB Electrical Design, P.C.
 Electrical Consulting Engineers
 9330 Birchway N.
 Minneapolis, MN 55445
 763-486-0965
 je@jbelectricaldesign.com
 MEI Lic. No. 2013-065
 ©2018 by JB Electrical Design, PC

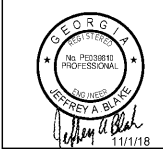

LEVEL TWO FLOOR PLAN - LOW VOLTAGE SYSTEMS
EXTENDED STAY AMERICA
 POOLER, GA


COMMISSION NO: 18-120-00
 DRAWING NO:

T102

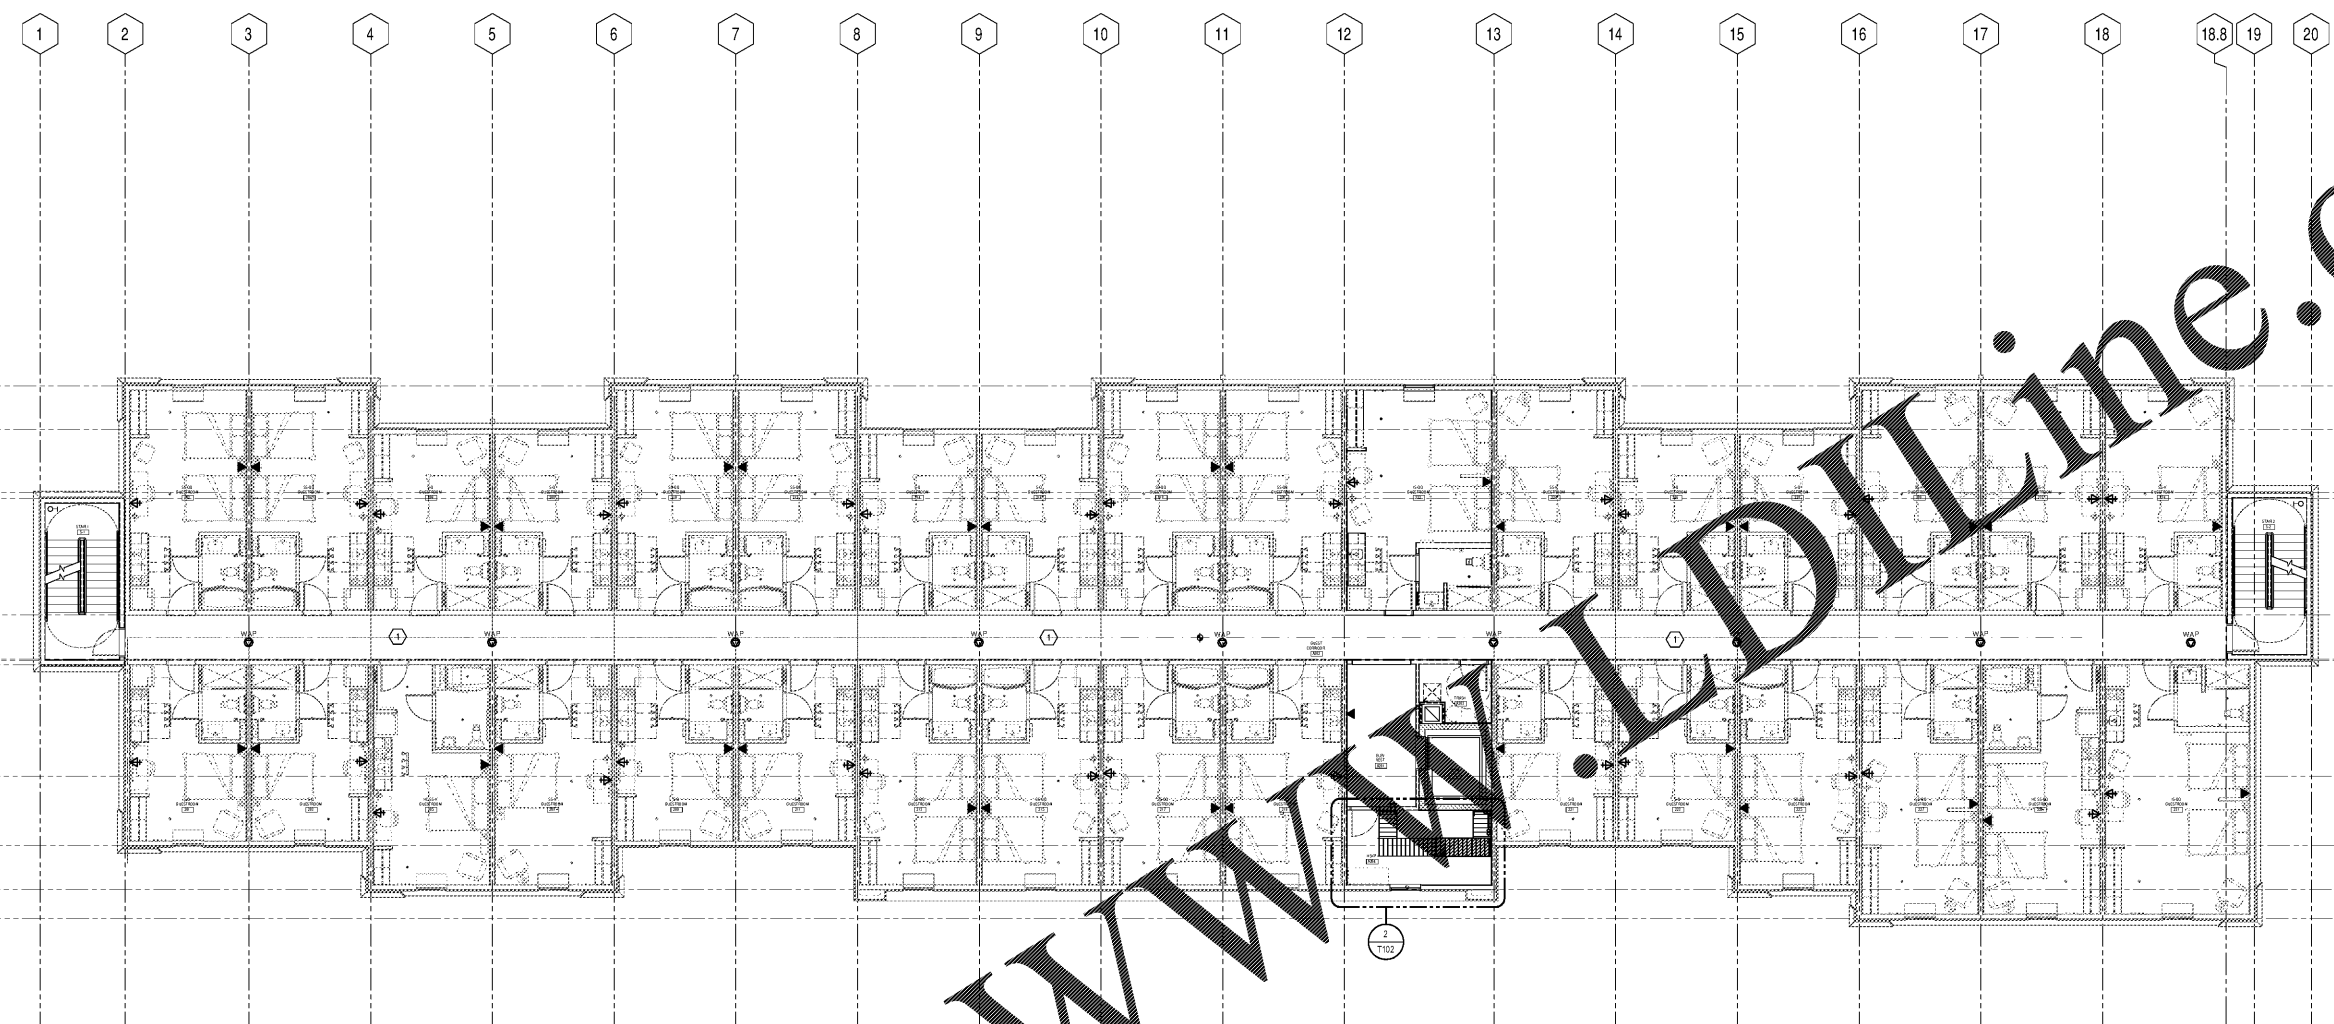

1 LEVEL TWO FLOOR PLAN - LOW VOLTAGE SYSTEMS
 T102 1/8" = 1'-0"

2 LARGE SCALE MDF ROOM - LOW VOLTAGE SYSTEMS
 T102 1/4" = 1'-0"

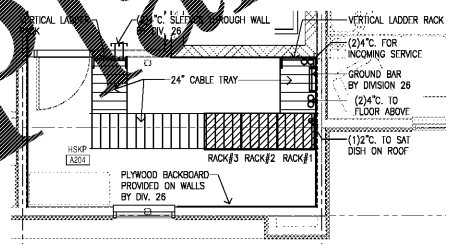

- GENERAL NOTES**
- REFER TO ARCHITECTURAL DRAWINGS FOR EXACT DEVICE LOCATIONS.
 - COORDINATE ROUGH-IN WITH DIVISION 26 CONTRACTOR.
 - EXACT LOCATIONS OF WIRELESS ACCESS POINTS SHALL BE DETERMINED DURING CONSTRUCTION AT CEILING LOCATIONS. PROVIDE A 10'-FT CABLE SERVICE LOOP AT EACH LOCATION TO ALLOW FOR ADJUSTMENTS.

- SHEET NOTES**
- ROUTE CABLES FROM GUEST ROOM DEVICES TO CORRIDOR. USE J-HOOKS TO SUPPORT CABLES ROUTED ABOVE ACCESSIBLE CEILINGS TO MDF.
 - ROUTE CABLES FROM GUEST ROOM DEVICES TO CORRIDOR. USE J-HOOKS TO SUPPORT CABLES ROUTED ABOVE ACCESSIBLE CEILINGS. CABLING FOR LEVELS 3 AND 4 SHALL BE ROUTED TO IDF.
 - APPROXIMATE LOCATION OF CONDUIT FROM MDF TO ROOF FOR SATELLITE CABLING. SEE ROOF PLAN ON E304. DIVISION 27 CONTRACTOR SHALL COORDINATE FINAL LOCATION WITH ELECTRICAL CONTRACTOR PRIOR TO INSTALLATION.

Order Plans @ WWW.DIline.com