


1 LEVEL THREE FLOOR PLAN - LOW VOLTAGE SYSTEMS
1/8" = 1'-0"

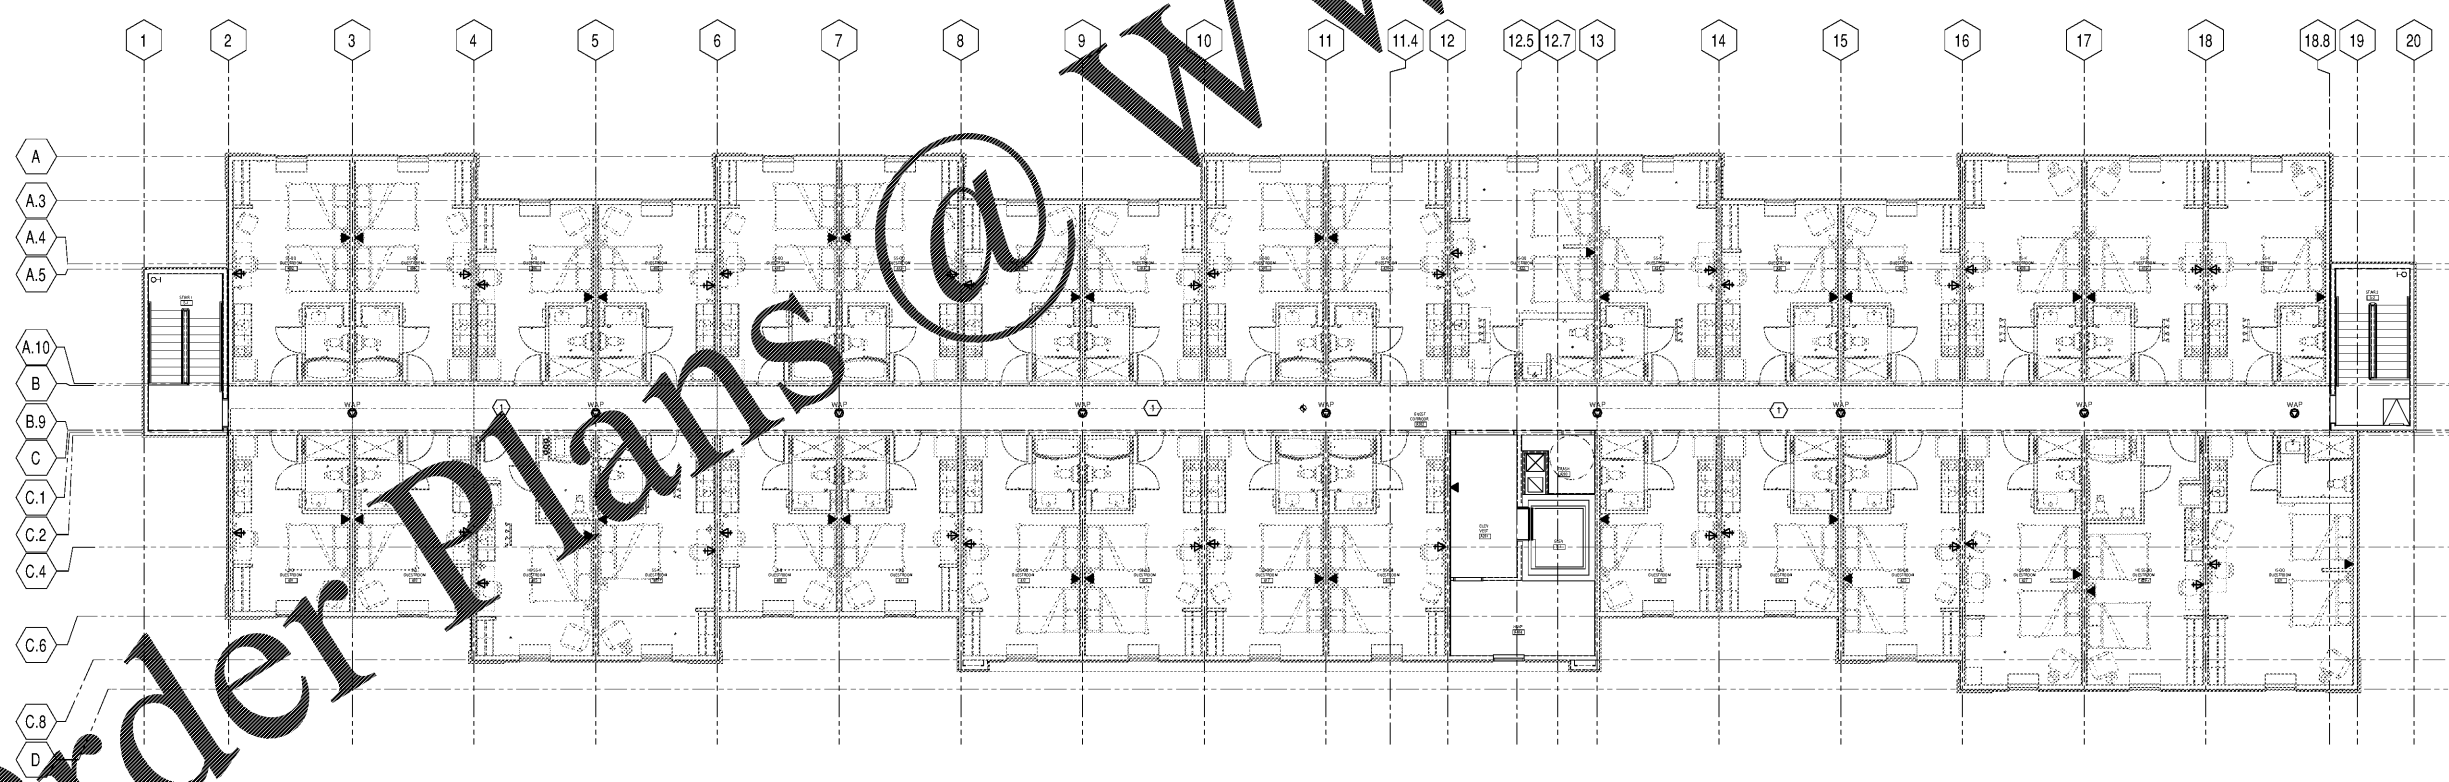


2 LEVEL FOUR FLOOR PLAN - LOW VOLTAGE SYSTEMS
1/8" = 1'-0"

GENERAL NOTES
REFER TO DRAWING T102 FOR
GENERAL AND SHEET NOTES.

RTI
RULE JOY TRAMMELL RUBIO
 ARCHITECTURE INTERIOR DESIGN
 300 Galleria Parkway Suite 740 Atlanta, Georgia 30329
 770-661-1492 (phone) 770-661-1493 (fax)
 www.rjtdesign.com

PRINTED	
DATE	ISSUE/REVISION
11/01/18	ISSUED FOR PERMIT

JB Electrical Design, P.C.
 Electrical Consulting Engineers
 9338 Birchmont Rd.
 Minneapolis, MN 55445
 762-488-0965
 jrb@jb-electrical-design.com
 ME License No. 2013-063
 ©2018 by JB Electrical Design, P.C.

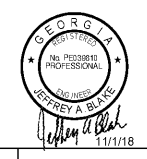

LEVEL THREE AND FOUR FLOOR PLANS - LOW VOLTAGE SYSTEMS
EXTENDED STAY AMERICA
 POOLER, GA

COMMISSION NO. 18-120-00
 DRAWING NO:
T103

Order Plans @ www.worldwide.com