




American Institute of Architects

310 MILLS AVE., GREENVILLE, SC 29605  
864.242.9881  
plans@narramore.net

© 2018 NARRAMORE ASSOCIATES, INC.  
COPYRIGHT PROTECTED BY FEDERAL LAW

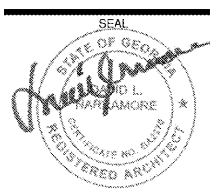

10/26/2018

- NOTE:
- COORDINATE WITH STRUCTURAL, PLUMBING, MECHANICAL AND ELECTRICAL FOR ALL ITEMS PROVIDED BY THOSE DISCIPLINES. CONTRACTOR SHALL BE RESPONSIBLE FOR LAYING OUT ALL CEILING MOUNTED ELEMENTS WITH ALL OTHER CEILING MOUNTED EQUIPMENT AND STRUCTURE AND CORRECTING ANY INTERFERENCE PRIOR TO INSTALLATION.
  - PAINT ALL CEILING MOUNTED ITEMS ON SALES FLOOR INCLUDING BUT NOT LIMITED TO HVAC DIFFUSERS AND RETURNS, THREADED ROD, CONDUIT AND SPRINKLER PIPE.
  - PREPARE AND PAINT 6-WAY DIFFUSERS FOR SAFETY; INCLUDING DRUM DIFFUSERS. CONTRACTOR SHALL BE RESPONSIBLE TO ENSURE FULL COVERAGE. AFTER MECHANICAL CONTRACTOR POSITIONS DRUM DIFFUSERS, COULDRUM DIFFUSER PAINT.
  - ALL DIMENSIONS ARE TO FACE UNLESS OTHERWISE NOTED.
  - ALL DIMENSIONS TO LIGHT FIXTURE LOCATIONS ARE TO CENTERLINE OF FIXTURE.
  - TAULKING CEILING TO WALL INTERSECTIONS - SEE SPEC SECTION 079200.
  - VERIFY FINAL MERCHANDISING FIXTURE LAYOUT WITH ALDI REPRESENTATIVE PRIOR TO INSTALLATION OF LIGHT FIXTURE.
  - EXISTING ROOF DECK, JOISTS AND ALL CEILING RELATED ITEMS TO BE CLEANED AND PAINTED. REFER TO FINISH SCHEDULE FOR PAINT INFO.
  - ATTACH POWERPOLE TO ROOF STRUCTURE WITH UNISTRUT (TYP. AT CHECKLANES AND SPOT MERCHANDISERS) - PAINT UNISTRUT TO MATCH CEILING.
  - GC TO ENSURE ALL JOIST AND JOIST GIRDER TAGS ARE PROPERLY SECURED TO JOIST WEBBING AND CONCEALED FROM VIEW PRIOR TO PAINTING.
  - NORDECA LIGHTING SYSTEM SHALL BE OWNER FURNISHED AND CONTRACTOR INSTALLED. CONTRACTOR SHALL HAVE FIVE (5) DAYS FROM DATE OF DELIVERY ACCEPTANCE TO VERIFY SHIPMENT FOR ANY DAMAGES. CORRECT QUANTITY OF FIXTURES AND PLACE A CLAIM. AFTER FIVE (5) DAYS THE CONTRACTOR SHALL BE RESPONSIBLE FOR ANY DAMAGES AND ADDITIONAL FIXTURES REQUIRED.

LEGEND:

SPRINKLER HEAD	
EXIT SIGN	
EMERGENCY LIGHT	
2' X 4' RECESSED LIGHT FIXTURE	
1' X 4' RECESSED LIGHT FIXTURE	
WALL PACK OR SCONCE	
4' STRIP LIGHT FIXTURE	
6' STRIP LIGHT FIXTURE	
RETURN AIR GRILLE	
SUPPLY DIFFUSER	
SHADED FIXTURES ARE NIGHT LIGHTS - SEE LIGHTING PLAN	



1597 DRY POND RD.  
JEFFERSON, GA 30549  
706.387.7722  
FAX: 706.387.7701

ALDI FOOD STORE # 61

2589 Spring Road  
Smyrna, GA 30080


REVISIONS

PROJECT DATA  
V1.07 100x155 LW Expansion  
PROJECT NUMBER  
18412  
ISSUE DATE  
09-10-18

ALDI FOOD STORE #61  
Smyrna, GA

A-111

REFLECTED CEILING PLAN

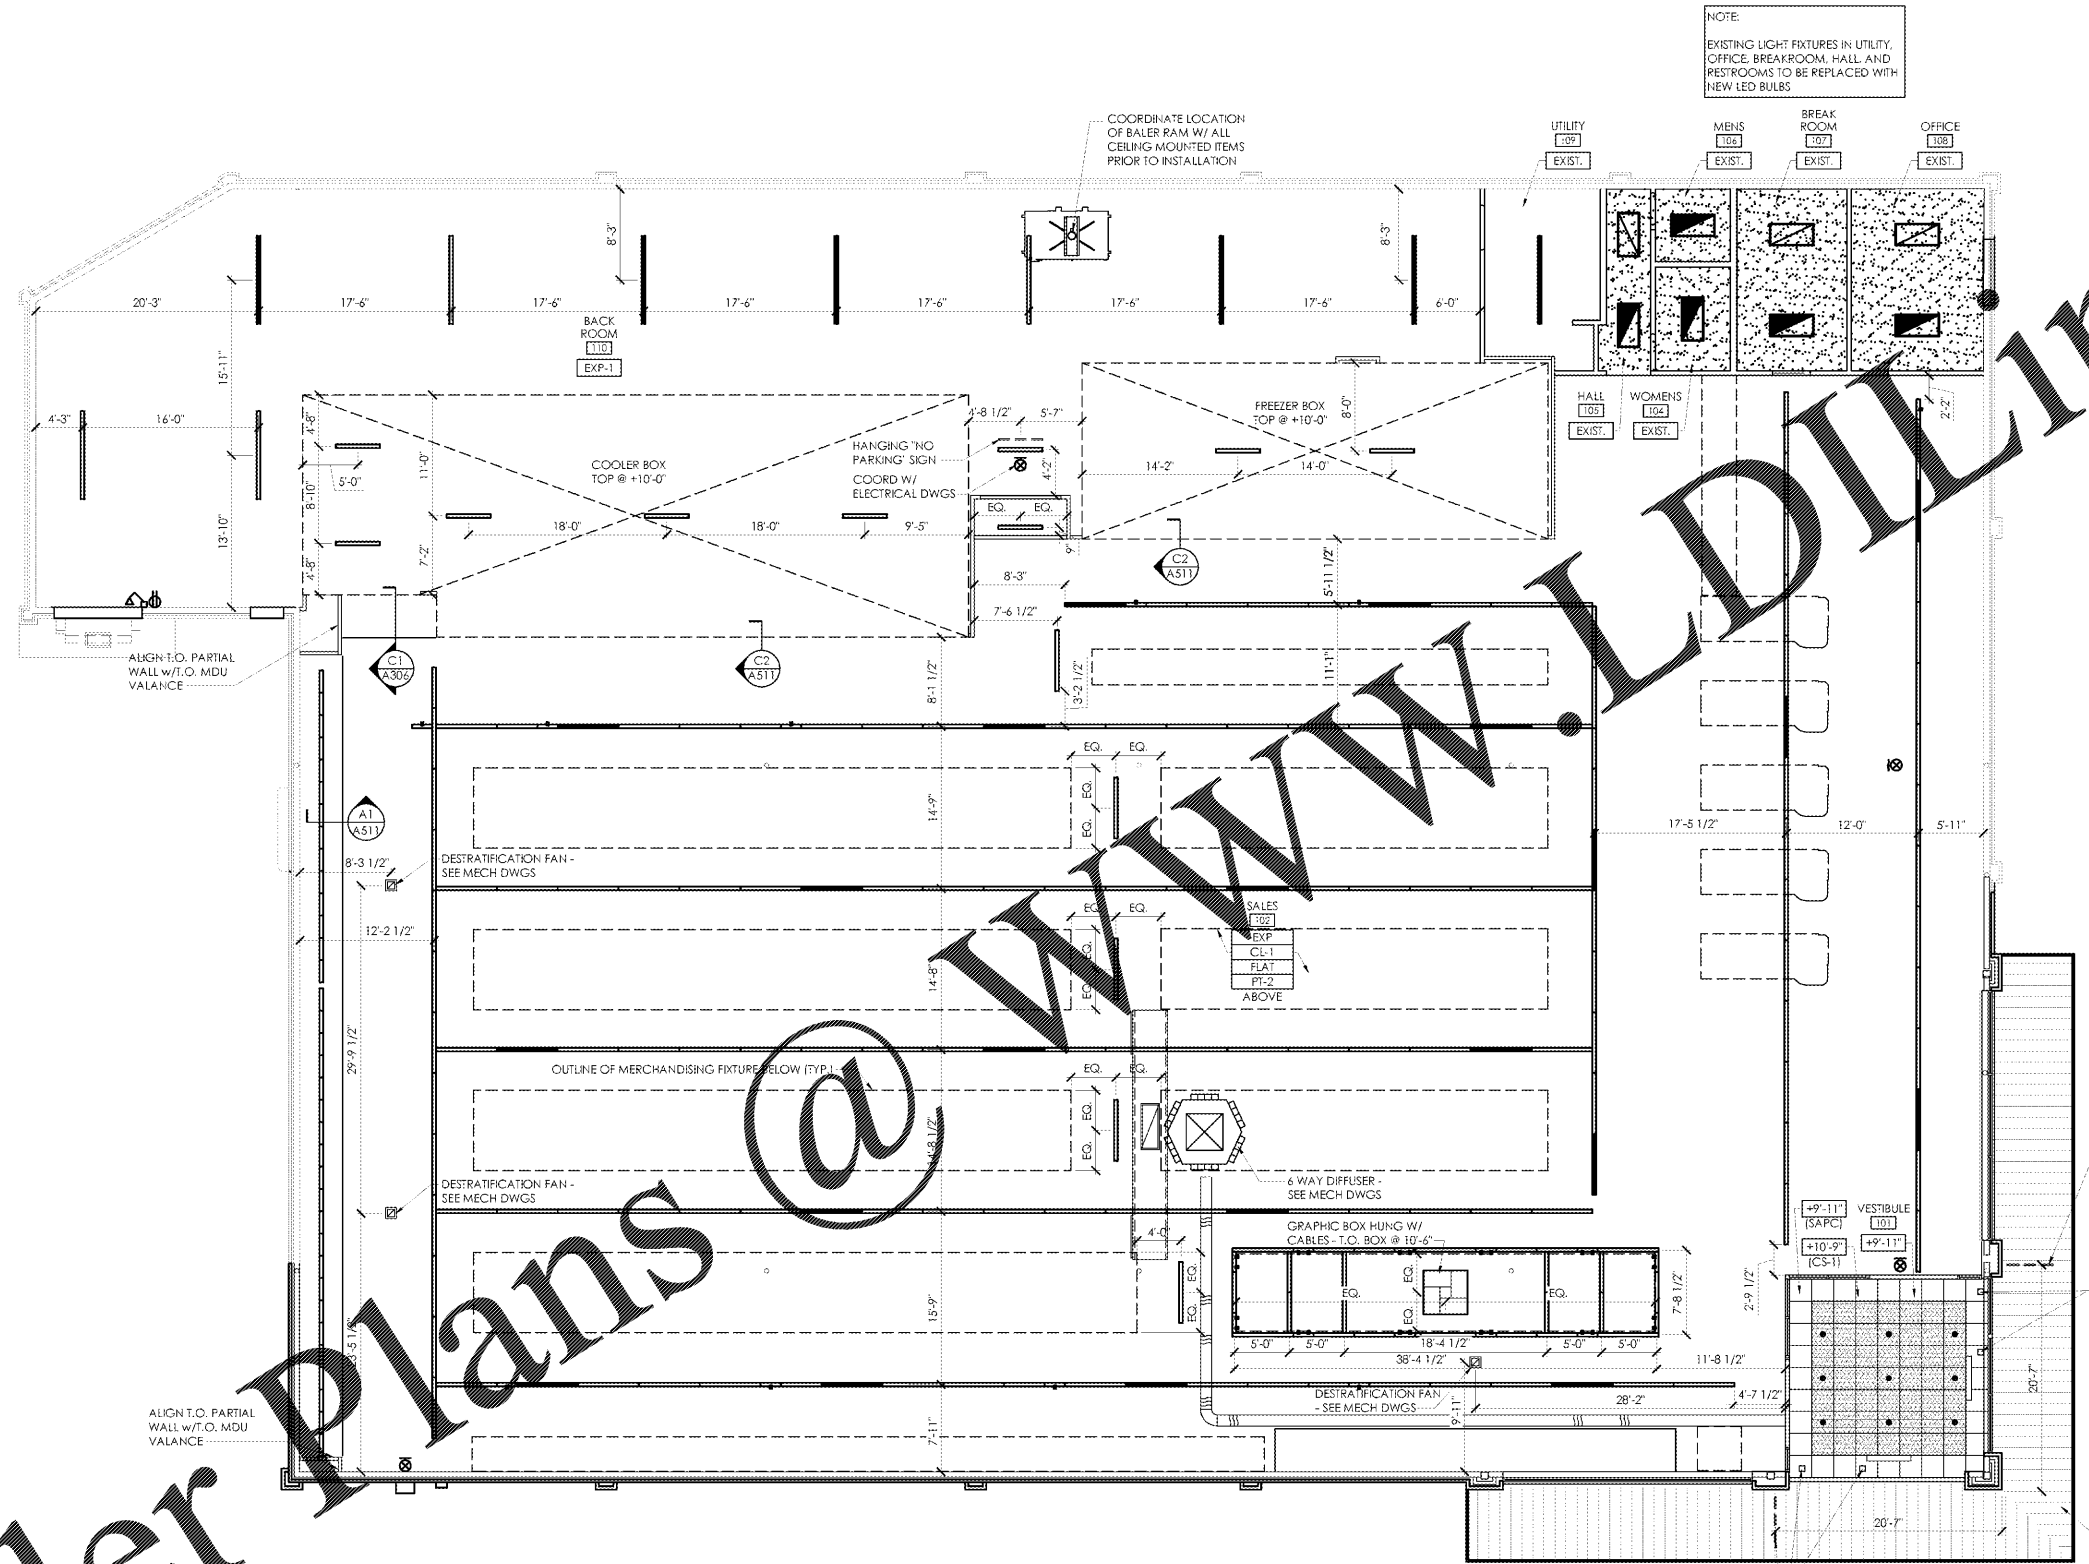

Order Plans

1 Reflected Ceiling Plan  
SCALE: 1/8" = 1'-0"

