




NOTE
 1. REFER TO DRAWING A-603 FOR ALL FINISH CALL-OUTS
 2. VERIFY THE LOCATION OF ELECTRICAL OUTLETS WITH ELECTRICAL PLANS BEFORE INSTALLATION. IF THERE IS A CONFLICT, NOTIFY OWNER PRIOR TO ANY WORK.

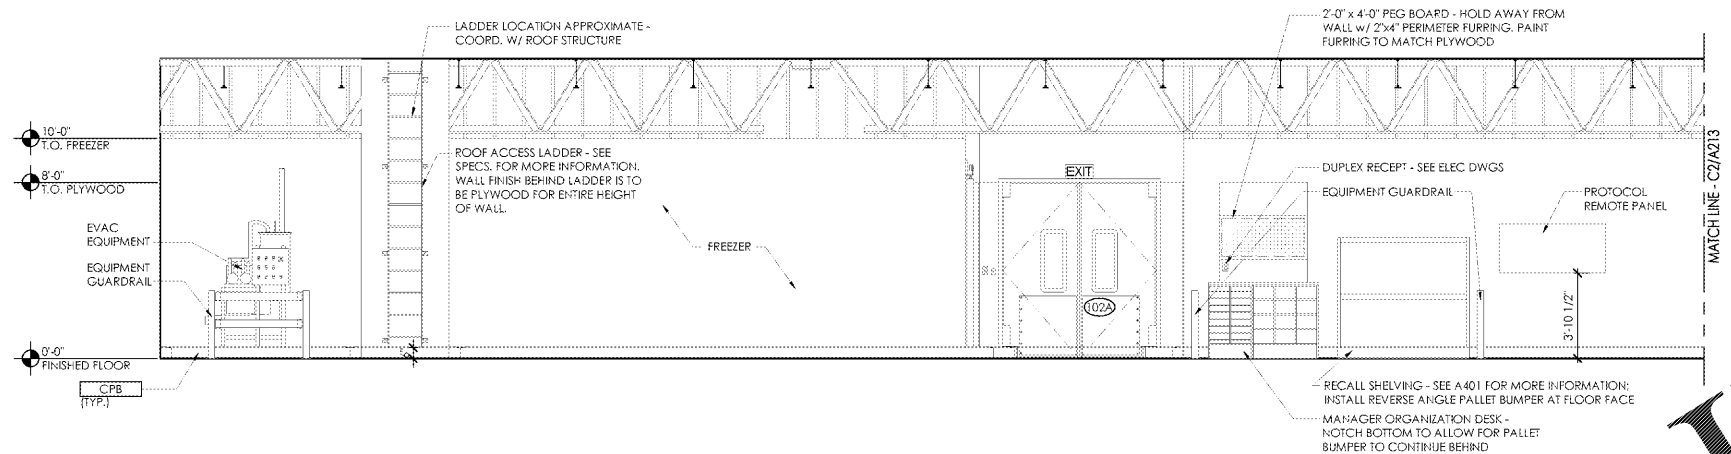

C3 Backroom Interior Elevation
 SCALE: 1/4" = 1'-0"

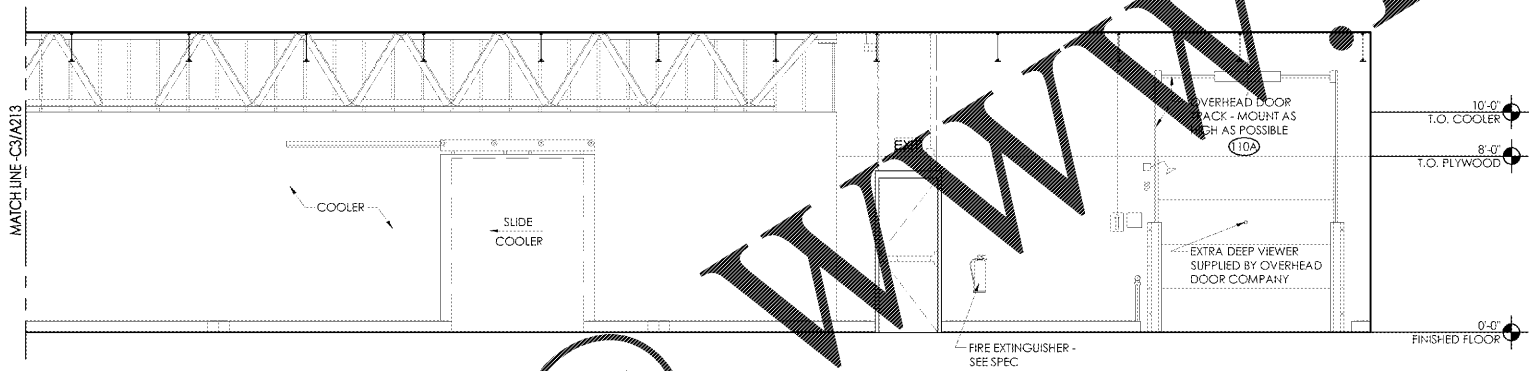

C2 Backroom Interior Elevation
 SCALE: 1/4" = 1'-0"

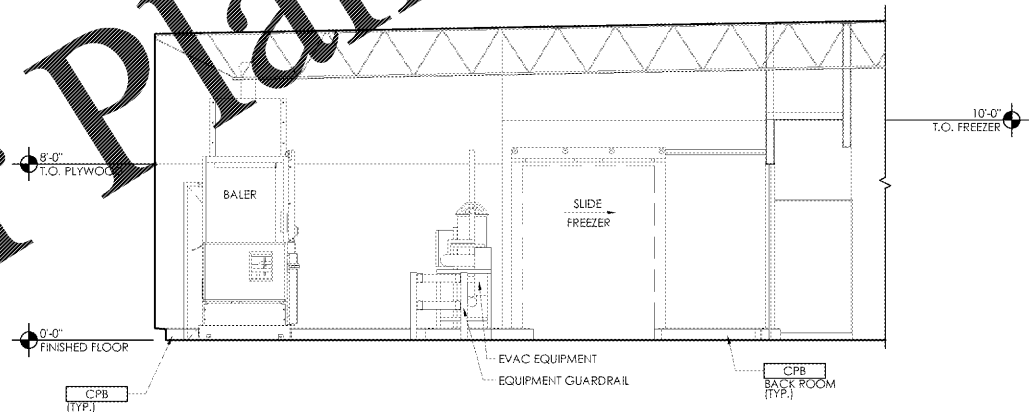

C1 Backroom Interior Elevation
 SCALE: 1/4" = 1'-0"



American Institute of Architects
 310 MILLS AVE. GREENVILLE, SC 29605
 864.242.9881
 plans@narramore.net
 © 2018 NARRAMORE ASSOCIATES, INC.
 COPYRIGHT PROTECTED BY FEDERAL LAW



1597 DRY POND RD.
 JEFFERSON, GA 30549
 706.387.7722
 FAX: 706.387.7701

ALDI FOOD STORE # 61
 2589 Spring Road
 Smyrna, GA 30080

REVISIONS

PROJECT DATA
 V1.07 100x155 LW Expansion
PROJECT NUMBER
 18412
ISSUE DATE
 10-25-18

ALDI FOOD STORE #61
 Smyrna, GA

A-213

INTERIOR ELEVATIONS

Order Plans @

WWW.LDILine.com