

SIGN-OFF PROCEDURE:


1. THE G.C. SHALL SEND THE CONDUIT LAYOUT DRAWINGS TO THE SYSTEM INSTALLER FOR THEIR REVIEW, COMMENT AND MARK UP.
2. THE SYSTEM INSTALLER SHALL MARK UP THE PLAN WITH ANY CHANGES OR ADDITIONAL DETAILS, THEN SIGN AND DATE WITH THEIR COMPANY NAME AND SEND IT BACK TO THE G.C.
3. UPON RECEIPT OF THE PLAN THE G.C. WILL THEN SIGN AND DATE WITH THEIR COMPANY NAME INDICATING THAT THEY ACCEPT THE MARKED UP PLAN WITH E.C..

	COMPANY	SIGNATURE	DATE
SYSTEM VENDOR			
GENERAL CONTRACTOR			
ELECTRICAL CONTRACTOR			



American Institute of Architects
 310 MILLS AVE. GREENVILLE, SC 29605
 864.242.9881
 plans@narramore.net
 © 2018 NARRAMORE ASSOCIATES, INC.
 COPYRIGHT PROTECTED BY FEDERAL LAW

FOR REFERENCE ONLY

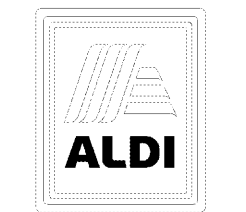

1587 DRY POND RD.
 JEFFERSON, GA 30549
 706.387.7722
 FAX: 706.387.7701

ALDI FOOD STORE # 61
 2589 Spring Road
 Smyrna, GA 30080

REVISIONS


PROJECT DATA
 V1.07 100x155 LW Expansion
PROJECT NUMBER
 18412
ISSUE DATE
 10-25-18

ALDI FOOD STORE #61
 Smyrna, GA

DEVITA
 ATLANTA • CHARLOTTE • GREENVILLE • RICHMOND
 877.4.DEVITA • corp@devitainc.com
 Devita & Associates, Inc. Project: 18102-35
 Drawn By: SMD Checked By: RAG

CLP-101

FIRE ALARM
 CONDUIT PLAN

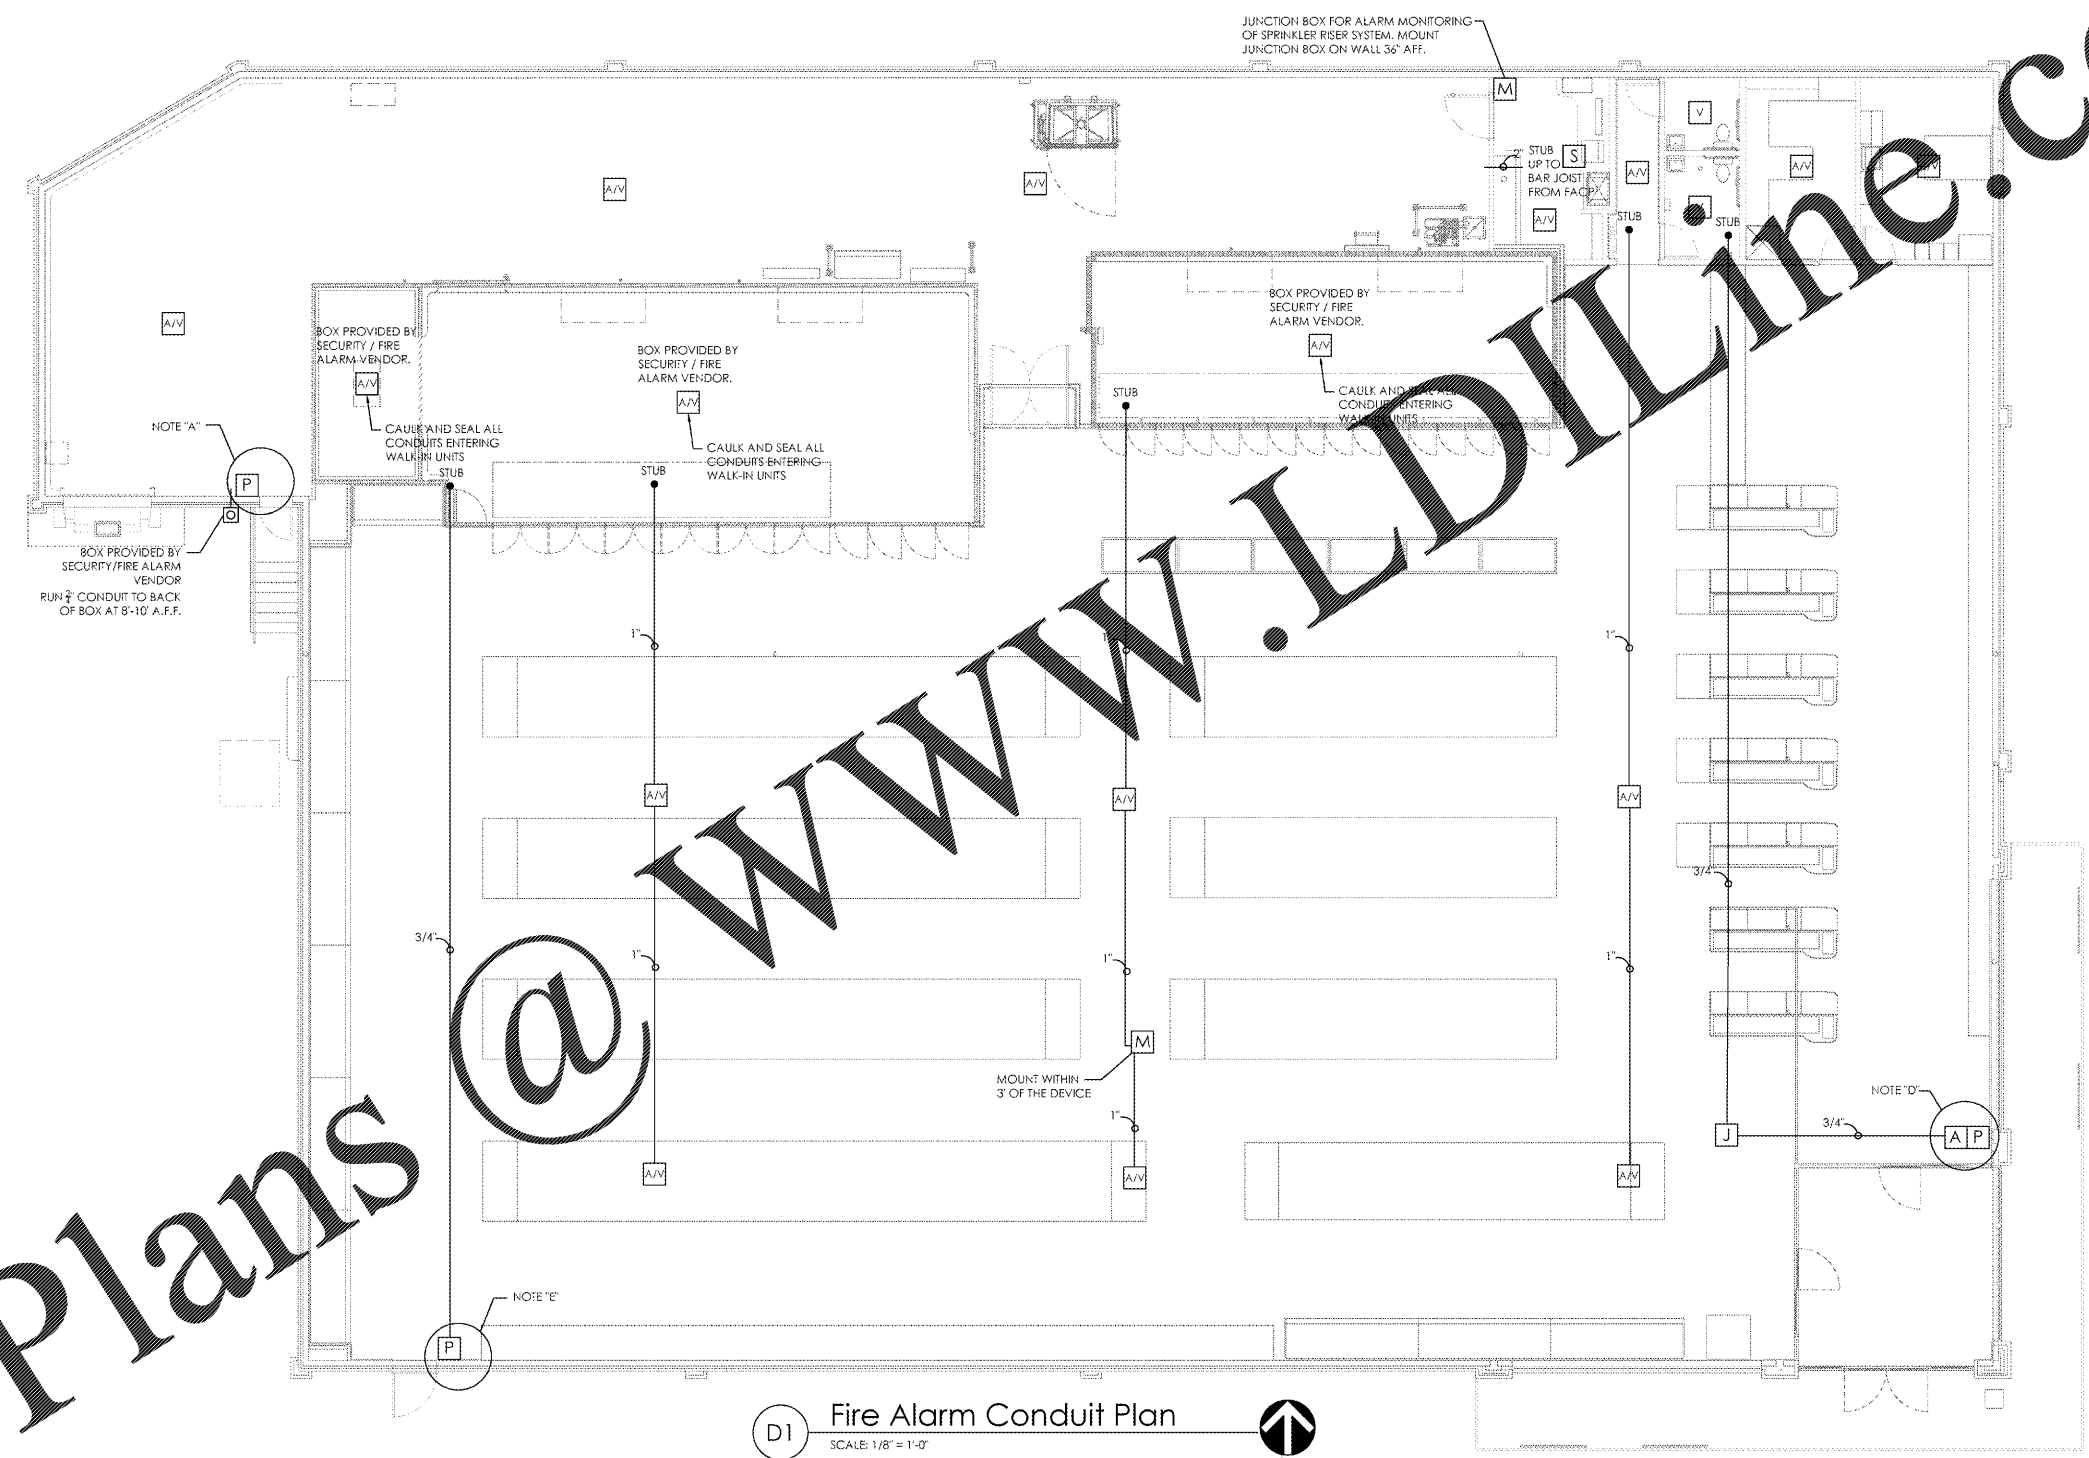


D1 Fire Alarm Conduit Plan
 SCALE: 1/8" = 1'-0"
 NORTH

- V** VISUAL 4" SQUARE BOX
MOUNT TO BOTTOM OF JOIST OR DROP TILE CEILING MOUNT.
- J** JUNCTION 4" SQUARE BOX
MOUNTING VARIES.
- A/V** AUDIBLE/VISUAL 4" SQUARE BOX
MOUNT TO BOTTOM OF JOIST OR DROP TILE CEILING MOUNT.
- S** SMOKE DETECTOR 4" SQUARE BOX
MOUNT TO BOTTOM OF JOIST OR DROP TILE CEILING MOUNT.
- P** PULL STATION SINGLE GANG BOX
MOUNT 48" A.F.F.
- A** ANNUNCIATOR 4" SQUARE BOX
MOUNT 62" A.F.F.
- M** MODULE 4" SQUARE BOX
MOUNTING DETAILS DIFFERENT PER DEVICE. LOCATED ON PLANS.

***NOTE**
 ALL BOXES NOT ATTACHED DIRECTLY TO JOISTS SHALL STUB UP TO BOTTOM OF STRUCTURE.

NOTE:

THIS CONDUIT DRAWING IS FOR REFERENCE ONLY. THE ELECTRICAL CONTRACTOR SHALL COORDINATE ALL FIRE ALARM SYSTEM (IF REQUIRED) AND SECURITY SYSTEM REQUIREMENTS WITH ALDI'S FIRE ALARM AND SECURITY SYSTEM VENDOR(S) AND SHALL PROVIDE ALL RACEWAYS, CONDUIT AND BOXES AS REQUIRED FOR INSTALLATION OF SYSTEM EQUIPMENT, DEVICES AND CABLING. ALL REQUIRED RACEWAYS, CONDUIT AND BOXES SHALL BE FURNISHED AND INSTALLED BY THE ELECTRICAL CONTRACTOR FOR USE BY THE FIRE ALARM AND SECURITY SYSTEM INSTALLER(S). REFER TO SIGN-OFF PROCEDURE LOCATED ON THIS SHEET.

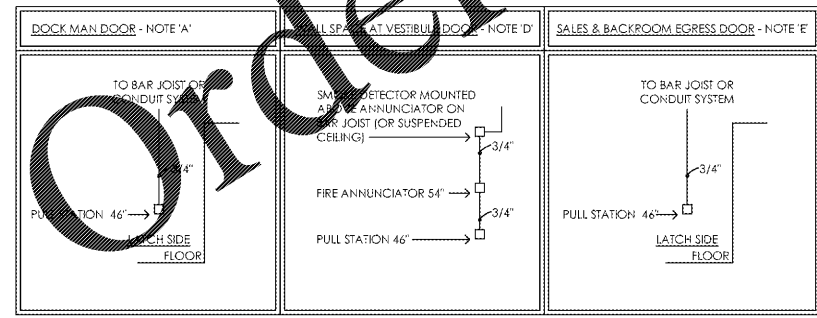

Order Plans