

Order Plans @ Walmart

OWNER FURNISHED SPRINKLERS AND ACCESSORIES table with columns: SYMBOL, SIZE, K-FACTOR, FINISH, MFR, MAKE, S.I.N., TEMP, STYLE, QTY, PARE QTY, RCHQ STYLE, RCHQ FINISH, RCHQ QTY

CONTRACTOR PROVIDED SPRINKLERS AND ACCESSORIES table with columns: SYMBOL, SIZE, MFR, MAKE, S.I.N., FINISH, STYLE, TEMP, K-FACTOR


SYMBOL LEGEND table with columns: SYMBOL, DESCRIPTION

SYSTEM IMPAIRMENT REQUIREMENTS table with 17 numbered items

SCOPE OF WORK table with 11 numbered items

GENERAL NOTES table with 6 numbered items

GENERAL NOTES table with 13 numbered items

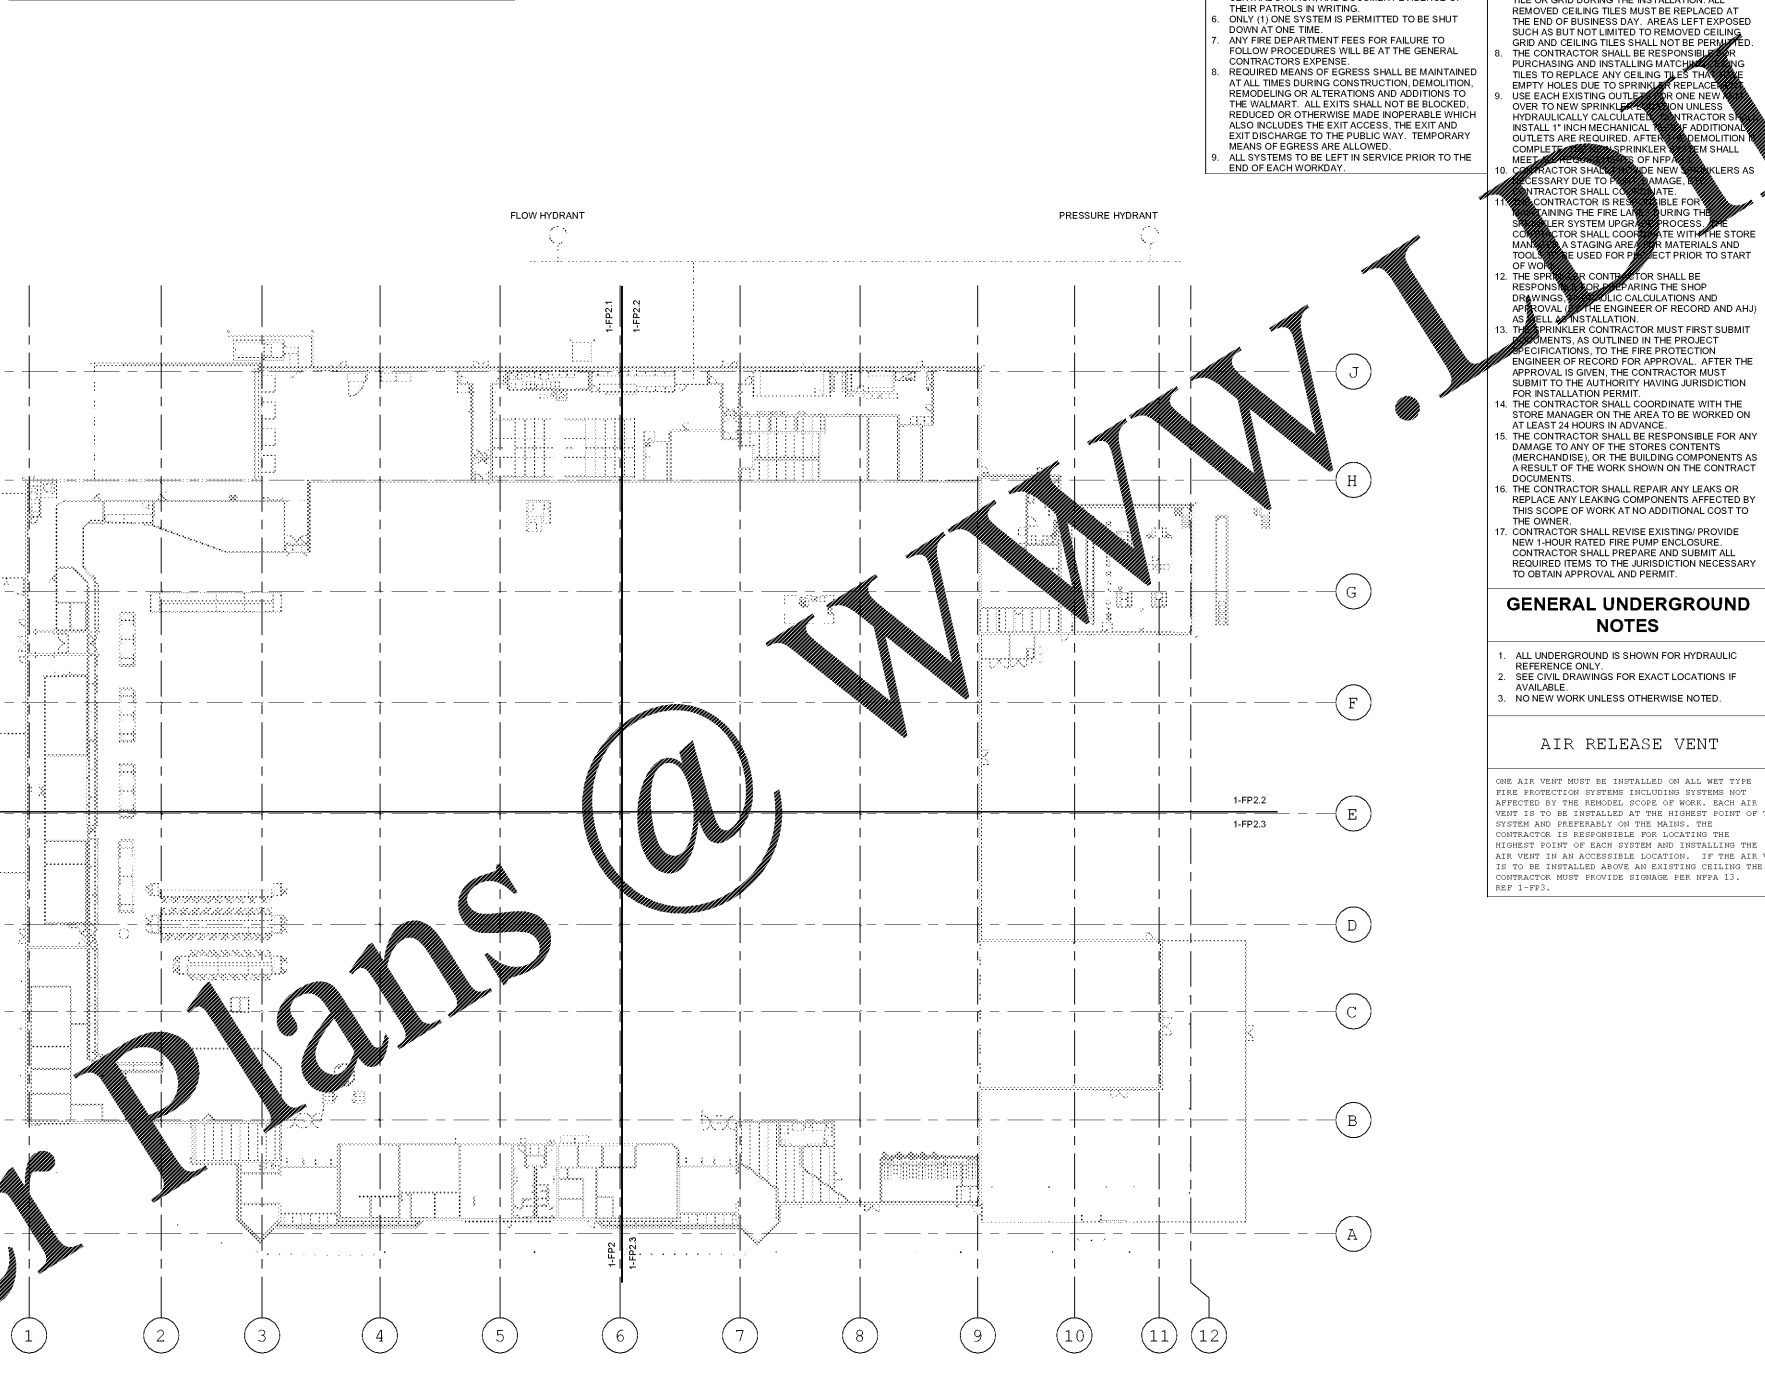

FIRE SPRINKLER PIPING AND DEMOLITION NOTES table with 11 numbered items

GENERAL UNDERGROUND NOTES table with 3 numbered items

AIR RELEASE VENT table with 1 item

PLACARD INFORMATION table with 1 item

GENERAL NOTES table with 13 numbered items

GENERAL NOTES table with 13 numbered items

GENERAL NOTES table with 13 numbered items

GENERAL NOTES table with 13 numbered items

GENERAL NOTES table with 13 numbered items

GENERAL NOTES table with 13 numbered items

GENERAL NOTES table with 13 numbered items

GENERAL NOTES table with 13 numbered items

 
GENERAL NOTES table with 13 numbered items

GENERAL NOTES table with 13 numbered items

GENERAL NOTES table with 13 numbered items

GENERAL NOTES table with 13 numbered items

1 FIRE PROTECTION PLAN 1" = 30'-0"



UNDERGROUND PIPING SHOWN FOR HYDRAULIC CALCULATION PURPOSES ONLY.

EXISTING CONDITIONS WERE TAKEN FROM ORIGINAL DRAWINGS AND MAY NOT REFLECT EXACT AS-BUILT CONDITIONS...

EACH SUBCONTRACTOR IS RESPONSIBLE FOR HAVING A THOROUGH KNOWLEDGE OF ALL DRAWINGS AND SPECIFICATIONS...

Architect & Peterson logo and contact information.

HENDERSON ENGINEERS logo and contact information.

Walmart logo and JESUP, GA STORE NO. 1895 information.

ISSUE BLOCK table with columns: NO., DESCRIPTION, DATE

CHECKED BY, DRAWN BY, PHOTO, PHOTO CYCLE, DOCUMENT DATE information.

SHEET INDEX table with columns: SYMBOL, DESCRIPTION

CONTACT INFORMATION table with 1 item

APPLICABLE CODES table with 2 items

WATER SUPPLY INFORMATION table with 1 item

NOT FOR CONSTRUCTION

OVERALL FIRE SPRINKLER PLAN

SHEET: FP1