

KEYNOTES

- 13.901 COORDINATE SPRINKLER PROTECTION PER REMOVAL, RELOCATION AND/OR ADDITION OF WALLS AND/OR CEILINGS. WHERE NECESSARY, REMOVE EXISTING SPRINKLER(S) AND ASSOCIATED PIPING, CAPPLUGS/OUTLETS NOT INTENDED FOR REUSE. WHERE NEW SPRINKLER(S) ARE REQUIRED WITHIN THE SAME COMPARTMENT AS EXISTING TO REMAIN SPRINKLER. NEW SPRINKLERS SHALL MATCH EXISTING SPRINKLER TYPE, K-FACTOR, TEMPERATURE RATING AND FINISH. WHERE APPLICABLE, ALIGN NEW SPRINKLER WITH EXISTING TO REMAIN SPRINKLERS, AND COORDINATE WITH NEW AND EXISTING EQUIPMENT AND WALLS TO MEET NFPA 13 SPACING REQUIREMENTS. NOT MORE THAN SPRINKLER SHALL BE SUPPLIED TO TYPE OR CONNECTION.
- 13.951 PROVIDE NEW MAIN AS SHOWN. LOCATE ABOVE THE BOTTOM CHORD OF THE JOIST. FIELD VERTICALLY THROUGH EXISTING SUBJOINTS. INSTALL NEW AND EXISTING EQUIPMENT AND
- 13.976 REPLACE EXISTING SPRINKLER(S) WITH 11.2K SPRINKLERS. REFER TO SPRINKLER LEGEND FOR SPECIFIC NEW SPRINKLERS TO BE INSTALLED.
- 13.977 REPLACE EXISTING LIGHT SPRINKLER WITH NEW TYPE SPRINKLERS. REFER TO FP1 SPRINKLER LEGEND FOR SPECIFIC NEW SPRINKLERS TO BE INSTALLED.

thaci & Peterson
 ARCHITECTS
 1000 W. BROADWAY, SUITE 100
 ATLANTA, GA 30333
 TEL: 404.525.1234
 FAX: 404.525.1235
 WWW.THACIANDPETERSON.COM

HENDERSON
 ENGINEERS
 5500 GLENVIEW AVENUE, SUITE 100
 ATLANTA, GA 30328
 TEL: 404.762.0000 FAX: 404.762.0001
 WWW.HENDERSONENGINEERS.COM
 GA CORPORATE NO. 167002724
 EXP. 03/31/2020

Walmart
JESUP, GA
 STORE NO. 1095
 JOB NUMBER: 190402620 139 SC GENERAL MODEL


ISSUE BLOCK

CHECKED BY: NAV/EC
 DRAWN BY: NM
 PROTO: 139 SC
 PROTO CYCLE: 06/31/18
 DOCUMENT DATE: 10/05/18

NOT FOR CONSTRUCTION

ENLARGED FIRE SPRINKLER PLAN

SHEET: FP.2

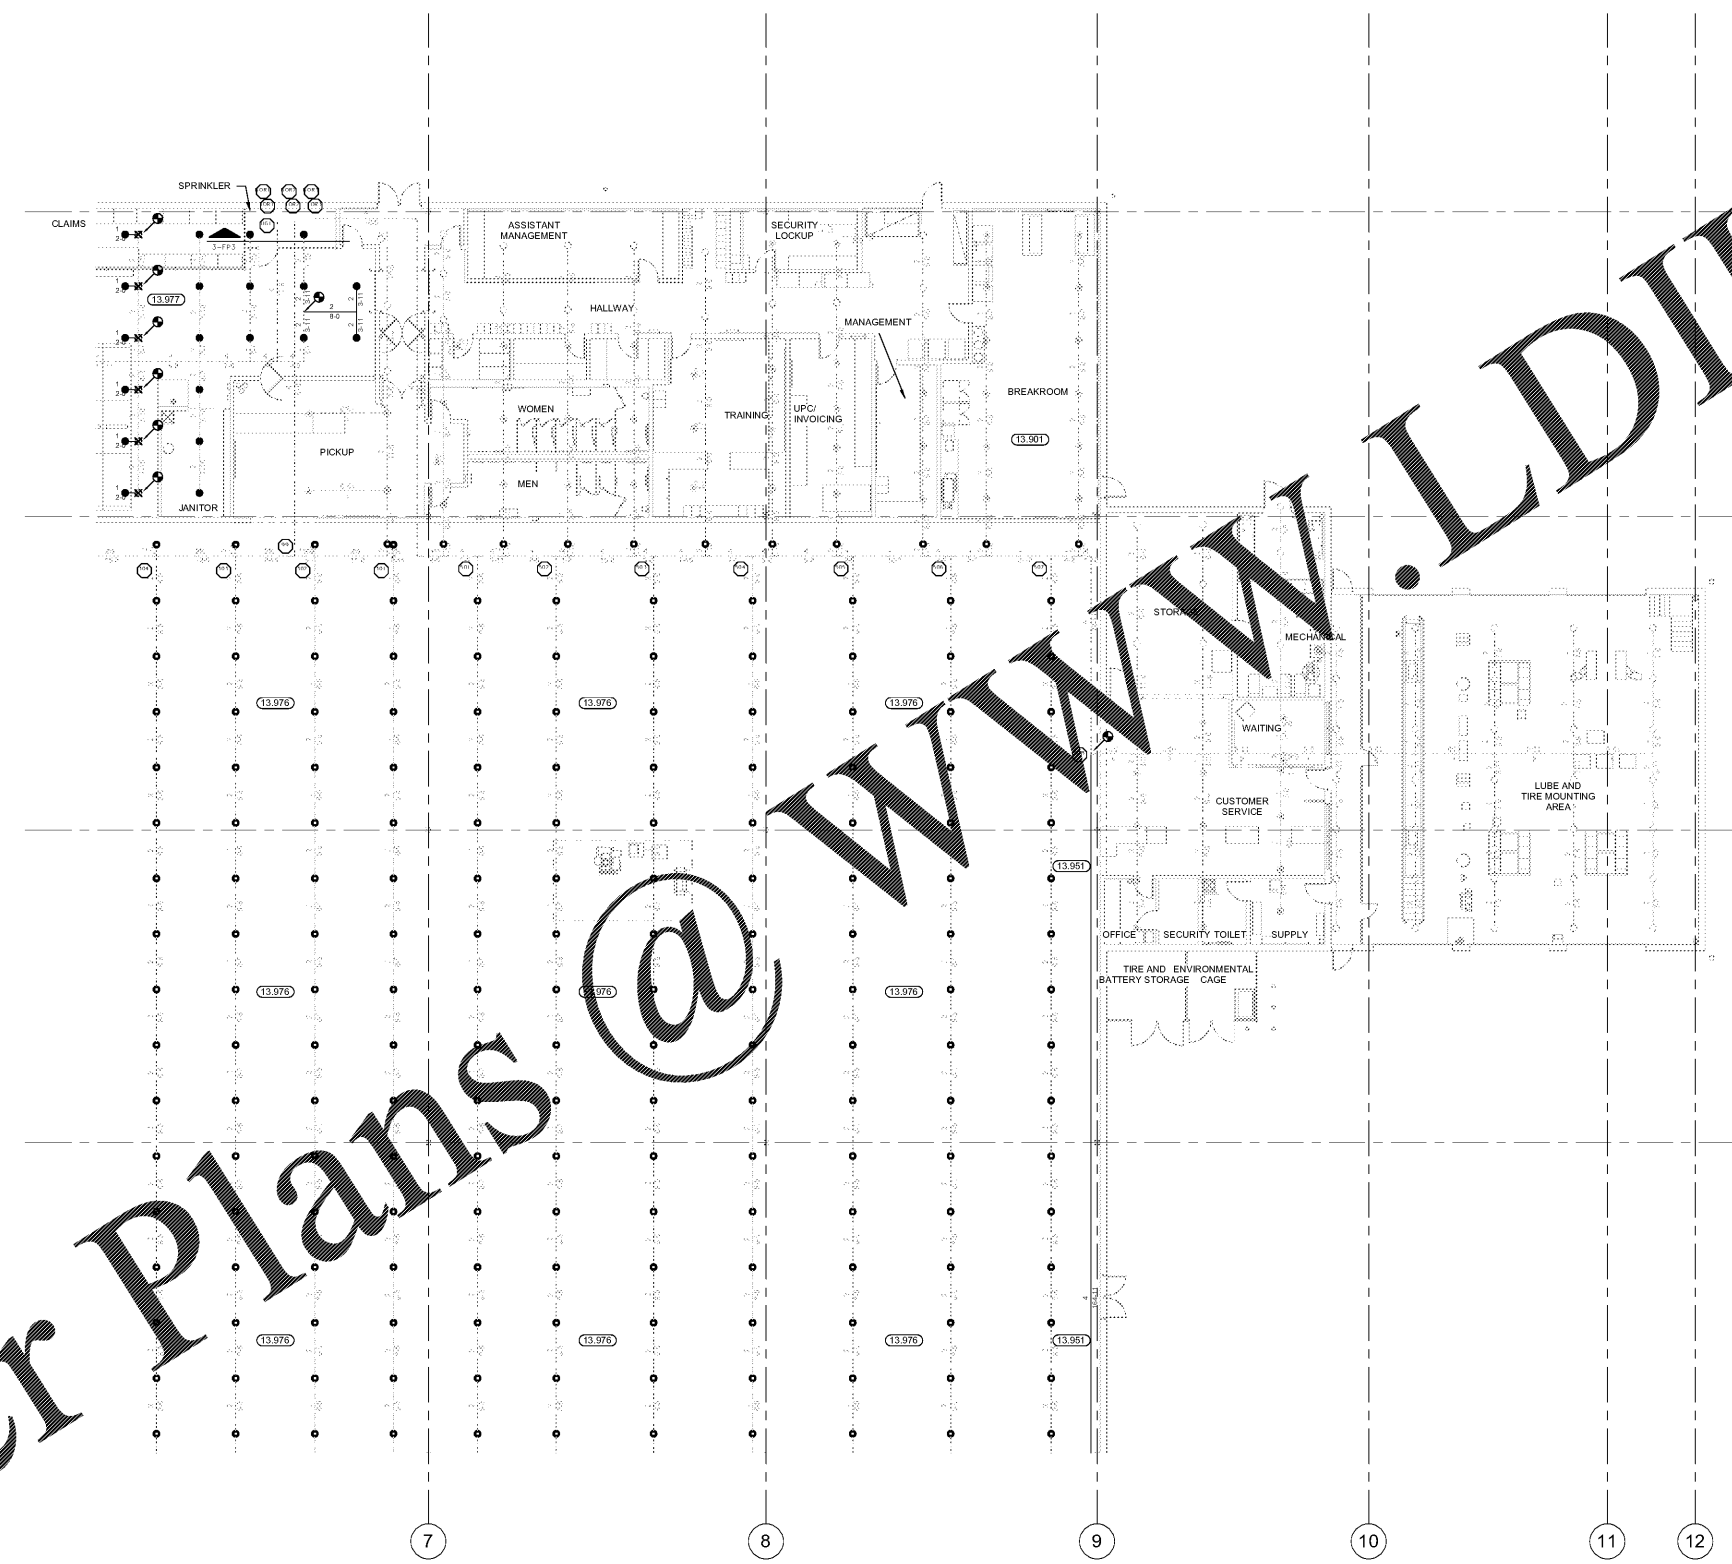

1 ENLARGED FIRE SPRINKLER PLAN
 SCALE: 3/32"=1'-0"
 0 4 8 12 16'

EXISTING CONDITIONS WERE TAKEN FROM ORIGINAL DRAWINGS AND MAY NOT REFLECT EXACT "AS-BUILT" CONDITIONS. CONTRACTOR SHALL FIELD VERIFY ALL EXISTING CONDITIONS PRIOR TO SUBMITTING FINAL BIDS. CONTRACTOR SHALL CAREFULLY COORDINATE NEW WORK AND DEMOLITION WITH ALL OTHER DISCIPLINES AND EXISTING CONDITIONS.

EACH SUBCONTRACTOR IS RESPONSIBLE FOR HAVING A THOROUGH KNOWLEDGE OF ALL DRAWINGS AND SPECIFICATIONS IN THEIR RELATED FIELD. THE FAILURE TO ACQUAINT THEMSELVES WITH THIS KNOWLEDGE DOES NOT RELIEVE THE RESPONSIBILITY OF PERFORMING THE WORK PROPERLY. NO ADDITIONAL COMPENSATION SHALL BE ALLOWED BECAUSE OF CONDITIONS THAT OCCUR DUE TO FAILURE TO FAMILIARIZE WORKERS WITH THIS KNOWLEDGE.

Order Plans @ WWW.LDILine.com