

GENERAL NOTES:

- A. EXTERIOR DIMENSIONS ARE TO FACE OF MASONRY. INTERIOR DIMENSIONS ARE TO FINISH.
- B. OVERALL DIMENSIONS TO EXTERIOR WALLS ARE THE SAME AS TO THE OUTSIDE FACE OF FOUNDATION WALL BELOW.
- C. ALL ANGLED WALLS ARE AT 90° UNLESS NOTED OTHERWISE.
- D. FIRE EXTINGUISHERS, SHALL COMPLY WITH APPLICABLE BUILDING CODES AND LOCAL RESTRICTIONS. G.C. SHALL PROVIDE ONE (1) TYPE 'ABC' EXTINGUISHER IN A SEMI-RECESSED, CLEAR ANODIZED ALUMINUM CABINET IN THE DINING ROOM AS LOCATED BY THE FIRE-MARSHAL AND ONE (1) TYPE 'K' EXTINGUISHER WALL-MOUNTED ON A BRACKET IN THE KITCHEN, COORD. W/ FOOD SERVICE AND THE LOCAL FIRE MARSHAL.
- E. ELEVATION OF DRIVE-THROUGH LANE 2" (MAXIMUM) BELOW FINISH FLOOR ELEVATION. DRIVE-THROUGH LANE AT SAME ELEVATION AS FINISH FLOOR IS PREFERRED. REFER TO DETAIL #2, SHEET A-11.
- F. AT THE KITCHEN THE G.C. IS TO PROVIDE STAINLESS STEEL OUTER CORNERS AT QUARRY TILE BASE IN LIEU OF QUARRY TILE CORNERS - SEE HTTP://WWW.CEQUARRYTILES.COM


KEYED NOTES:

- 1. SELF-SERVE DRINKS AND CONDIMENT STAND. REFER TO SHEET A-1.
- 2. STEEL BOLLARD - REFER TO SHEET S-1.
- 3. ELECTRIC SERVICE. REFER TO ELECTRICAL DRAWINGS.
- 4. SERVICE COUNTER PARTITION BY G.C. REFER TO DETAILS ON SHEET C-4 FOR ADDITIONAL INFORMATION. COORDINATE COUNTERTOP/FINISHES INSTALLATION RESPONSIBILITIES WITH THE SUPPLIER. MAXIMUM COUNTER HEIGHT = 32" A.F.F.
- 5. CORNER GUARDS OR END-CAP. REFER TO DETAIL #4, SHEET A-11.
- 6. MENU BOARD BULKHEAD ABOVE. REFER TO DETAIL #7, SHEET A-41.
- 7. INTERIOR WALL IN BOX WITH FLOOR OR CONCRETE SLAB. VERIFY SIZE WITH MANUFACTURER.
- 8. PROVIDE ADDITIONAL BLOCK SUPPORTS BEHIND URINAL SCREEN AND BEHIND PLUMBING FIXTURES FOR SUPPORT OF WATER LINES (TYPICAL).
- 9. FIRE EXTINGUISHER IN DINING PROVIDE (1) TYPE 'ABC' IN A PRE-FINISHED CLEAR ANODIZED, SEMI-RECESSED CABINET, AT KITCHEN PROVIDE (1) TYPE-K EXTINGUISHER ON WALL-MOUNTED BRACKET. COORD. W/ FOOD SERVICE SUPPLIER AND LOCAL FIRE-MARSHAL FOR PLACEMENT AND EQUIPMENT.
- 10. LINE OF AWNING/CANOPY ABOVE.
- 11. SUBMITTE PANELS:
- 12. KITCHEN - CREW - RESTROOMS
- 13. 5/8" USG "DUROCK" PANELS AT FINISH FLOOR TO 24" A.F.F.
- 14. 5/8" WATER RESISTANT GYPSUM BOARD FROM 24" A.F.F. TO 6" ABOVE FINISHED CEILING.
- 15. PROVIDE ALTERNATE BID OF 5/8" USG "FIBEROCK" PANELS IN LIEU OF DUROCK.
- 16. DINING ROOM - CORRIDOR
- 17. 5/8" TYPE USG "SHEETROCK" TYPE "X" GYPSUM WALL BOARD.
- 18. FINISH: CORONADO PAINT - LIGHT ORANGE PEEL APPLIED WITH CORONADO AIR ASSIST TIP (2-122K) OR EQUAL
- 19. ELEVATOR PANELS
- 20. OPTION #1:
- 21. RECESS ELECTRICAL CONTACTOR PANEL AND PANELS "A", "B" AND "M" IN FURRED OUT WALL ADJACENT TO EXTERIOR FRAMING. G.C. TO VERIFY PANEL SIZES PRIOR TO FURR-OUT TO INSURE ADEQUATE SPACE.
- 22. OPTION #2:
- 23. HILL PHOENIX INTEGRATED WALL UNIT INCLUDES PANELS "A", "B", "M" AND MASTER CONTACTOR PANEL IN ONE CABINET. UNIT TO BE SURFACE MOUNTED ON A 4" HIGH CONCRETE CURB. REFERENCE SHEET E-5 FOR ADDITIONAL INFORMATION.
- 24. PROVIDE 10"x10" FINISHED OPENING THROUGH WALL CENTERED AT 13" A.F.F. FOR ROUTING OF UTILITIES.
- 25. CAN WASH - DUROCK SUBSTRATE ON ALL THREE SIDES, FLOOR TO CEILING.
- 26. PROVIDE WALL ABOVE COOLER TO FILL GAP BET. COOLER & CEILING - WALL & SHEATING / GYP. TO EXTEND TO DECK AS DRAEL-SLOP - FINISH BELOW CEILING TO BE FRP OVER 5/8" GYP. BD. ON 2X STUDS @ 24" O.C.
- 27. FOUNDATION PLAN WIDENED AT EXTERIOR FEATURE (AT 'LEG' PROJECTIONS ONLY). REF. FOUNDATION PLAN
- 28. TILE FLOOR (REFERENCE SPECIFICATIONS ON ID SHEETS).
- 29. DRIVE-THROUGH SLIDING WINDOW.
- 30. ***** INDICATES 5/8" PLYWOOD BACKING ON WALLS FOR EQUIPMENT AS INDICATED ON PLAN OR SHELF SUPPORT FROM 48" A.F.F. TO 96" A.F.F., BEHIND 3-COMPARTMENT SINK AND PREP SINK AND ON BULKHEAD AT MENU BOARD WALL FROM 6'-8" A.F.F. TO BOTTOM OF ROOF TRUSSES.
- 31. COUNTER TOP - REFERENCE DETAIL #6, A-1-1.
- 32. USE 5/8" DUROCK (BOTH SIDES) ON 3-5/8", 18 GAUGE CEE STUD FRAMING AT 16" O.C. BEHIND HOOD. WALL TO EXTEND 18" BEYOND EACH END OF HOOD.
- 33. STAINLESS STEEL PANELS BELOW AND 18" WIDE AT OUTSIDE SIDES, CONTINUOUS BETWEEN HOOD(S) SUPPLIED BY HOOD MANUFACTURER AND INSTALLED BY G.C.
- 34. WALLS AT RESTROOMS SHOWN W/ ADDITIONAL DIMENSION SPACE TO ALLOW FOR TILE WALL FINISHES; STUDS @ 5-1/2" & 6" WALLS ARE TO BE 2X4 (NOM) STUDS W/ FINISHES, ETC.
- 35. BACK OF HOUSE FLOOR & BASE FINISHES TO BE THE FOLLOWING UNLESS NOTED OTHERWISE BY INTERIOR DECOR:
 - FLOOR - QUARRY TILE - 6X6 - DAL-TILE COLOR: 0042 'AIRD GRAY' W/ ADDED ABRASIVE GRAIN.
 - BASE - QUARRY TILE - 5X6 - DAL-TILE COLOR: Q-3565 'AIRD GRAY'
 - GROUT - LATOCRETE - SPECTRALOCK 2000G - COLOR: #45 'RAVEN'
 - TRANSITION STRIPS (AS NEEDED) - SCHLUTER SYSTEM - SCHIENE AND / OR AE 1000 - R, SATIN ANODIZED ALUMINUM - 3/8" - 10MM
- 36. OFFICE WINDOW - 1'-8"(W) X 2'-0" TALL CLEAR ANODIZED ALUM. STOREFRONT FRAMING W/ SINGLE PANE, CLEAR, TEMPERED GLAZING SET 3'-0" (MIN.) A.F.F.


CHECKED BY: [] DATE: 11/06/18
 DRAWN BY: MRW DATE: 11/06/18
 PROJECT NO: []
 RELEASED FOR CONSTRUCTION: []

BURGER KING
 PREMIER KINGS, INC.
 5529 CARMICHAEL ROAD
 MONTGOMERY, ALABAMA 36117
 PHONE: []
 LINSEY@BKAALABAMA.COM

2126 Morris Avenue, #203
 Birmingham, AL 35203
 Phone: (205) 322-1751
 Fax: (205) 322-1778
 Email: info@hphaha.com
 www.hphaha.com
hendon huckestein architects, PC
 architecture • planning • interior design

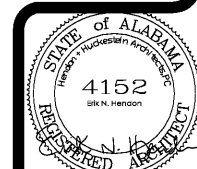

PROJECT #: 18026.1B
 ROC-2502 20/20 WAGE: APRIL 2015 DESIGN RELEASE
BURGER KING RESTAURANT
 SHORTER, AL
 FLOOR PLAN

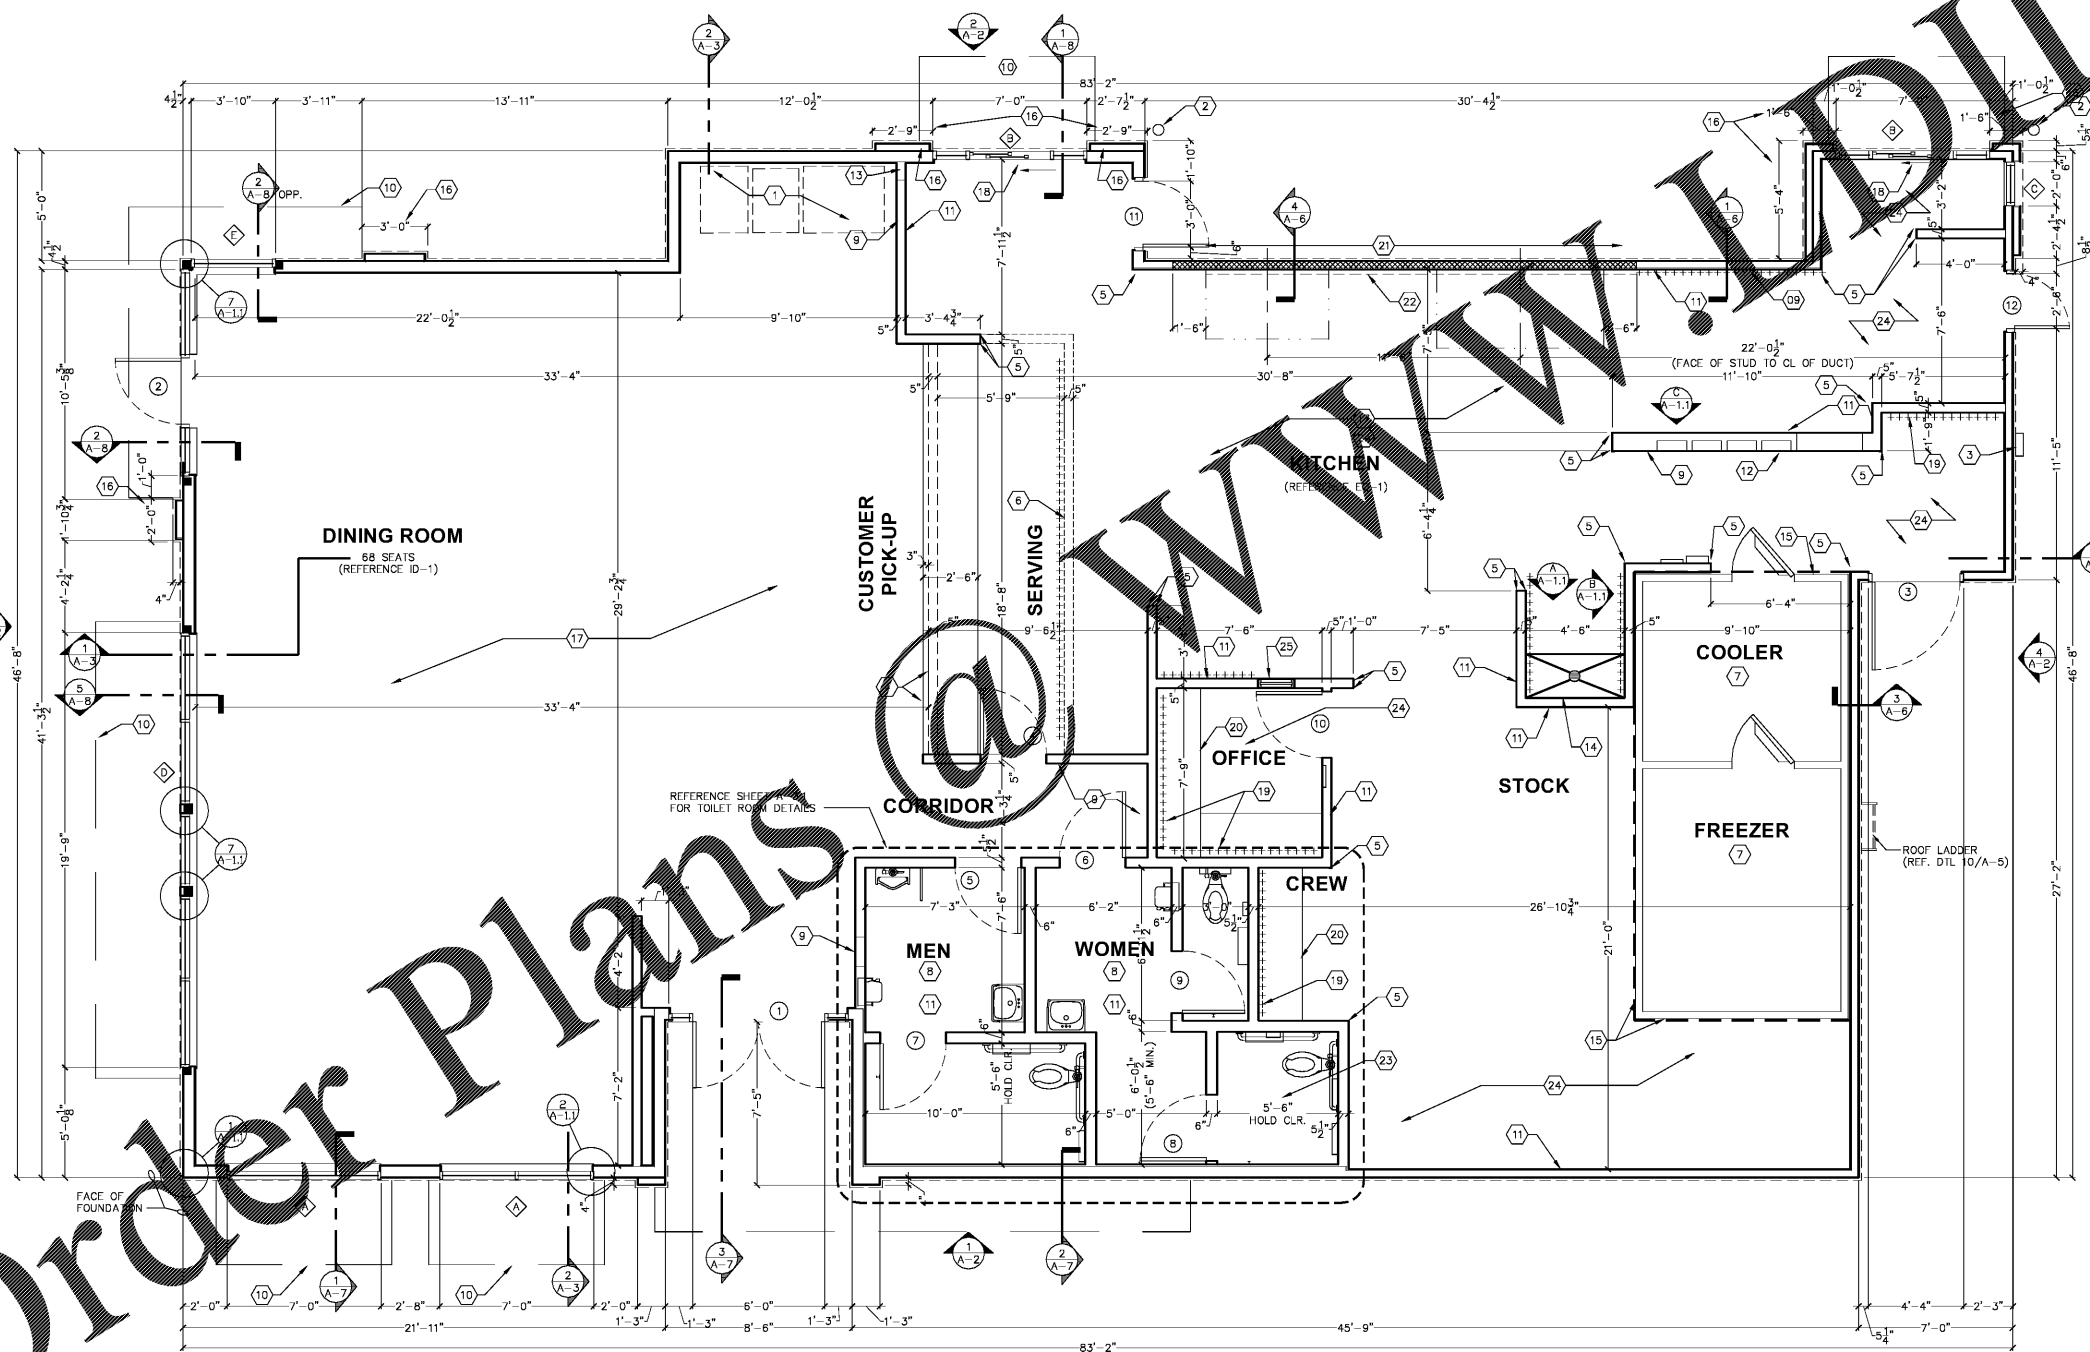

FLOOR PLAN
SCALE: 1/4" = 1'-0"