


**RESTROOM PLAN**

SCALE: 1/2" = 1'-0"

NOTE:  
REFER TO ELEVATIONS  
BELOW FOR PLACEMENT  
OF GRAB BARS.

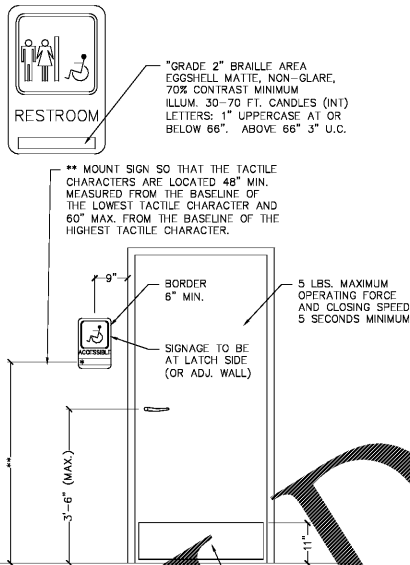


**GENERAL NOTES:**

- A. FOR INTERIOR FINISHES, REFER TO INTERIOR DECOR SHEETS.
- B. PLUMBING FIXTURES TO BE PROVIDED BY THE GENERAL CONTRACTOR.
- C. ALL PLUMBING FIXTURES, FAUCETS AND ACCESSORIES TO BE ADA COMPLIANT.
- D. ALL EXPOSED PIPING UNDER LAVATORIES TO BE INSULATED TO PROTECT FROM CONTACT. THERE SHALL BE NO SHARP OR ABRASIVE SURFACES UNDER LAVATORIES.

**RESTROOM / KITCHEN ACCESSORIES:**

- A. GRAB BAR: BOBRICK 260 LBF. MINIMUM 33" MIN. TO 36" MAX. HEIGHT TO THE TOP OF THE GRIPPING SURFACE. PROVIDE THE REQUIRED QUANTITY AND LENGTH AS INDICATED ON THE DRAWING AS REQUIRED BY THE GOVERNING CODE. THE BAR SHALL BE 1-1/2" IN DIAMETER AND MOUNTED WITH 1-1/2" CLEARANCE FROM THE WALL.
  - B. WALL MOUNTED SOAP DISPENSER AND HAND SANITIZER DISPENSER (36" MAX. HEIGHT) SUPPLIED BY "ECOLAB" AND INSTALLED BY THE G.C. NOTE: SOAP AND HAND SANITIZER DISPENSERS TO BE PROVIDED AT EACH HANDSINK.
  - C. MIRROR: (BOTTOM OF REFLECTIVE SURFACE AT 40" MAXIMUM HEIGHT) MODEL B-165-1836 (18"x36") STAINLESS STEEL PANEL FRAME MIRROR WITH THREE RESISTANT SCREWS BY BOBRICK OR APPROVED EQUIVALENT.
  - D. TOILET PAPER HOLDER: 9" TWIN JUMBO MODEL #5870 BY BOBRICK OR APPROVED EQUIVALENT.
  - E. PAPER WASTE RECEPTACLE: (RECYCLED) MODEL #2644 AS MANUFACTURED BY BOBRICK OR APPROVED EQUIVALENT THROUGH OPENING 16"W x 29-1/4"H x 4"D MIN. REQUIRED - PAPER TOWEL DISPENSER "SAN JAMAR" SUPPLIED BY PAPER TOWEL SUPPLIER AND INSTALLED TO THE G.C. MODEL #1-1290WS. OPTIONAL: HANDS FREE PAPER TOWEL DISPENSER: "SAN JAMAR" #1-1490WS (IN ADDITION TO PAPER TOWEL DISPENSER); ELECTRIC HAND DRYER: COLUMBIA VORTEX SEMI-RECESSED DELUXE SERIES AUTOMATIC TOUCH-FREE SENSOR HAND DRYER. MODEL #D-635-210. NOTE: HAND DRYER TO BE INSTALLED AT A MAXIMUM HEIGHT OF 48" FROM FINISH FLOOR OR CEILING TO TOP OF SENSOR OR PER ADA REQUIREMENTS. NOTE: PROVIDE PAPER TOWEL DISPENSER "SAN JAMAR" MODEL #1-1490BK AT EACH HAND SINK IN KITCHEN.
  - F. TOILET SEAT COVER DISPENSER: BY ROCHESTER MIDLAND CORP. PRODUCT CODE: 25132000 (WHITE PLASTIC)
  - G. URINAL SCREEN: BOBRICK 1080/1180 DURALINE SERIES #EO-09 COLOR: BLACK
  - H. SANITARY NAPKIN DISPOSAL: BOBRICK CONTRA SERIES B-270, SURFACE MOUNTED.
  - J. COAT HOOK: BOBRICK MODEL B-6717 TO BE MOUNTED ON INSIDE OF EACH RESTROOM DOOR FOR SINGLE OCCUPANCY RESTROOMS AND EACH RESTROOM STALL DOOR FOR MULTIPLE OCCUPANCY RESTROOMS. MOUNT AT 38"-40" A.F.F. FOR ADA ACCESSIBLE LOCATIONS AND AT 48" A.F.F. MAXIMUM FOR NON-ADA ACCESSIBLE LOCATIONS.
- OPTIONAL:  
TOILET STALL PARTITIONS: BOBRICK 1080/1180 DURALINE SERIES #EO-09 COLOR: BLACK  
MARLITE LAMINATE OR PHENOLIC URINAL SCREEN AND TOILET PARTITIONS MAY BE USED AS AN ALTERNATE TO BOBRICK SPECIFICATION.

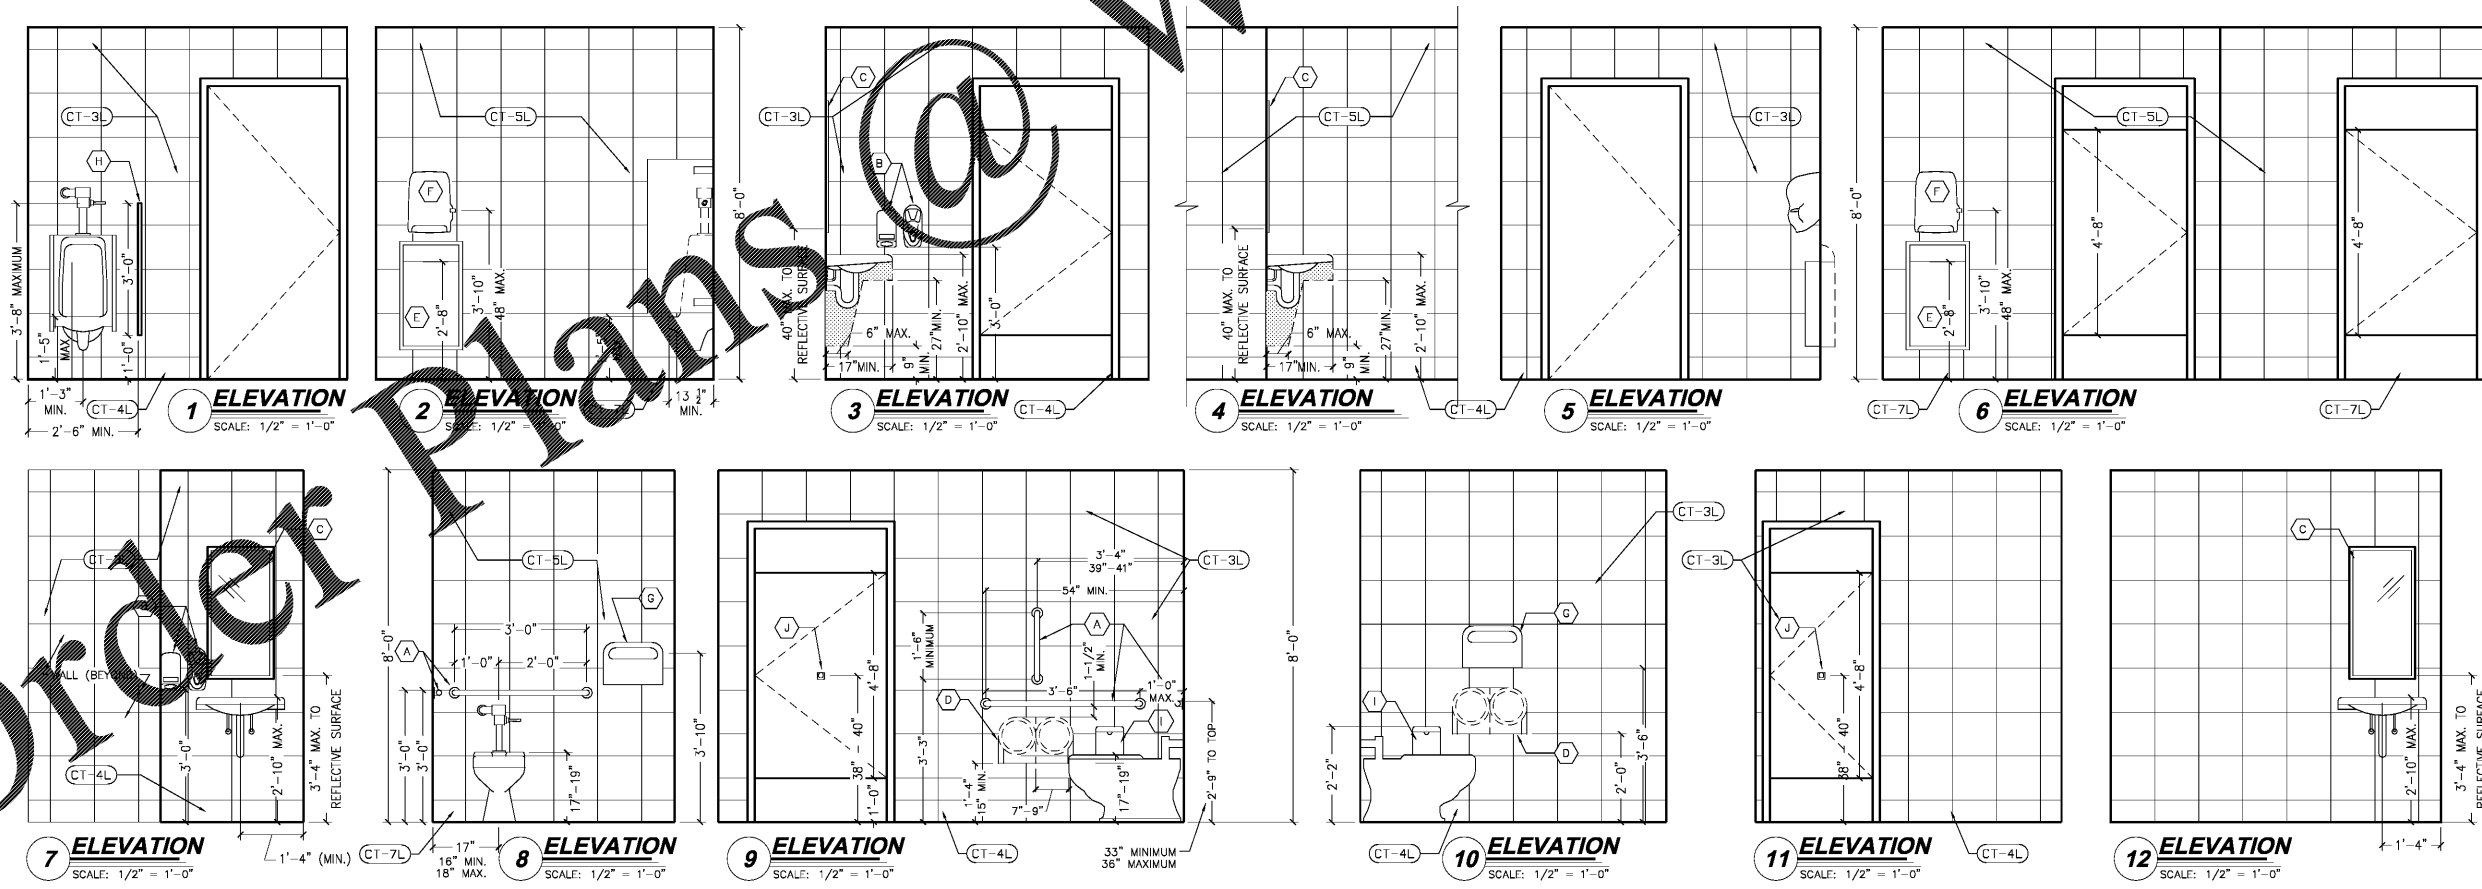

Order Plans

WWW.LDMLD.COM

PROJECT #18026.1B  
ROC-60 20/20 MAGE: APRIL 2015 DESIGN RELEASE  
**BURGER KING RESTAURANT**  
SHORTER, AL  
RESTROOM ADA PLANS & INTERIOR ELEVATIONS  
A-3.1

PREMIER KINGS, INC.  
5529 CARMICHAEL ROAD  
MONTOMOERY, ALABAMA 36117  
PHONE: (205) 322-1778  
FAX: (205) 322-1778  
EMAIL: info@pkh.com  
WWW.PKH.COM

2126 Morris Avenue  
Birmingham, AL 35203  
Phone: (205) 322-1751  
Fax: (205) 322-1778  
Email: info@huckestein.com  
www.huckestein.com

hendon  
huckestein  
architects, PC  
architecture • planning • interior design

STYLING of ALABAMA  
REGISTERED ARCHITECT  
4152  
Lila N. Hendon

PROJECT #18026.1B  
ROC-60 20/20 MAGE: APRIL 2015 DESIGN RELEASE  
**BURGER KING RESTAURANT**  
SHORTER, AL  
RESTROOM ADA PLANS & INTERIOR ELEVATIONS  
A-3.1

DRAWN BY: MRW  
CHECKED BY: JLS  
NO. DATE: 11/06/18  
11/06/18  
RELEASED FOR CONSTRUCTION  
BD