

OVERVIEW

USUALLY THE EXHAUST HOOD IS PROVIDED BY FRANKIE FOODSERVICE SYSTEMS. THE FOLLOWING INCLUDE THE FOLLOWING:

1. HOOD AND SUPPLEMENTARY SYSTEMS
2. METAL FAN OR LISTED CHARGE EXHAUST DUCT
3. EXHAUST CHARGE EXHAUST FAN
4. AMEREX FIRE SYSTEM

THE SHIPMENT FROM FRANKIE FOODSERVICE SYSTEMS WILL INCLUDE THE FOLLOWING:

1. HOOD
2. ULTRAFIBER FILTERS
3. WALL FLASHING
4. TYPICAL PANELS
5. CHARGE EXHAUST FILTERS
6. METAL FAN CHARGE EXHAUST DUCT

THE LOWER COOK EXHAUST FAN AND ROOF CURB IS PROVIDED SHIPPED FROM THE FACTORY.

THE SUPPLEMENTARY SYSTEM THE HOOD HAS BEEN FACTORY PREPARED FOR AN AMEREX FIRE SUPPRESSION SYSTEM. THE HOOD HAS BEEN FACTORY PREPARED FOR AN AMEREX FIRE SUPPRESSION SYSTEM. THE HOOD HAS BEEN FACTORY PREPARED FOR AN AMEREX FIRE SUPPRESSION SYSTEM.

AS AN OPTION, THE HOOD MAY BE PREPARED FOR AN AMEREX FIRE SUPPRESSION SYSTEM.

CONTACT INFORMATION

ANSUL INSTALLATION QUESTIONS
ANSUL INC. MARKETING & SALES DEPARTMENT
PHONE: 1-800-888-6785

GENERAL NOTES FOR INSTALLATION CREWS
SCALE: AS SHOWN

CONTACT INFORMATION

SHIPPING INFORMATION
FOR ALL FRANKIE HOOD PARTS - AMEREX AMT
FRANKIE FOODSERVICE SYSTEMS, INC.
800 EASTERN PARKWAY
DALLAS, TX 75210
1-817-452-4271
1-817-452-4272

HOOD INSTALLATION QUESTIONS
FRANKIE FOODSERVICE SYSTEMS, INC. TECHNICAL SUPPORT
PHONE: 1-800-888-6785
1-817-452-4271
E-MAIL: PS-TS@FRANKIE.COM

AMEREX INSTALLATION QUESTIONS
THE HOOD IS FACTORY PREPARED FOR AN AMEREX FIRE SUPPRESSION SYSTEM. THE LOCAL AMEREX DISTRIBUTOR WILL HAVE CONTACT WITH THE SPECIAL CONTRACTOR TO SET UP THE INSTALLATION SCHEDULE. IF YOU HAVE NOT HEARD FROM THE DISTRIBUTOR, CONTACT:

AMEREX
AMEREX CORPORATION, BRIDGEVILLE, PA
1-800-445-0779

LOWER COOK FAN INSTALLATION
IF THERE ARE QUESTIONS ON ISSUES WITH THE LOWER COOK FAN INSTALLATION CONTACT:

GRAND FAN
LOWER COOK FAN, SPRINGFIELD, MO
1-417-884-8473

METAL-FAN DUCT INSTALLATION
IF THERE ARE QUESTIONS ON ISSUES WITH THE METAL-FAN DUCT INSTALLATION CONTACT:

METAL FAN DUCT WORKERS INC.
COMMERCIAL SERVICE, COMMERCIAL VENT PRODUCTS
1-877-837-8833

BROILER HOOD LISTING AND APPROVAL REFERENCE



INTERTEK TESTING SERVICES, INC.
BROILER HOOD IS ETL LISTED EXHAUST HOODS WITHOUT EXHAUST DUCTS. REFER TO 318.0270, LISTED UNDER IN ACCORDANCE WITH UNDERWRITERS LABORATORIES COMPARABLE LISTING AND LABELING.



NATIONAL FIRE PROTECTION ASSOCIATION
COMBUSTION BROILER/OWNER HOOD MEETS ALL REQUIREMENTS OF NFPA-96 "STANDARD FOR FIRE PROTECTION OF COMMERCIAL KITCHENS AND FOOD SERVICE EQUIPMENT"





NATIONAL SANITATION FOUNDATION
MEETS ALL REQUIREMENTS OF NSF STANDARD NUMBER 2 FOOD SERVICE EQUIPMENT

MECHANICAL CODES



MEETS ALL REQUIREMENTS OF THE UMC, BOCA, BOSS AND IBC.

APPROVALS



SCALE: AS SHOWN

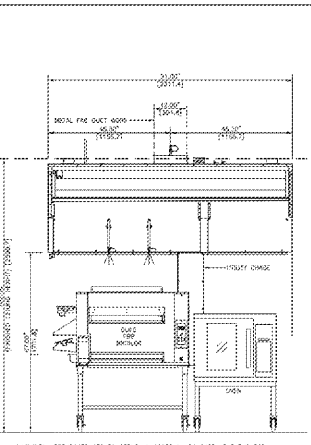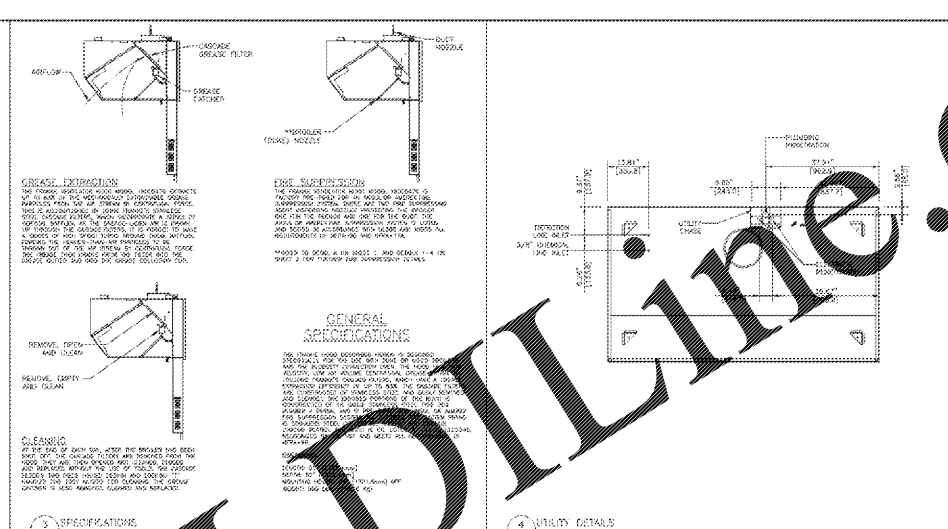


FRONT ELEVATIONS
SCALE: AS SHOWN

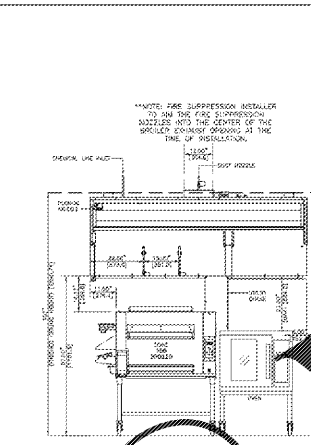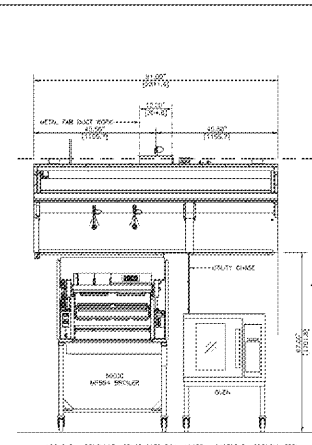


FRONT ELEVATION FIRE SUPPRESSION DETAILS
SCALE: AS SHOWN

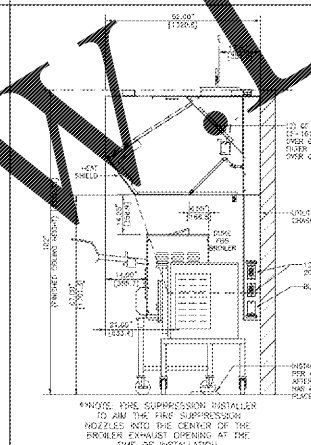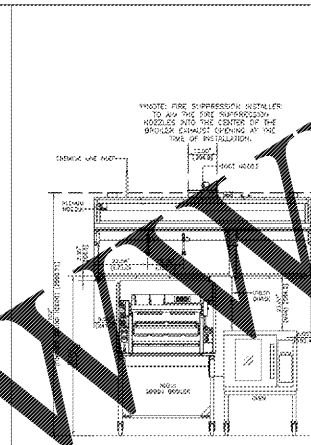


SECTION VIEWS
SCALE: AS SHOWN

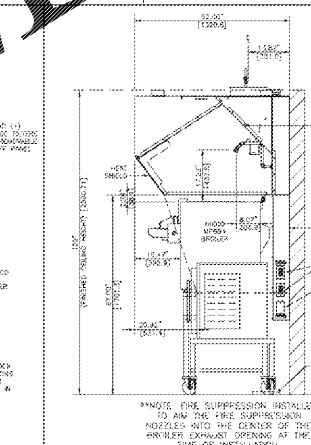


SECTION VIEWS
SCALE: AS SHOWN

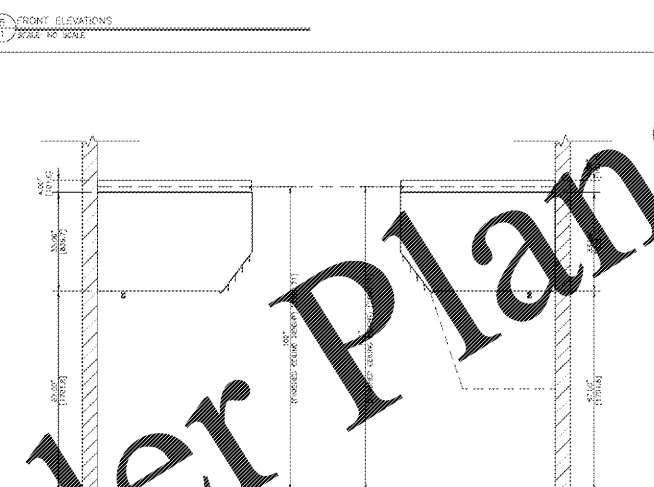

DUCT AND ELECTRICAL CHASE DETAILS
SCALE: AS SHOWN

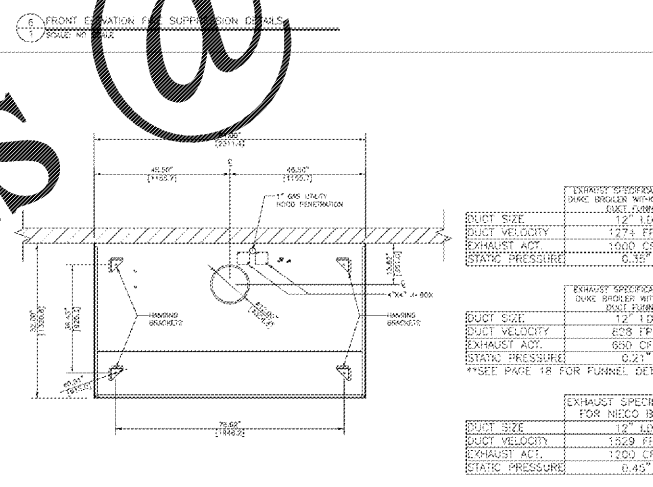

PLAN VIEW
SCALE: AS SHOWN

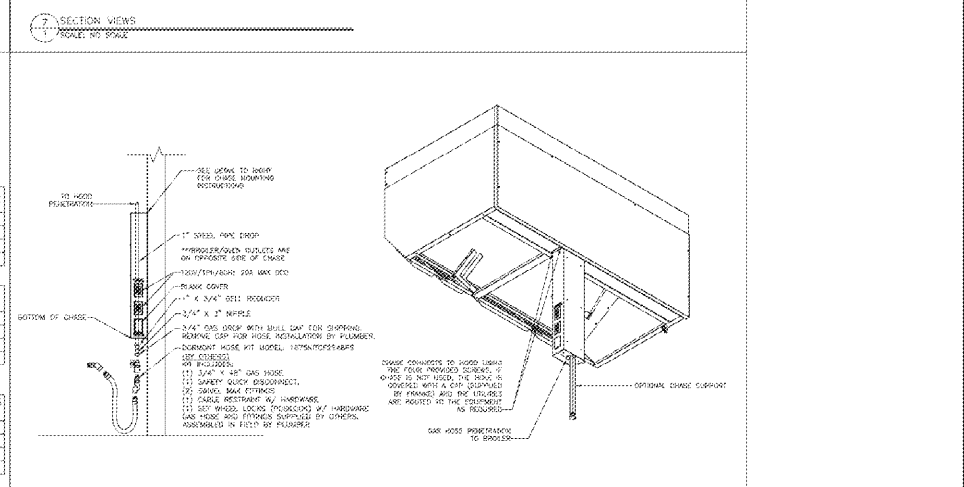

TYPICAL GAS AND ELECTRICAL CHASE DETAILS
SCALE: AS SHOWN

NO.	DATE	REVISION	DESCRIPTION
1	12/18/14	D-SIZE ADDITION	

Revision of: Duct



Frankie Foodservice Systems, Inc.
530 Howard Avenue
Tampa, FL 33607
Tel: 888-637-8855
tampa@frankie.com
www.frankie.com

BURGER KING
Restaurant #
91" COMBO HOOD
INSTALLATION DETAILS

Site Address
City
State
County
Region
Contract Name
Contract Number
Project Manager
Project Location
Project Order Number
Contractor
WHIP
Date Issued
12/18/2014
Issued By
FV007
Drawing Scale
AS NOTED
Notes
Revisions
Developed By
Shane R. Hamilton

Shane R. Hamilton P.E.
CONSULTING ENGINEER
1717 N. Howard Avenue
Tampa, FL 33607 (813) 251-6848

STORE #
BCC-40-20/20 MAKE: SEPTEMBER, 2016 DESIGN RELEASE
BURGER KING RESTAURANT
OFF OF I-40, THEN MAYBELLINE RD.
GALLOWAY, AR

TYPE-1 HOOD DETAILS (BROILER)

DATE: 8.23.17
DRAWN BY: C.W.W.
NO. DATE

FRANKIE

CAMBRIDGE FRANCHISE HOLDINGS

IA ARCHITECTURE

LICENSURE ENGINEER SHANE R. HAMILTON

M-6