 




Order Plans @

Luminaire Schedule			
Symbol	Label	Catalog Number	Description
	A	EWMLLED280-3	EW Area Light with Type 3 Optics
	B	EWMLLED280-4	EW Area Light with Type 4 Optics
	C	EWMLLED280-5	EW Area Light with Type 5 Optics
	D	EWMLLED280-3	EW Area Light with Type 3 Optics (double 180 degree)
	F		Energywise LED Spot Light

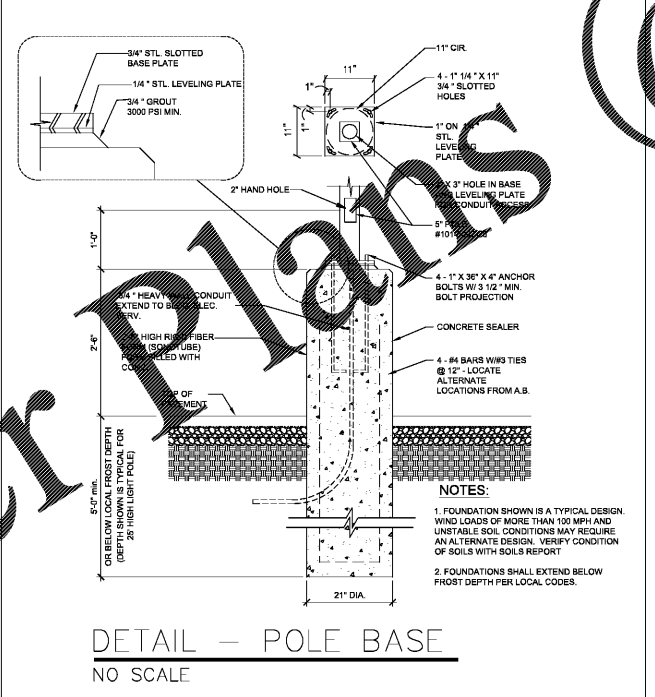


SITE PLAN - ELECTRICAL
SCALE: 1/16" = 1'-0"

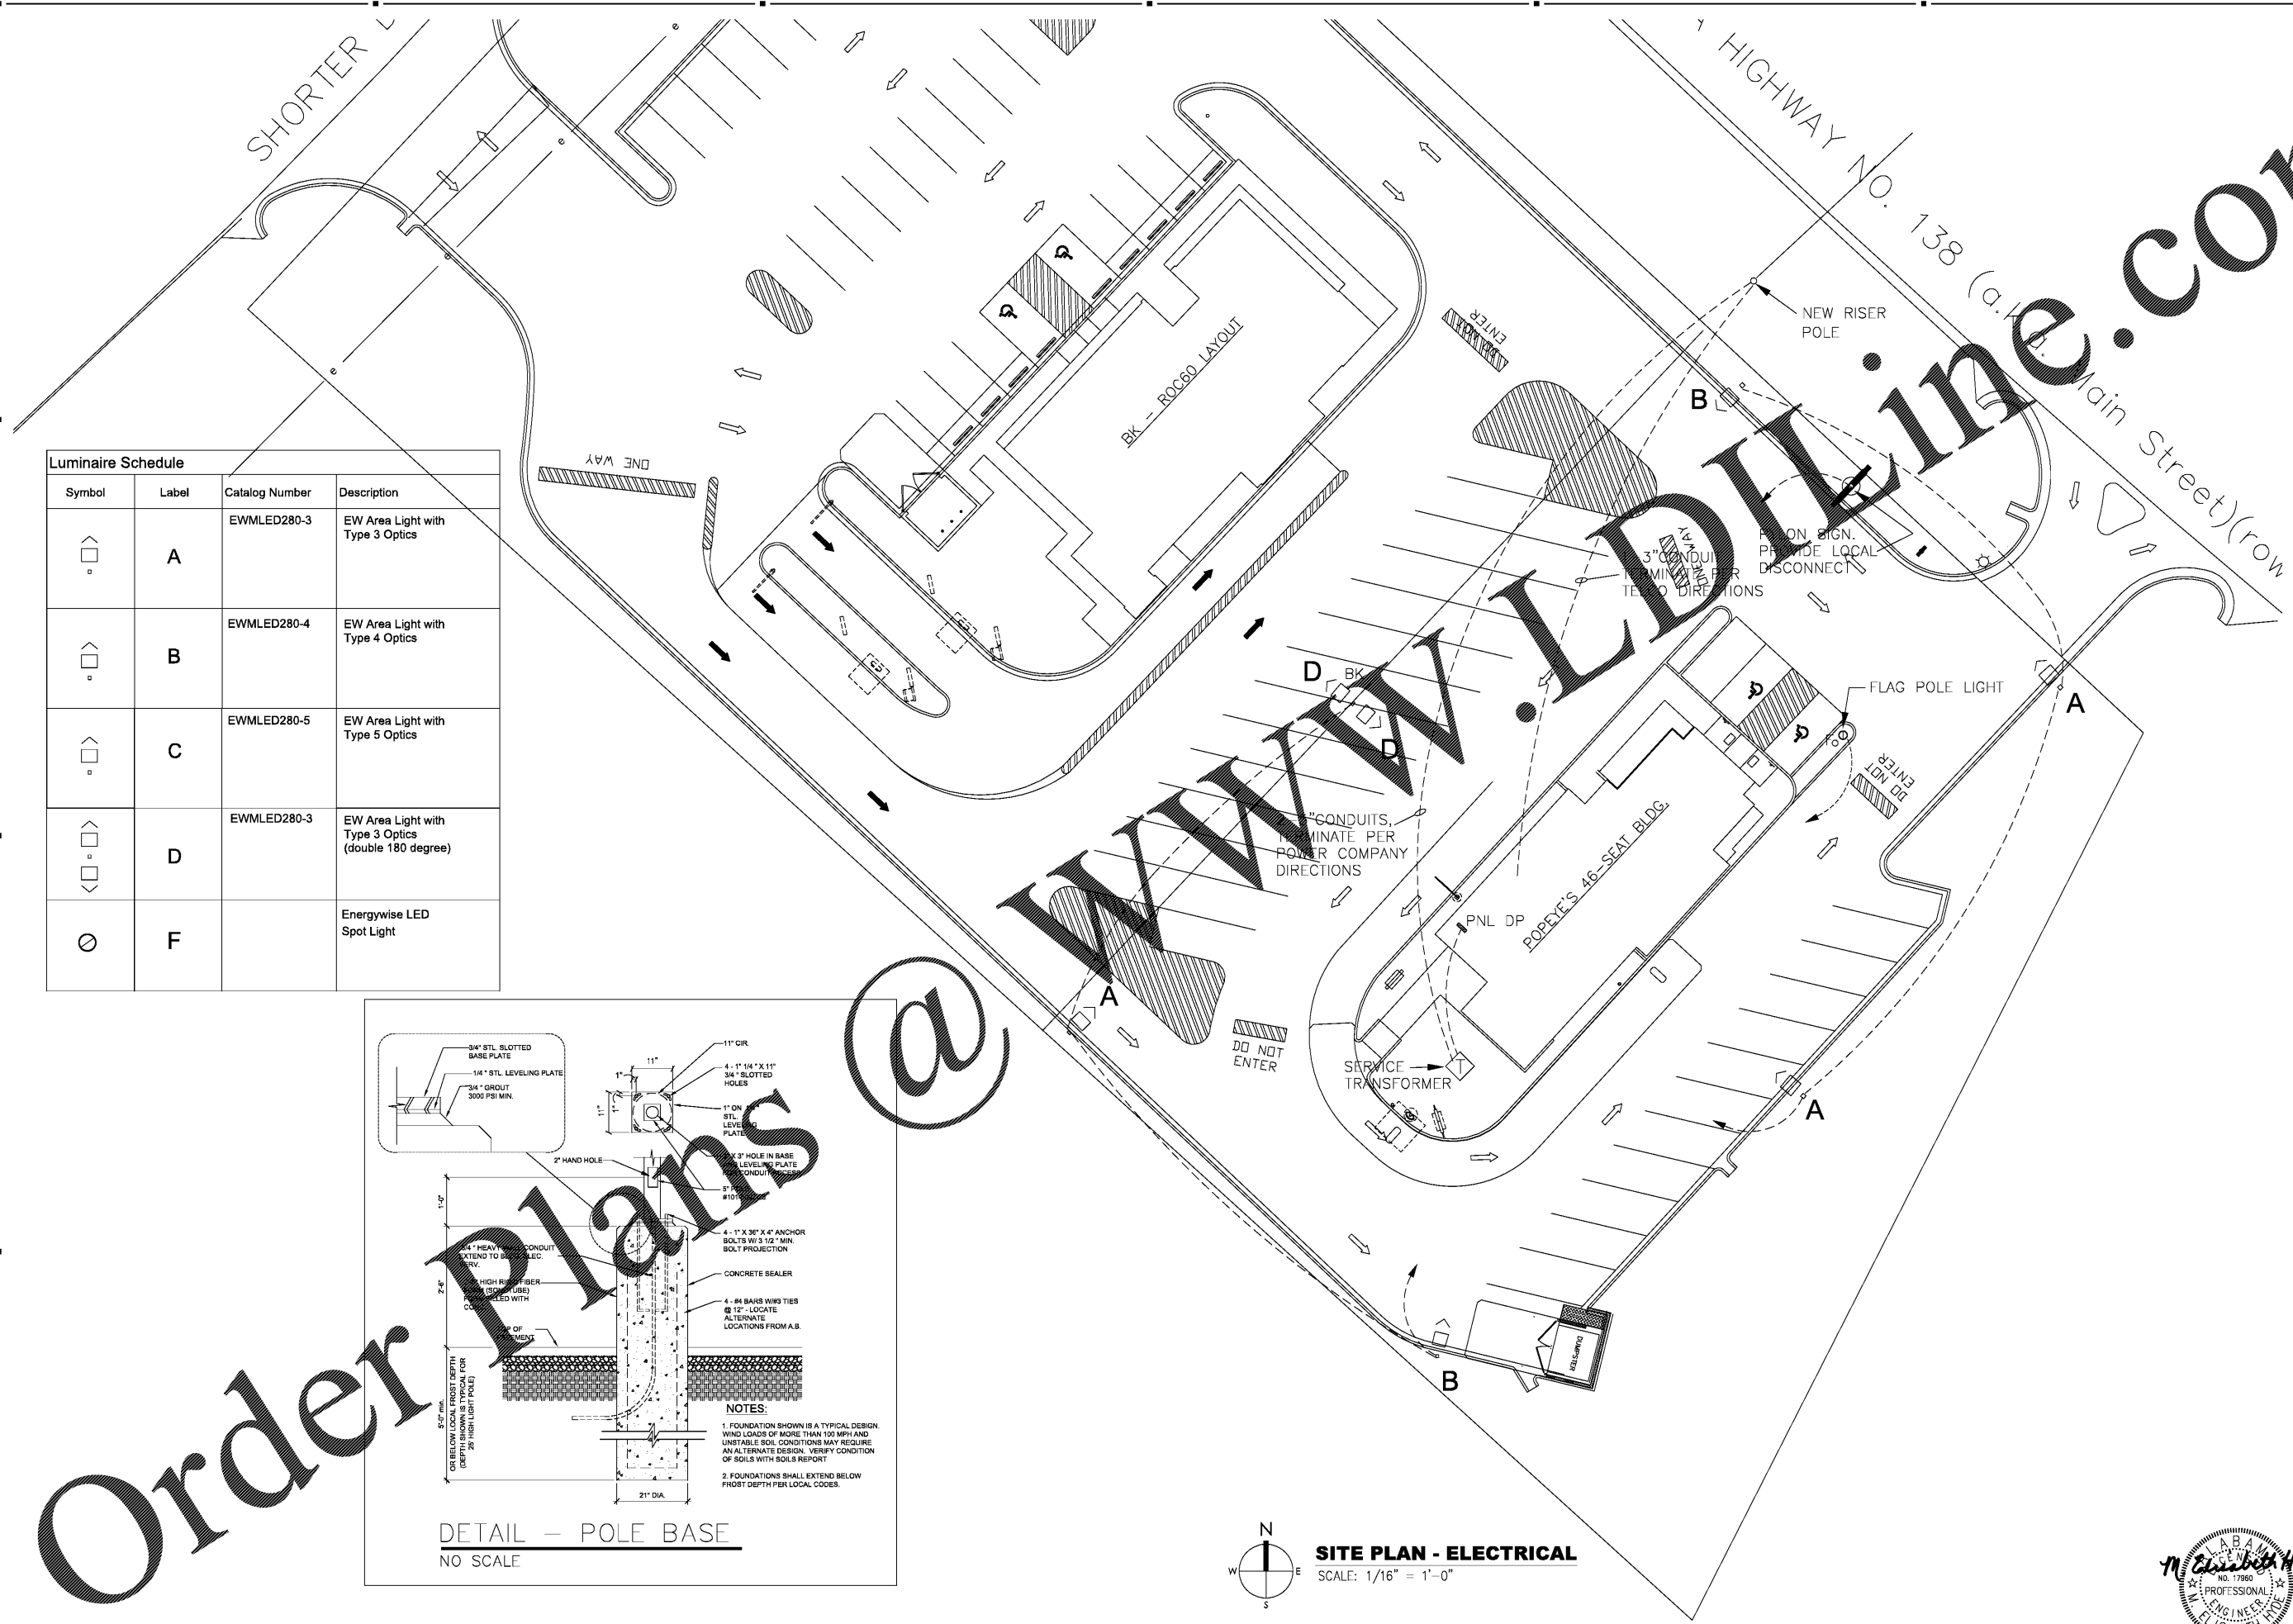

POPEYES
400 PERMET CENTER TERRACE
SUITE 100
ATLANTA, GA 30348
404-458-4462

hendon huckestein architects, PC
architecture • planning • interior design
2124 Morris Avenue Birmingham, AL 35203
Phone (205) 322-1751
Fax (205) 322-1778
email info@hplusha.com
www.hplusha.com
DRAWN BY: DB
CHECKED BY: MRW, EH
DATE: 09.27.2018
H-HA PROJECT #: 18064.14

PREMIER CAJUN KINGS, LLC - POPEYES
Near 431 Main St,
Shorter, AL 36075
LOUISIANA KITCHEN PLK DESIGN STANDARDS
PLK1 1846-DL PROTOTYPE: 46 SEATS / DUAL-LINE PRODUCTION

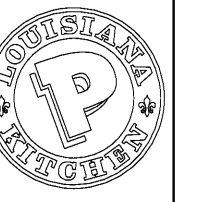

POPEYES

PERMIT/BID SET 09.27.18

ELECTRICAL SITE PLAN

E6
DATE: 9.27.18
CHECKED: MEH

