



GENERAL NOTES:
REFER TO FLOOR PLAN FOR RESTROOM ORIENTATION

- REFER TO ENLARGED RESTROOM PLAN ON SHEET A1.1 FOR TOILET FIXTURES AND LAVATORIES LOCATIONS.
- REFER TO ELEVATIONS ON THIS SHEET FOR WALL ELEVATIONS.
- REFER TO ACCESSORY MOUNTING LEGEND FOR ACCESSORY INSTALLATION HEIGHTS AND LOCATIONS.


1 RESTROOM ACCESSORIES PLAN
A4.1 SCALE: 1/4" = 1'-0"

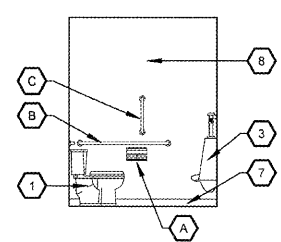


2 MEN'S ELEVATION
A4.1 SCALE: 1/4" = 1'-0"

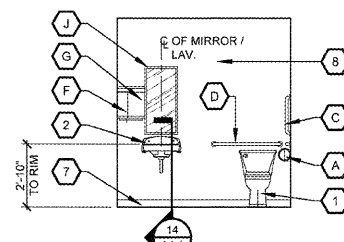


3 MEN'S ELEVATION
A4.1 SCALE: 1/4" = 1'-0"

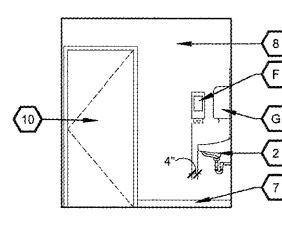


4 MEN'S ELEVATION
A4.1 SCALE: 1/4" = 1'-0"

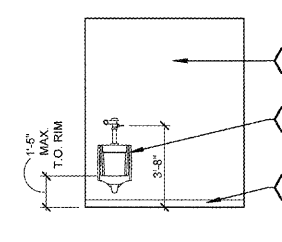


5 MEN'S ELEVATION
A4.1 SCALE: 1/4" = 1'-0"

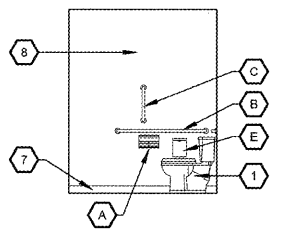


6 WOMEN'S ELEVATION
A4.1 SCALE: 1/4" = 1'-0"

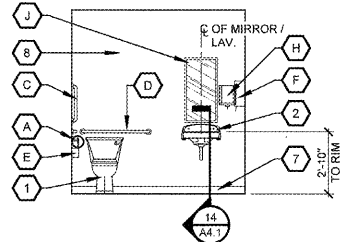


7 WOMEN'S ELEVATION
A4.1 SCALE: 1/4" = 1'-0"

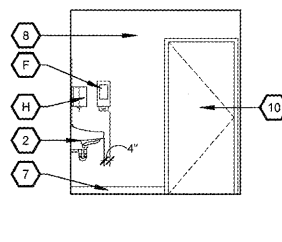


8 WOMEN'S ELEVATION
A4.1 SCALE: 1/4" = 1'-0"

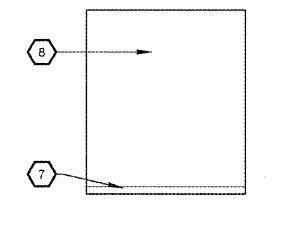


9 WOMEN'S ELEVATION
A4.1 SCALE: 1/4" = 1'-0"

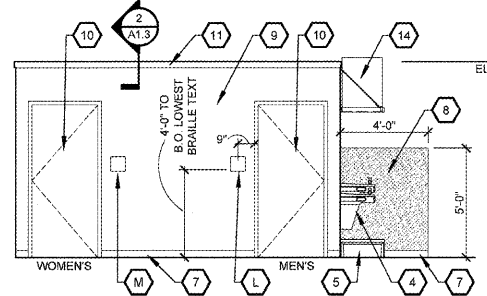



10 RESTROOM ELEVATION
A4.1 SCALE: 1/4" = 1'-0"

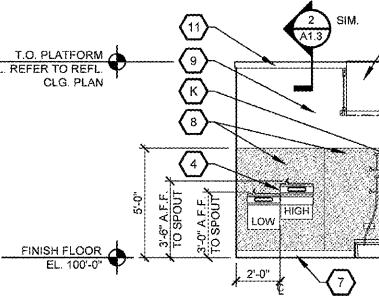

11 ELEVATION
A4.1 SCALE: 1/4" = 1'-0"

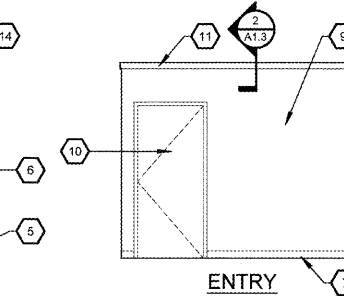


12 OFFICE ELEVATIONS
A4.1 SCALE: 1/4" = 1'-0"

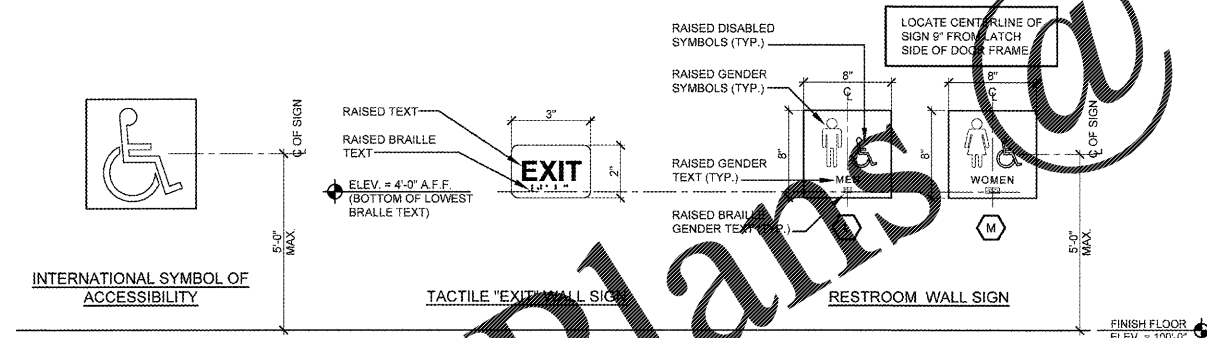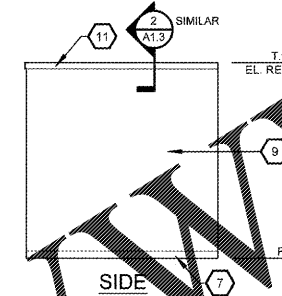


GENERAL NOTES:

- SIGNS SHALL COMPLY WITH CONFORM TO ANSI ICC-A117.1-2017 STANDARDS FOR ACCESSIBLE DESIGN OR BY LOCAL ACCESSIBILITY GUIDELINES WHICHEVER IS MORE STRINGENT.
- ALL ENTRANCES THAT ARE ACCESSIBLE AND USABLE BY PERSONS WITH DISABILITIES SHALL BE IDENTIFIED WITH A MINIMUM OF ONE "INTERNATIONAL SYMBOL OF ACCESSIBILITY".
- ACCESSIBLE SIGNS TO BE INSTALLED ON THE LATCH SIDE OF THE DOOR, OR IF NO FACE ON THE NEAREST WALL PREFERABLY ON THE RIGHT. SIGNAGE SHALL BE FINISH WITH A CONTRASTING BACKGROUND, REFER TO SHEET A1.1 AND A4.1 FOR LOCATION OF SIGNAGE.
- ALL SIGNS MUST BE A DISTINCTIVE DIFFERENCE FROM ITS MOUNTING SURFACE IN COLOR/ CONTRAS.
- GENERAL CONTRACTOR TO PROVIDE TACTILE "EXIT" SIGN AT ALL GRADE LEVEL EXIT DOORS, UNLESS OTHERWISE REQUIRED BY LOCAL AUTHORITY. INSTALL PERSON COMPLIANT ON THE WALL ADJACENT TO THE LATCH SIDE OF THE DOOR WITH CONTRASTING AND RAISED LETTERING AND GRADE 2 BRAILLE.

13 ACCESSIBLE SIGNAGE
A4.1 SCALE: 1/2" = 1'-0"

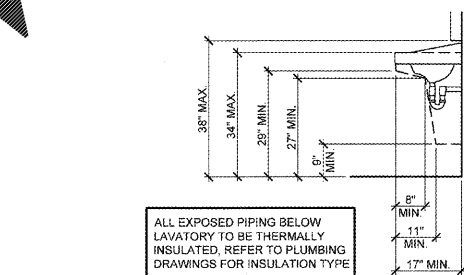

14 LAVATORY CLEARANCES
A4.1 SCALE: 1/2" = 1'-0"

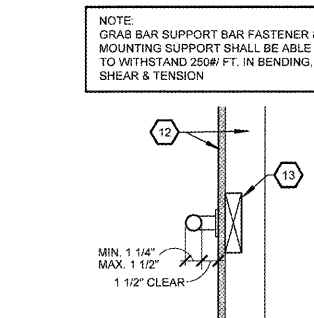

15 GRAB BAR DETAIL
A4.1 SCALE: 1 1/2" = 1'-0"

GENERAL NOTES

- REFER TO ARCHITECTURAL GENERAL SPECIFICATIONS FOR ADDITIONAL REQUIREMENTS.
- REFER TO PLUMBING DRAWINGS FOR FIXTURE TYPES AND REQUIREMENTS. PROVIDE ADDITIONAL COLD FORM METAL FRAMING OR FIRE RETARDANT TREATED SOLID WOOD BLOCKING SECURELY ANCHORED TO WALL FRAMING AS REQUIRED FOR PROPER SUPPORT.
- REFER TO SHEET A1.1 FOR PLUMBING FIXTURE LOCATIONS.
- REFER TO INTERIOR FINISH SCHEDULE ON SHEET A1.2 FOR MATERIAL FINISH TYPES AND LOCATIONS.
- ALL EXPOSED PIPING BELOW LAVATORIES TO BE THERMALLY INSULATED, REFER TO PLUMBING DRAWINGS FOR INSULATION TYPE.
- ALL DIMENSIONS SHOWN ARE FROM FACE OF GYPSUM WALLBOARD AND TOP OF CONCRETE FLOOR SLAB.
- ALL RESTROOM ACCESSORIES SHALL COMPLY WITH ANSI ICC-A117.1-2017 STANDARDS FOR ACCESSIBLE DESIGN OR BY LOCAL ACCESSIBILITY CODES.
- CONTRACTOR TO PROVIDE FIRE RETARDANT TREATED SOLID WOOD BLOCKING SECURELY ANCHORED TO WALL FRAMING FOR INSTALLATION OF ALL RESTROOM ACCESSORIES, INCLUDING OWNER FURNISHED AND INSTALLED ACCESSORIES NOTED ON THE ACCESSORY SCHEDULE. COORDINATE REQUIREMENTS WITH O'REILLY'S PROJECT ADMINISTRATOR.

KEYNOTES


- ACCESSIBLE WATER CLOSET FIXTURE: HEIGHT TO BE 17" TO 19" MEASURED FROM TOP OF CONCRETE FLOOR SLAB TO THE TOP OF THE TOILET SEAT. CONTROLS TO BE NO MORE THAN 44" ABOVE THE TOP OF CONCRETE FLOOR SLAB WITH A MAXIMUM 5-POUND-FORCE REQUIRED FOR ACTIVATION. ACCESSIBLE FIXTURE FLUSH CONTROLS TO BE ON THE WIDE SIDE OF TOILET.
- WALL HUNG LAVATORY, REFER TO PLUMBING DRAWINGS.
- WALL HUNG URINAL, REFER TO PLUMBING DRAWINGS.
- HIGH / LOW DRINKING FOUNTAIN WITH CAME GUARD REFER TO PLUMBING DRAWINGS.
- FLOOR MOUNTED JANITOR SINK, REFER TO PLUMBING DRAWINGS.
- EYE WASH STATION, REFER TO PLUMBING DRAWINGS FOR LOCATIONS.
- WALL BASE, REFER TO INTERIOR FINISH SCHEDULE ON SHEET A1.2.
- 2-PART WALL PANEL SYSTEM, PROVIDE TRIM AND EDGE MOLDING AROUND PERIMETER. REFER TO INTERIOR FINISH SCHEDULE ON SHEET A1.2.
- GYPSUM WALLBOARD - PAINT, REFER TO INTERIOR FINISH SCHEDULE ON SHEET A1.2.
- DOOR AND FRAME - PAINT, REFER TO "GENERAL FINISH NOTES FOR INTERIOR DOORS AND FRAMES" ON SHEET A5.1.
- WOOD TRIM - PAINT, REFER TO SECTION 2/A1.3 AND INTERIOR FINISH SCHEDULE ON SHEET A1.2.
- WALL CONSTRUCTION, REFER TO WALL TYPE FOR CONSTRUCTION.
- FIRE RETARDANT TREATED SOLID 2 X WOOD BLOCKING.
- WATER HEATER ON WALL MOUNTED SUPPORT PLATFORM, REFER TO PLUMBING DRAWINGS. PROVIDE FIRE RETARDANT TREATED SOLID WOOD BLOCKING OR ADDITIONAL COLD FORM FRAMING AS REQUIRED FOR INSTALLATION.

ACCESSORY SCHEDULE					
NO.	DESCRIPTION	MANUFACTURER	SERIES / MODEL	MOUNTING LOCATION	ACCESSORY NOTES
A	TISSUE PAPER DISPENSER	GEORGIA PACIFIC	COMPACT 56783A	REFER TO ELEVATIONS, LEGEND	OWNER FURNISHED AND INSTALLED (NIC)
B	GRAB BAR	BOBRICK	B6806 x 48"	REFER TO ELEVATIONS, LEGEND, DETAIL 15/ A4.1	
C	GRAB BAR	BOBRICK	B6806 x 18"	REFER TO ELEVATIONS, LEGEND, DETAIL 15/ A4.1	
D	GRAB BAR	BOBRICK	B6806 x 36"	REFER TO ELEVATIONS, LEGEND, DETAIL 15/ A4.1	
E	SANITARY NAPKIN RECEPTACLE	BOBRICK	B-270	REFER TO ELEVATIONS, LEGEND	WOMEN'S RESTROOM ONLY
F	SOAP DISPENSER	GOJO	PRO 2000	REFER TO ELEVATIONS, LEGEND	OWNER FURNISHED AND INSTALLED (NIC)
G	PAPER TOWEL DISPENSER (MEN)	GEORGIA PACIFIC	59460A	REFER TO ELEVATIONS, LEGEND	OWNER FURNISHED AND INSTALLED (NIC)
H	PAPER TOWEL DISPENSER (WOMEN)	GEORGIA PACIFIC	SOPULL 52409	REFER TO ELEVATIONS, LEGEND	OWNER FURNISHED AND INSTALLED (NIC)
J	MIRROR	BOBRICK	B-165-1636 18" W X 36" H	REFER TO ELEVATIONS, LEGEND	
K	MOP HANGER	REFER TO PLUMBING DRAWINGS	REFER TO PLUMBING DRAWINGS	60" A.F.F. TO CENTER	REFER TO PLUMBING DRAWINGS
L	WALL SIGN (MEN)	ROCKWOOD	BF687	REFER TO ELEVATIONS, DETAIL 13/ A4.1	WHITE TEXT ON BLACK BACKGROUND
M	WALL SIGN (WOMEN)	ROCKWOOD	BF688	REFER TO ELEVATIONS, DETAIL 13/ A4.1	WHITE TEXT ON BLACK BACKGROUND

ACCESSORY GENERAL NOTES:
CONTRACTOR TO PROVIDE FIRE RETARDANT TREATED SOLID WOOD BLOCKING FOR INSTALLATION OF RESTROOM ACCESSORIES, INCLUDING OWNER FURNISHED AND INSTALLED ACCESSORIES. COORDINATE REQUIREMENTS WITH O'REILLY'S PROJECT ADMINISTRATOR.

ACCESSORY MOUNTING LEGEND

NOTE: ALL DIMENSIONS SHOWN ARE FROM FACE OF GYPSUM WALLBOARD AND TOP OF CONCRETE FLOOR SLAB

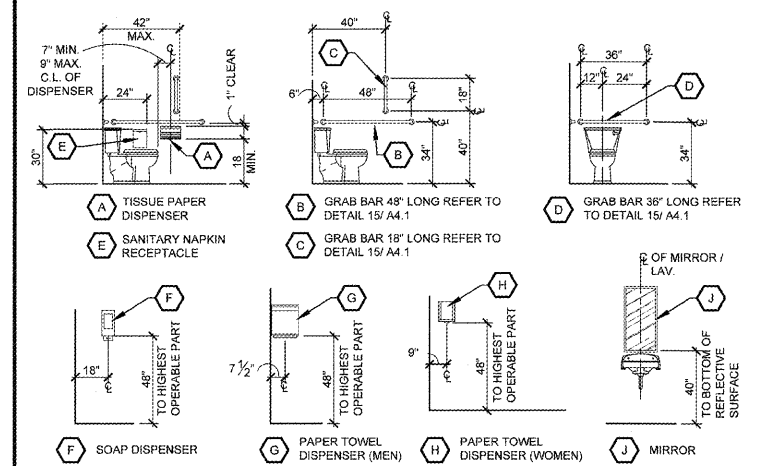

CASCO + R5
12 Sunnen Drive, Suite 100,
St. Louis, MO 63143
821.1100

REVISIONS:

O'Reilly AUTO PARTS

O'Reilly

PROJECT:
RE-MODEL O'REILLY AUTO PARTS STORE
103 E. GORDON AVE.
GORDONSVILLE, VA 22942

RESTROOM ACCESSORIES & ELEVATIONS

DRAWN: RLJ
CHECKED: MGC
DATE: 10-17-2018
JOB NO.: 118168 (GDV)
SHEET:

A4.1

COPYRIGHT 2018 - DESIGNS, DRAWINGS AND SPECIFICATIONS ARE INSTRUMENTS OF SERVICE AND ARE THE PROPERTY OF THE DESIGN PROFESSIONAL. REPRODUCTION PROHIBITED WITHOUT THE EXPRESSED WRITTEN CONSENT OF THE DESIGN PROFESSIONAL.