
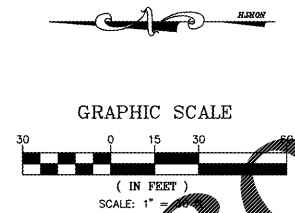


# Order Plans

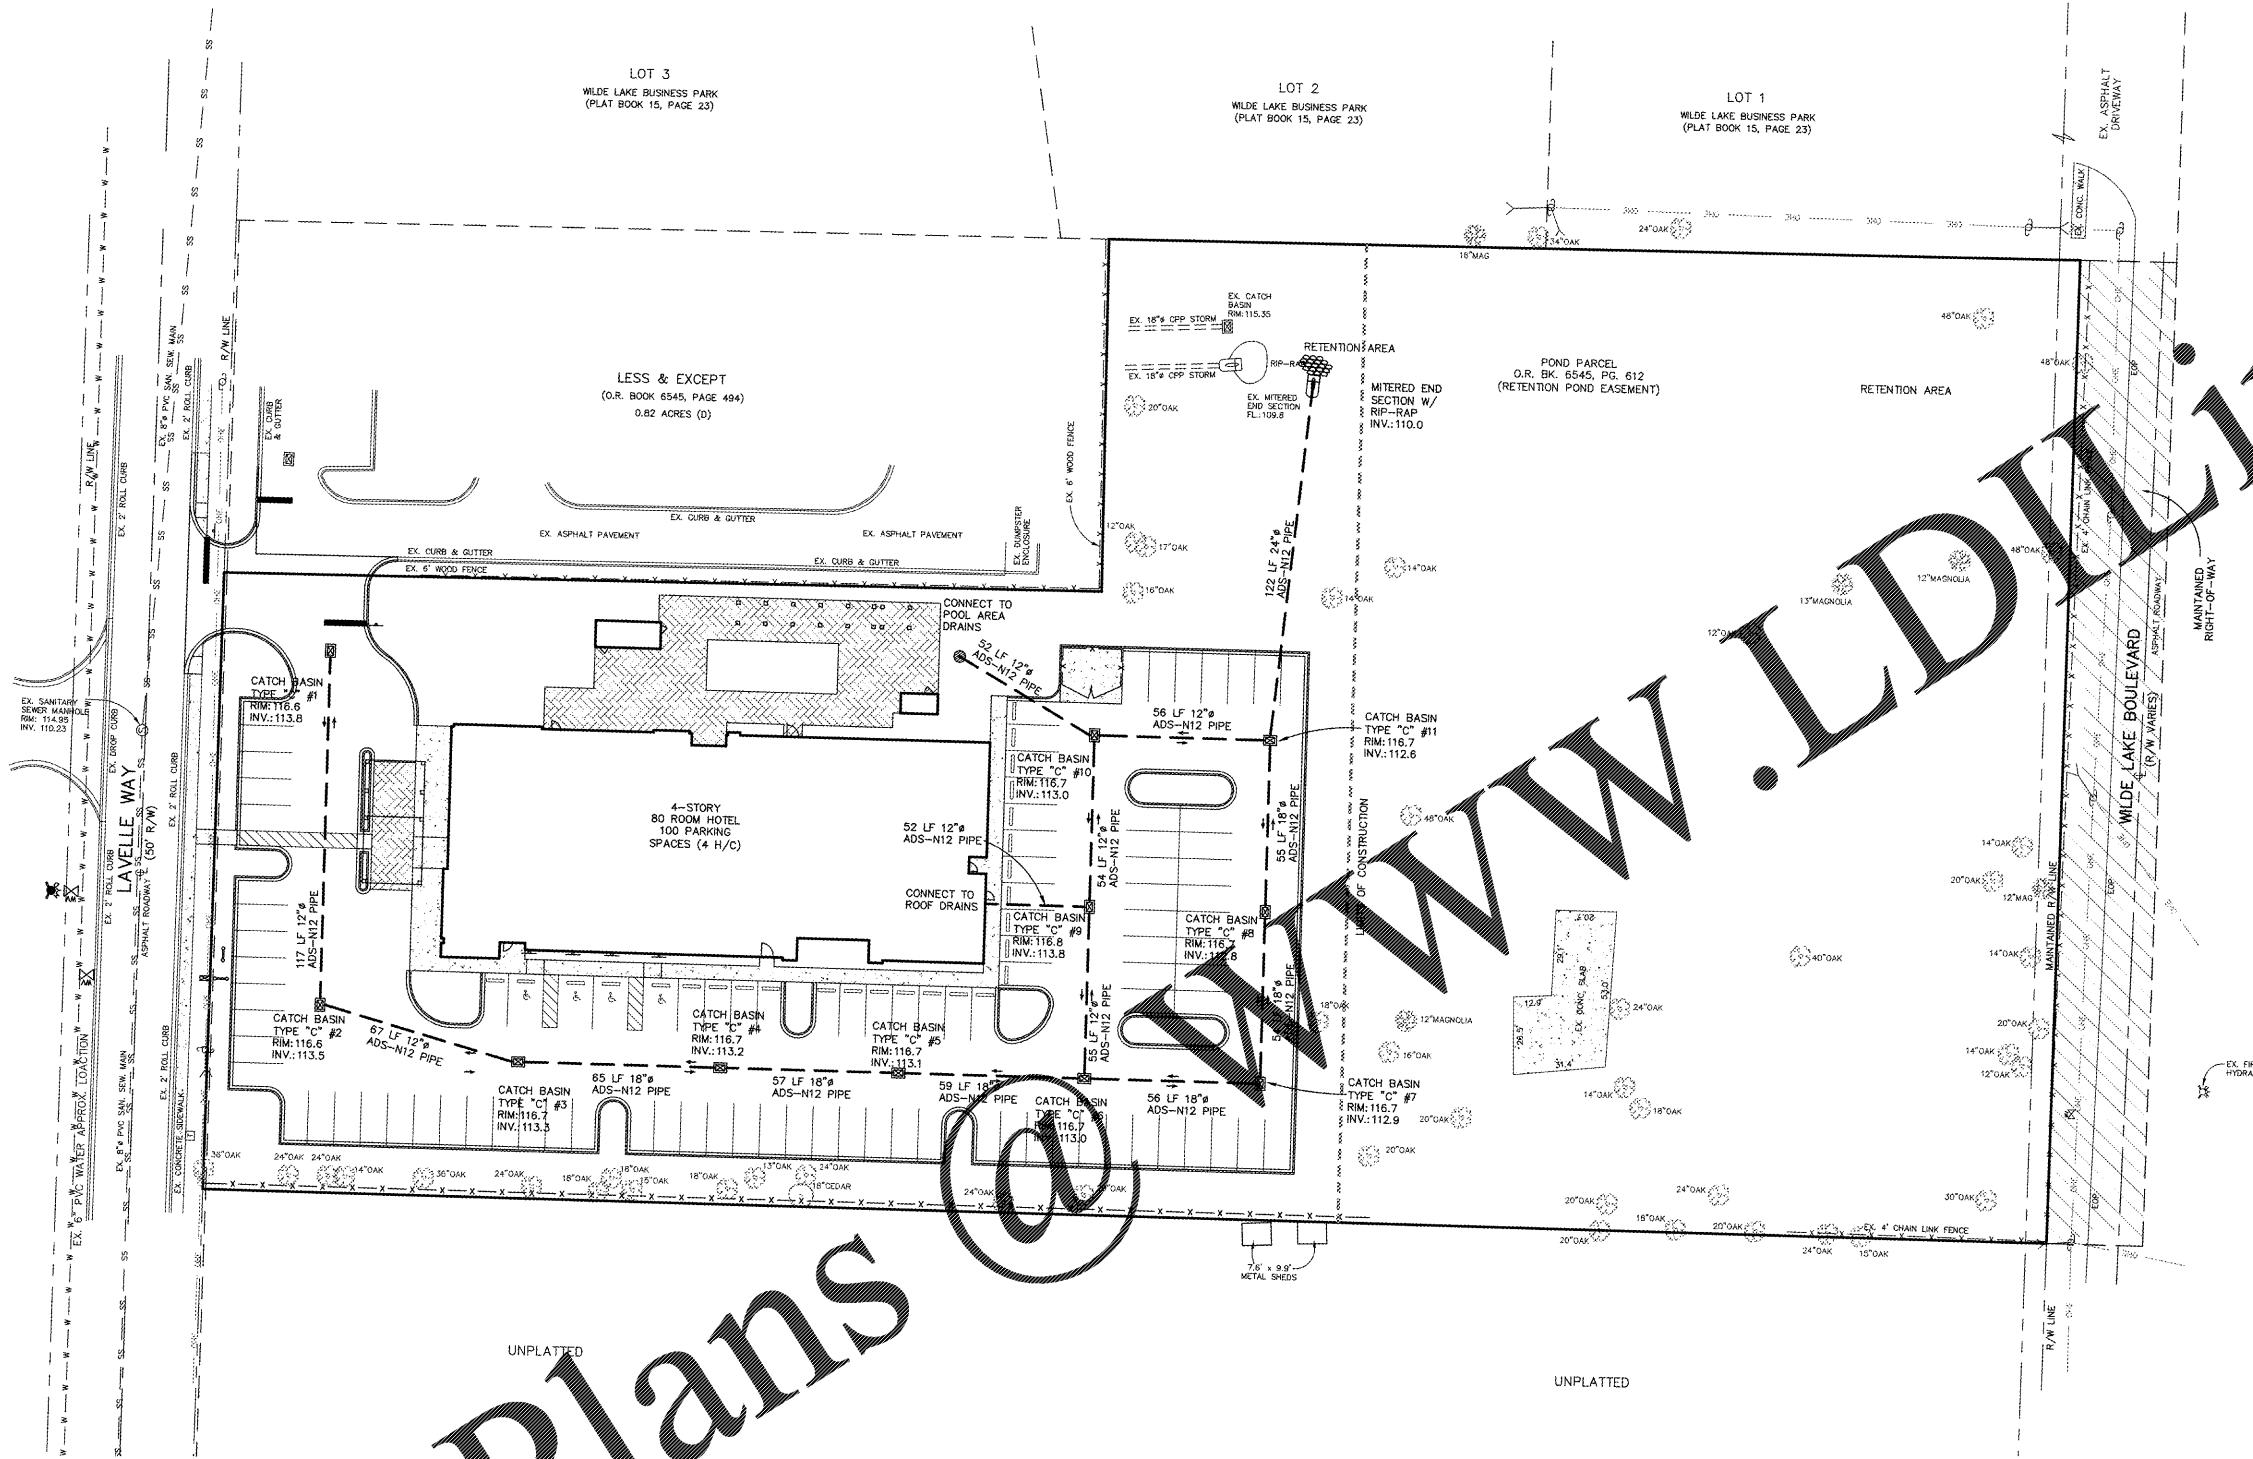

- LEGEND**
- PROPOSED STORM SEWER PIPE
  - CORRUGATED POLYETHYLENE PIPE
  - PERFORATED CORRUGATED POLYETHYLENE PIPE
  - EXISTING STORM SEWER PIPE
  - ⊗ STORM DRAIN MANHOLE
  - ⊙ CATCH BASIN
  - ⊕ TYPE "9" CURB INLET
  - ⊖ TYPE "3" CURB INLET
  - ⊗ TYPE "4" CURB INLET
  - ⊓ MITERED END SECTION

**CHOCTAW ENGINEERING, INC.**  
 ENGINEERING • ENVIRONMENTAL • SURVEYING  
 112 TRUXTON AVENUE  
 FORT WALTON BEACH, FLORIDA 32547  
 PHONE: 850-962-6611  
 FAX: 850-962-8059  
 EMAIL: ce@choctaweng.com

**CEI**

**HOME2 SUITES**  
**DRAINAGE PLAN**  
 Not valid unless bearing Engineer's embossed seal.  
 MARK C. SENER, P.E.  
 FL. REG. NO. 48831

Job No.: 2017-130-A  
 Date: 26 JUNE 2018  
 Flt. Vol.: N/A  
 Scale: 1" = 30'  
 Disk No.: 17130A-ENG  
 Designed: MCS  
 Drawn: SVD/KMB  
 Checked: MCS  
 Sheet  
**5 of 9**

THIS SHEET IS THE PROPERTY OF CEI & IS NOT TO BE REPRODUCED WITHOUT WRITTEN CONSENT FROM CEI.