


REVISIONS		
No.	Date	Description

Information contained on this drawing and in all digital files associated is authorized for use on the project named herein only and is the property of MISHRA ARCHITECTURE PLLC and may not be reproduced in any manner without express written or verbal permission from authorized individuals. Original drawing is 24"x36" and scales are as indicated. © 2008 MISHRA ARCHITECTURE PLLC

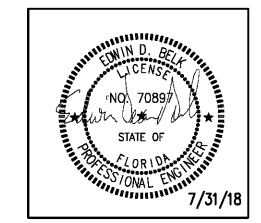

KEY PLAN

VTM Hotels, LLC

Home2Suites

2630 Wilde Lake Blvd.
Pensacola, FL 32526


Drawing Title
Fourth Floor Power Plan

Phase
Construction Documents

Project No.	17-101	Sheet No.	E204
Prepared by	MSM		
Checked by	EDB		
Date	July 31, 2018		

Review

Home2Suites

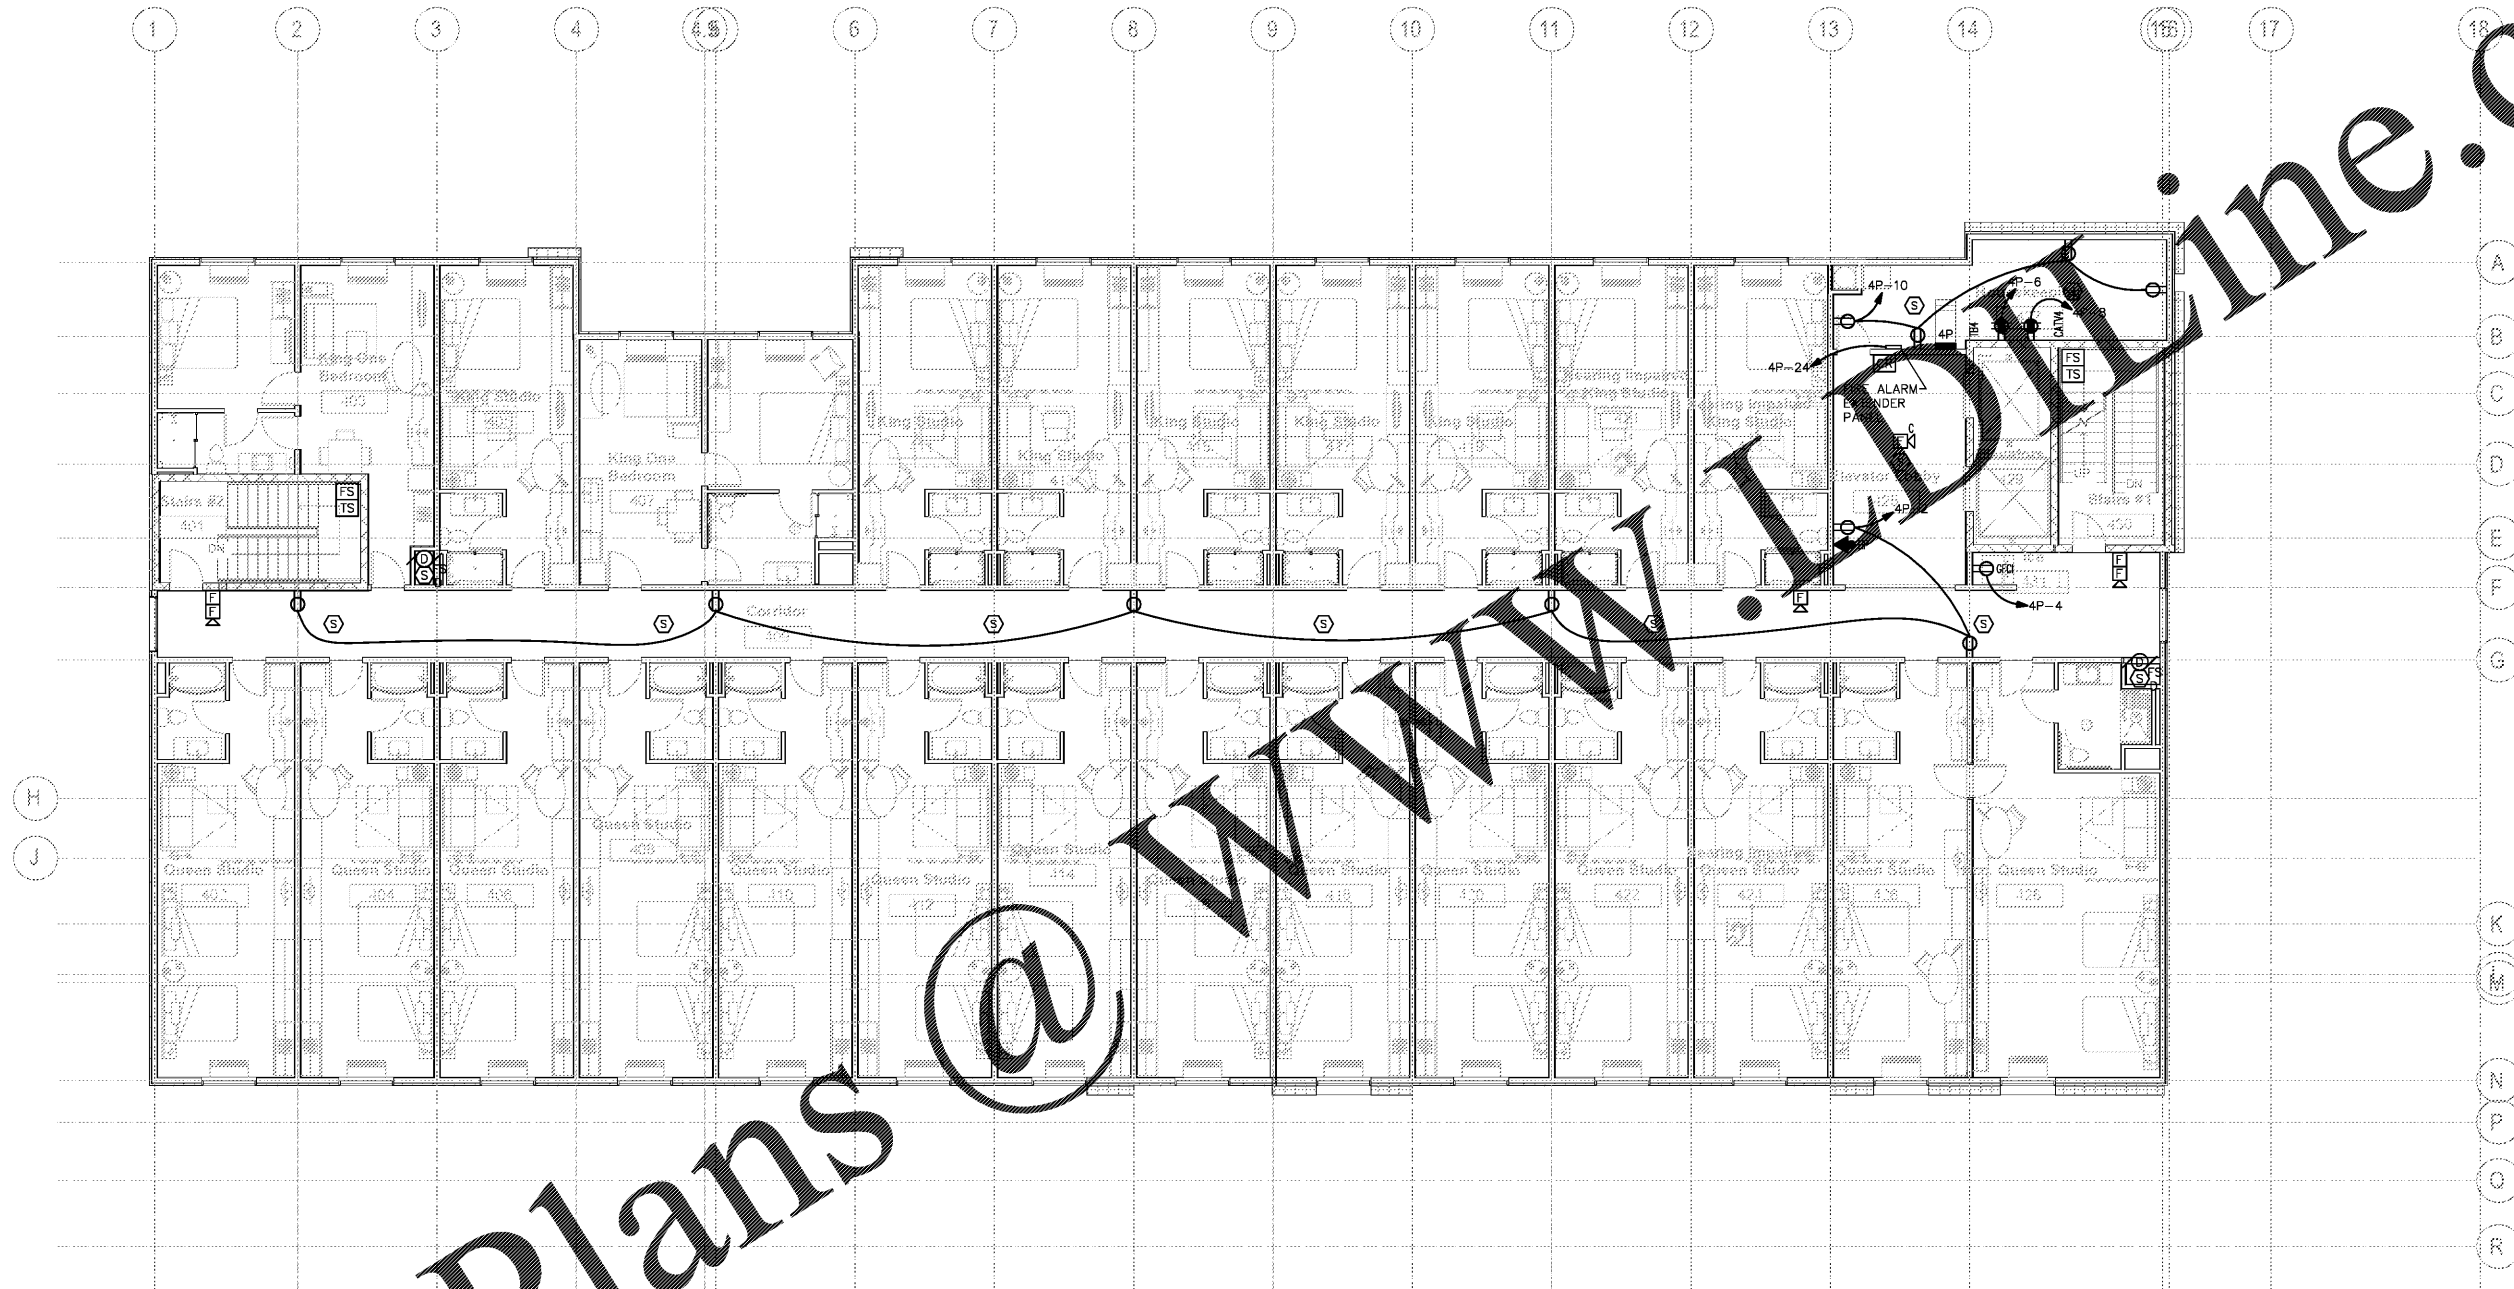

1 FOURTH FLOOR PLAN - POWER
E204 SCALE: 1/8" = 1'-0"

- NOTES:
1. CONNECT FIRE/SMOKE DAMPERS TO CIRCUIT 4P-12.
2. SEE LARGE SCALE PLANS SHEET E301 AND E302 FOR GUESTROOMS.

Order Plans