

GENERAL DEMOLITION NOTES

- GC TO PROTECT ALL ADJACENT SURFACES TO REMAIN FROM DAMAGE DURING CONSTRUCTION. GC TO REPAIR/REPLACE ANY ADJACENT SURFACES DAMAGED DURING CONSTRUCTION TO MATCH ORIGINAL CONDITIONS.
- GC TO FIELD VERIFY CONDITIONS PRIOR TO START OF CONSTRUCTION.
- EXISTING CONDITIONS & DEMOLITION NOTES BASED ON FIELD SURVEY. IF GC DISCOVERS EXISTING CONDITIONS VARY FROM THOSE SHOWN, CONTACT OWNER OR ARCHITECT IMMEDIATELY.
- GC TO PROVIDE TEMPORARY PROTECTION FROM ALL OPENINGS IN EXTERIOR WALLS. PROTECTION SHALL CONSIST OF 6 MIL PLASTIC.
- COORDINATE DEMOLITION WITH ELECTRICAL, MECHANICAL, PLUMBING, STRUCTURAL & CIVIL DRAWINGS.

DEMOLITION NOTES

- A. REMOVE EXISTING FINISH FLOOR & DISPOSE OF REEP SLAB FOR NEW FINISH.
- B. REMOVE PLUMBING FIXTURES & PARTITIONS. DEMO FLOOR DRAINS & CURBS.
- C. DEMO CEILING & CEILING GRID.
- D. DEMO CASI CURTAIN TRACK SYSTEM TO REMAIN.
- E. DEMO PLUMBING FOR RECESSED HEATER.
- F. DEMO OLD HVAC CONTROLS.
- G. DEMO COORDINATION PARTITION.
- H. DEMO EXISTING RADIATOR.
- I. DEMO EXISTING WALL.
- J. DEMO EXISTING SHELVING.
- K. DEMO GATE.
- L. REMOVE HOOKS.
- M. DEMO WINDOWS.
- N. DEMO CURBS.
- O. DEMO DOOR & HARDWARE. FRAME TO REMAIN.
- P. DEMO TICKET WINDOW AND WALL TO 34" AFF.
- Q. DEMO MOP SINK.
- R. DEMO WATER COOLER.
- S. DEMO BLEACHERS.
- T. DEMO LAUNDRY EQUIPMENT.
- U. DEMO WOOD TREADS & RISERS.
- V. DEMO CASING OPENING FRAME. CUT ONE COURSE OF HEADER BLOCK TO ACHIEVE 7'-0" MIN CLEAR HEIGHT.



THIS DRAWING IS THE PROPERTY OF DICKINSON ARCHITECTS, P.C. AND IS NOT TO BE REPRODUCED OR COPIED IN WHOLE OR IN PART OR USED FOR ANY PURPOSE WITHOUT THE EXPRESS WRITTEN CONSENT OF DICKINSON ARCHITECTS, P.C. ANY UNAUTHORIZED REPRODUCTION OF THIS DRAWING IS PROHIBITED. © 2018 DICKINSON ARCHITECTS, P.C.

PROJECT TITLE:
**MURPHEY
MIDDLE
SCHOOL P.E.
BUILDING
PROJECT #
B-17-005-3756.1**


REVISIONS			
REV #	DATE	APPROV BY	REVISION
08/15/18		NDII	STATE PRELIM.
11/02/18		NDII	STATE FINAL
11/20/18		NDII	ISSUE FOR BID



DA PROJECT NUMBER & NAME:
1707.1

DRAWING TITLE:
**DEMOLITION
PLAN - EXISTING
JOSEY GYM**

DRAWING NO:
D100

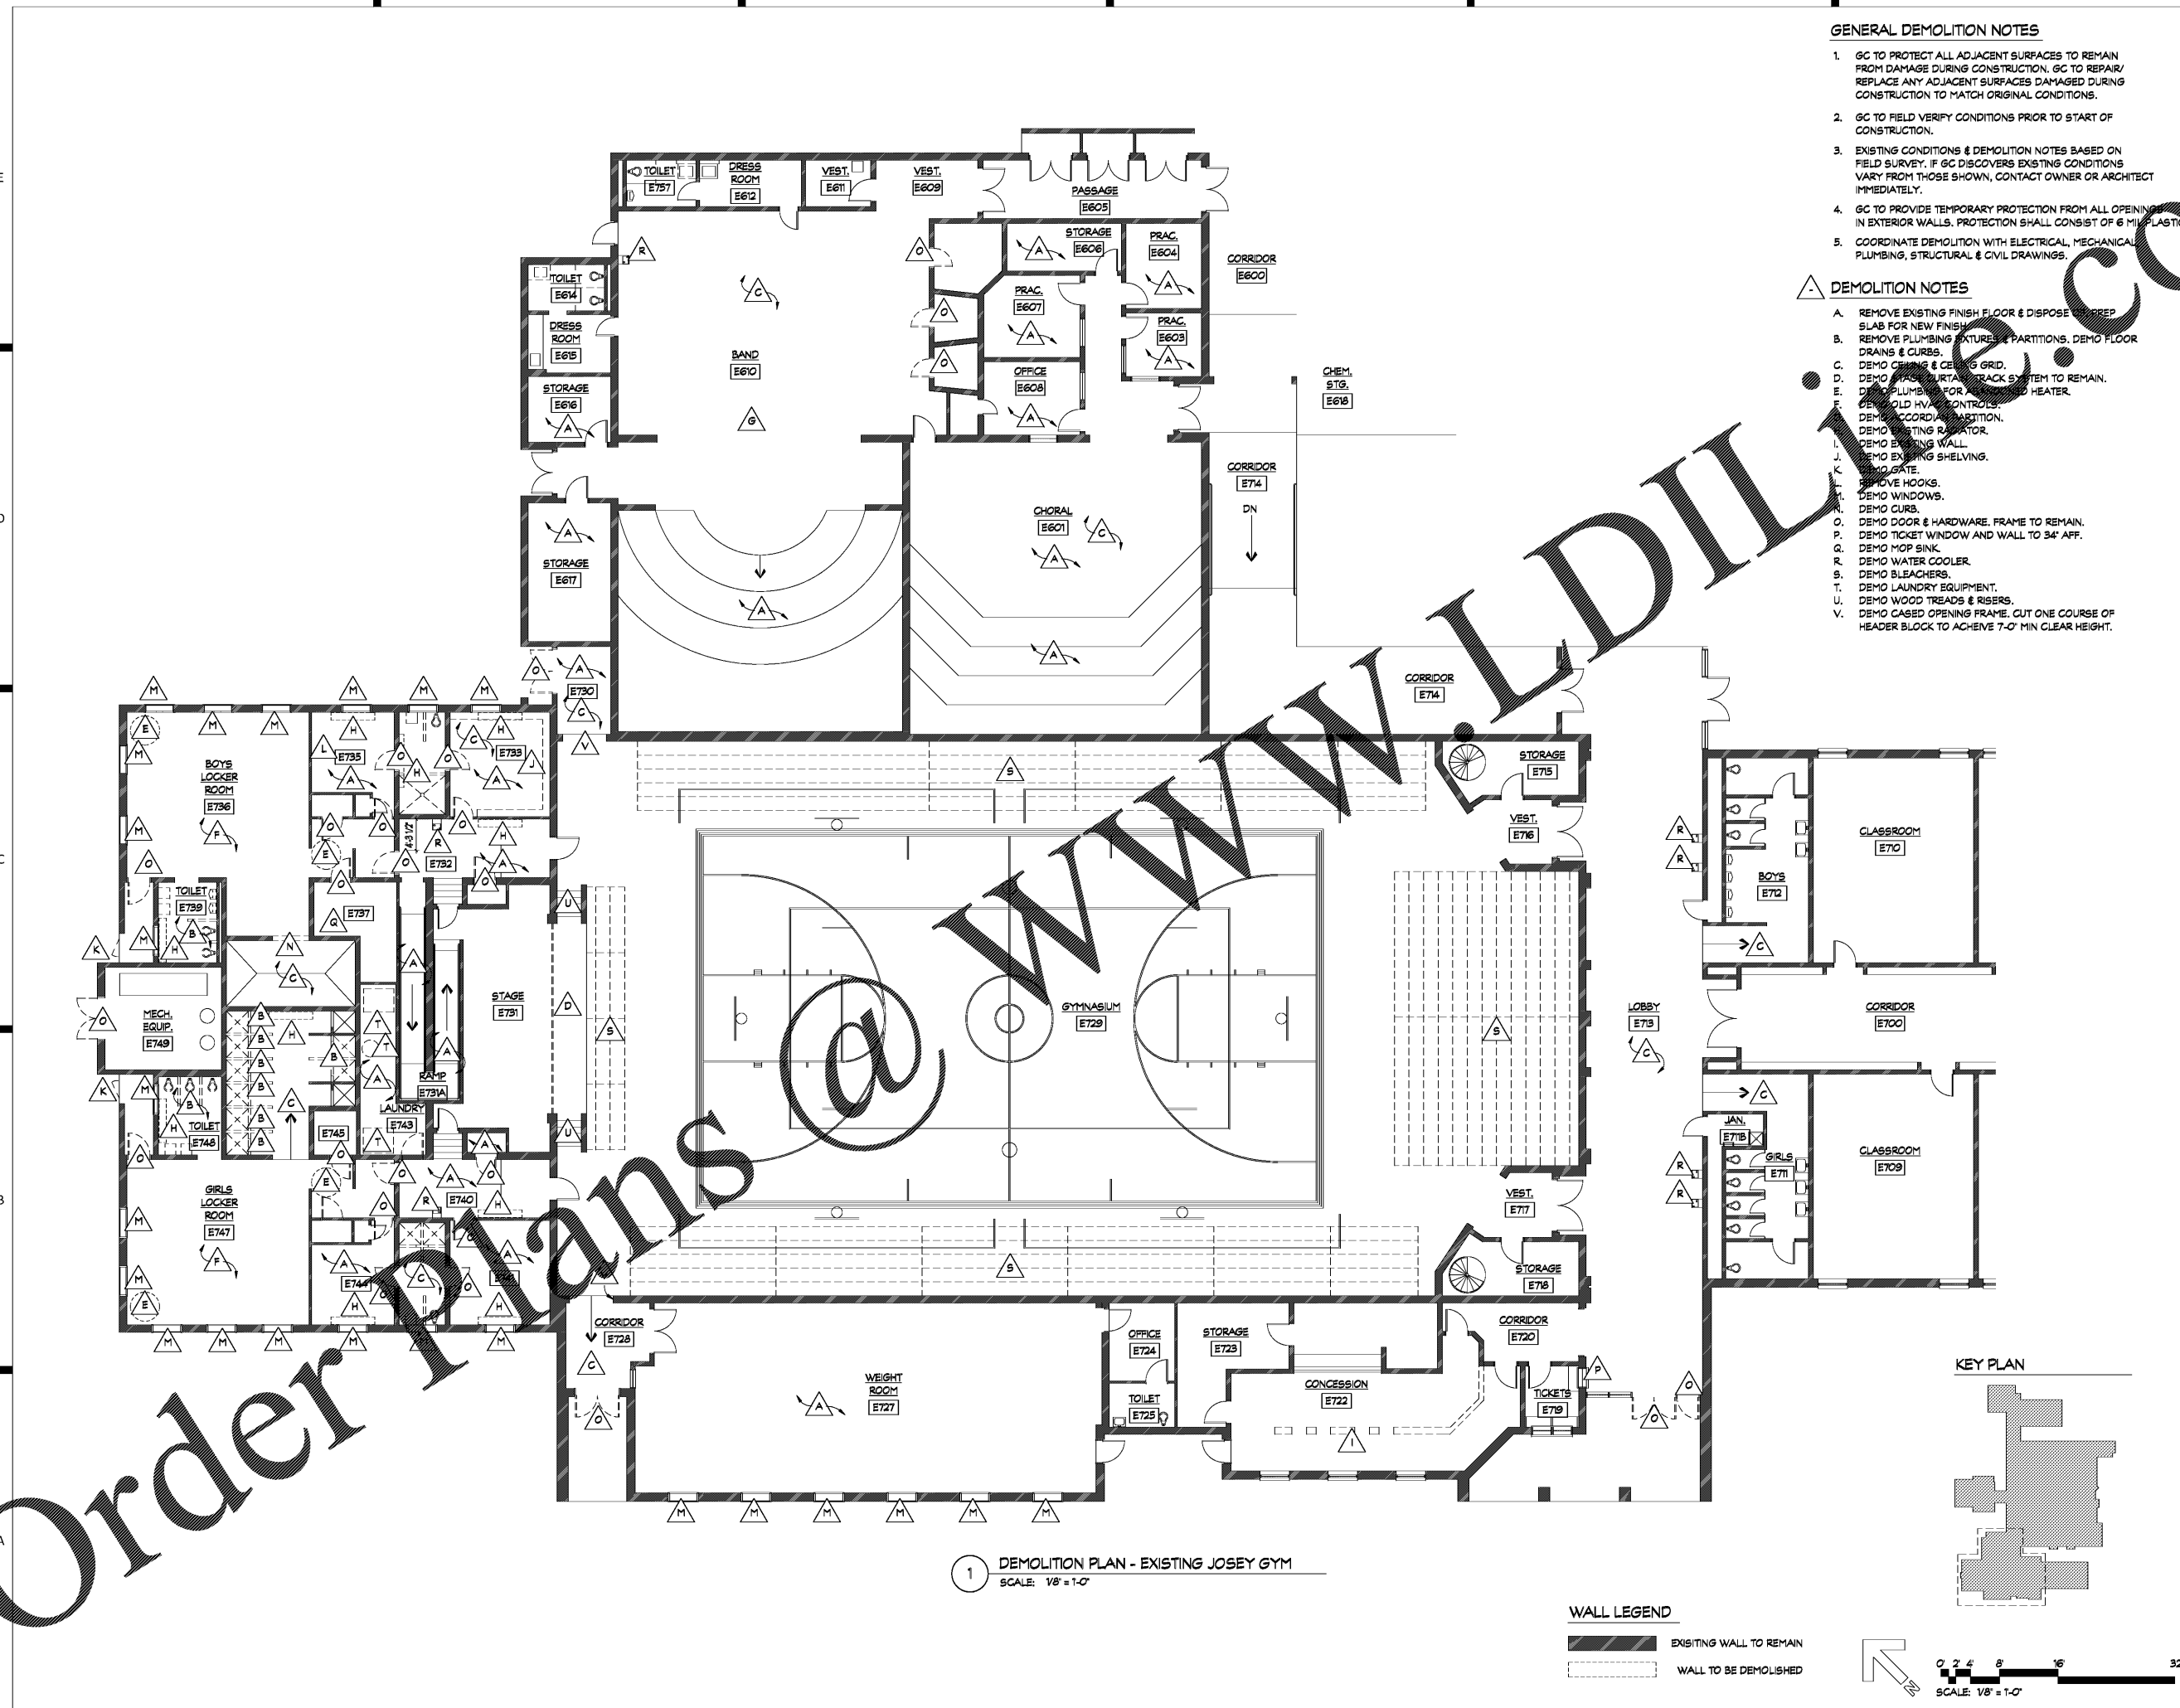


1 DEMOLITION PLAN - EXISTING JOSEY GYM
SCALE: 1/8" = 1'-0"

WALL LEGEND

EXISTING WALL TO REMAIN

 WALL TO BE DEMOLISHED



Order Plans

WWW.DI...@