



PROJECT TITLE:
**MURPHEY
MIDDLE
SCHOOL P.E.
BUILDING
PROJECT #
B-17-005-3756.1**

REV	DATE	APPROV	REVISION
1	11/02/18	JMF	STATE FINAL
2	11/20/18	JMF	ISSUE FOR BID

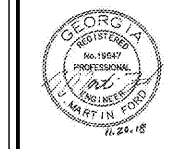


DA PROJECT NUMBER & NAME:
PROJECT NUMBER:
DRAWING TITLE:
HVAC PLANS - H.S. GYM

DRAWING NO:
M101

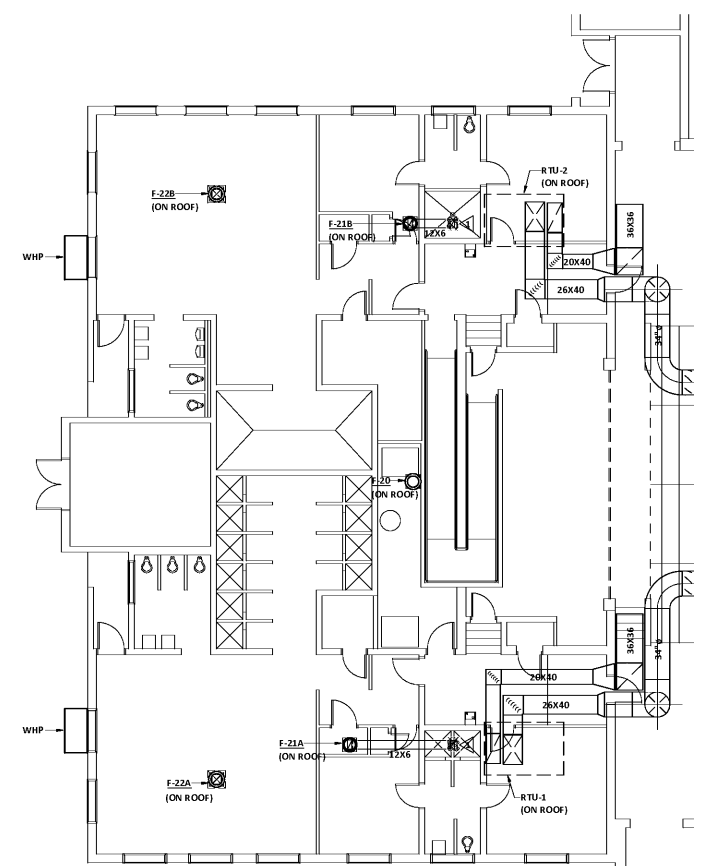

1 HVAC DEMOLITION PLAN - H.S. GYM
SCALE: 1/8" = 1'-0"

KEYNOTES (1/1/101 ONLY)
REMOVE AIR DEVICE. NEW AIR DEVICE TO BE INSTALLED IN NEW CEILING AS SHOWN ON NEW WORK PLANS.

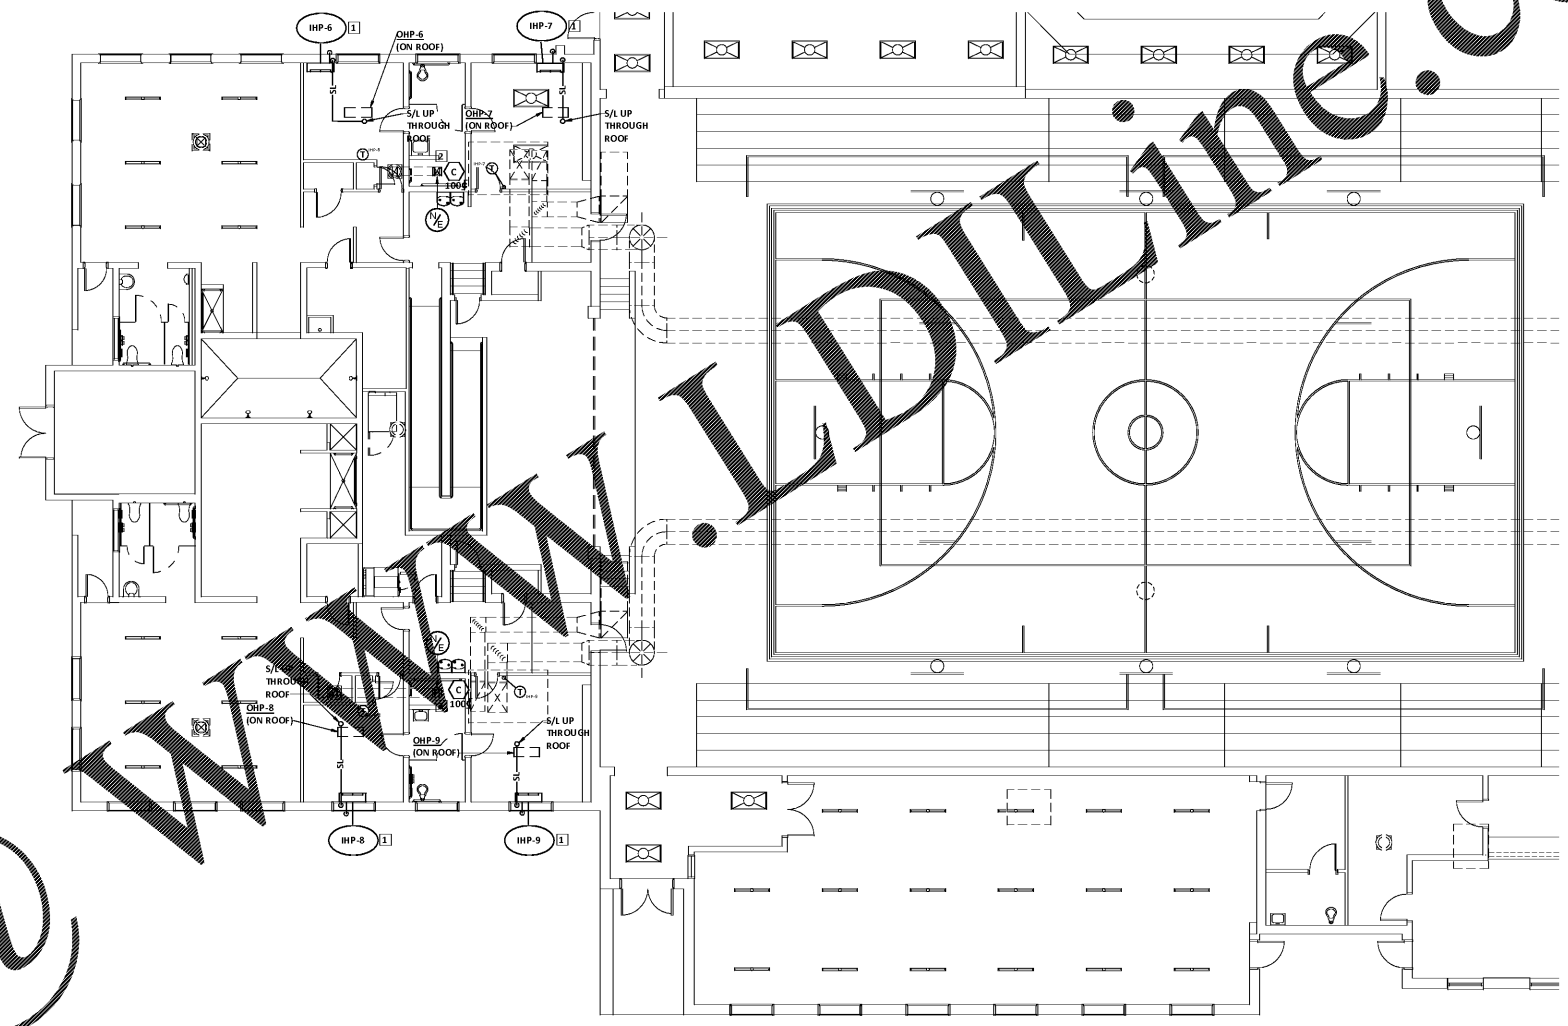

2 HVAC NEW WORK PLAN - H.S. GYM
SCALE: 1/8" = 1'-0"

KEYNOTES (2/1/101 ONLY)
[1] BOTTOM OF UNIT AT 3'-6" A.F.F. DISCHARGE CONDENSATE ON GRADE.
[2] INSTALL NEW AIR DEVICE IN NEW CEILING. CONNECT TO EXISTING EXHAUST SYSTEM AS SHOWN. BALANCE TO AIRFLOW VALUE INDICATED.



PLOT DATE: 11/02/2018
FILE NAME: 17094MECH
BASESHEET: 17094ARCH
PLOT SCALE: 1 = 96
WGC

DATE PLOTTED: 11/02/2018
PLOTTER: PLOTTER A ARCHITECTS, INC.
PLOTTER: GA 3001 (DWG 7203494)

Order Plans @