



Member of the American Institute of Architects

THIS DRAWING IS THE PROPERTY OF DICKINSON ARCHITECTS, P.C. AND IS NOT TO BE REPRODUCED OR COPIED IN WHOLE OR IN PART WITHOUT THE WRITTEN PERMISSION OF DICKINSON ARCHITECTS, P.C. ANY UNAUTHORIZED REPRODUCTION OF THIS DRAWING IS STRICTLY PROHIBITED. © DICKINSON ARCHITECTS, P.C.


PROJECT TITLE:
MURPHEY
MIDDLE
SCHOOL P.E.
BUILDING
PROJECT #
B-17-005-3756.1

REV	DATE	APPROV	REVISION
1	11/02/18	JMF	STATE FINAL
2	11/20/18	JMF	ISSUE FOR BID



DA PROJECT NUMBER & NAME:
PROJECT NUMBER
DRAWING TITLE:
HVAC ROOF PLAN
- M.S. GYM

DRAWING NO:
M104

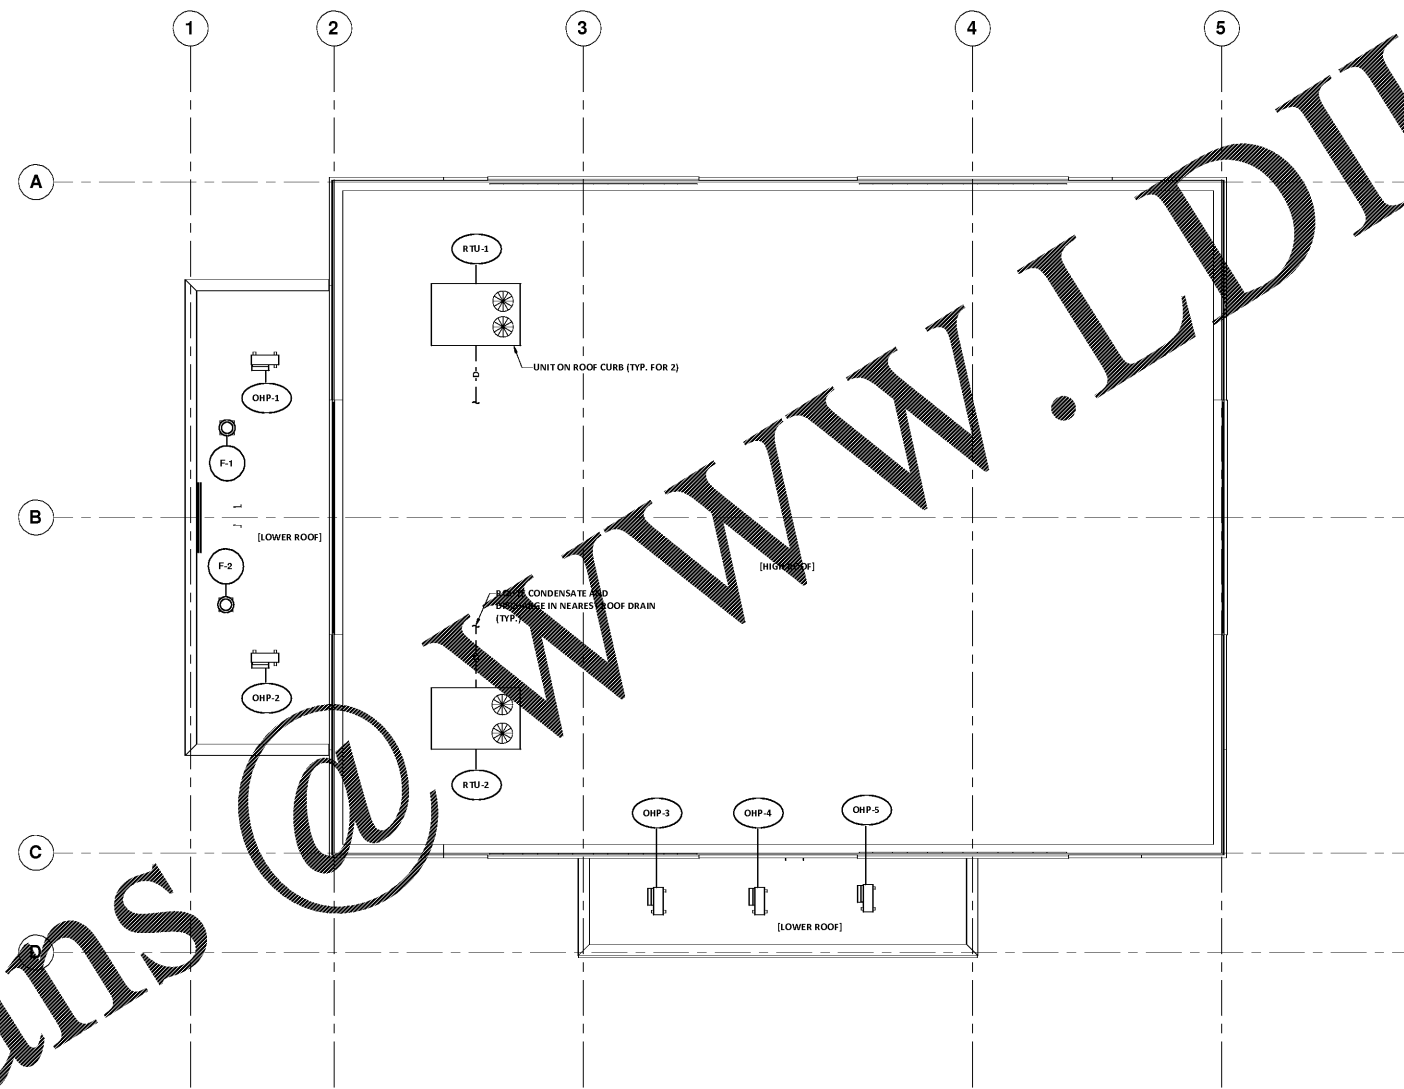

HVAC ROOF PLAN - M.S. GYM
SCALE: 1/8" = 1'-0"



PLOT DATE: 11/02/2018
FILE NAME: 17094MECH
BASESHEET: 17094ARCH
PLOT SCALE: 1 = 96
WGC

DICKINSON ARCHITECTS, P.C.
PROJECT: FORD & ASSOCIATES, INC.
MOBILE, AL 36688
INGRETT, GA 30087 (770) 792-3994

Order Plans @ www.LDILine.com