

GENERAL INFORMATION

PROVIDE WET PIPE SPRINKLER SYSTEM IN NEW GYM.
 PROVIDE SHOP DRAWINGS AND EQUIPMENT SUBMITTALS FOR REVIEW BY ENGINEER, AHJ AND OWNER.
 EXACT LOCATIONS AND ROUGHING REQUIREMENTS FOR PIPING AND EQUIPMENT SHALL BE DETERMINED FROM ARCHITECTURAL DRAWINGS, LARGE SCALE DETAILS AND APPROVED MANUFACTURER'S SHOP DRAWINGS. PARTICULAR ATTENTION SHALL BE DIRECTED TO EQUIPMENT AND FIXTURES FURNISHED UNDER OTHER DIVISIONS.
 EXACT LOCATION OF PIPING SHALL BE DETERMINED BY JOB CONDITIONS. CONTRACTOR SHALL COORDINATE THE INSTALLATION OF HIS WORK WITH THAT OF OTHER TRADES AND ARRANGE PIPING TO CLEAR STRUCTURAL MEMBERS AND DUCTWORK.
 IN FIRE WALLS, PACK ANNUAL SPACE BETWEEN PIPE AND WALL WITH FIRESTOP COMPOUND IN ACCORDANCE WITH ITS U.L. LISTING.
 PROVIDE QUICK-RESPONSE (Q.R.) WHITE RECESSED SPRINKLERS IN AREAS WITH FINISHED CEILINGS.
 PROVIDE BRASS UPRIGHT SPRINKLERS IN AREAS WITHOUT CEILINGS. PROVIDE PROTECTIVE CAGES WHERE SPRINKLERS COULD BE SUBJECTED TO DAMAGE.


HAZARD CLASSIFICATION

ALL AREAS SHALL BE REGARDED AS LIGHT HAZARD UNLESS NOTED OTHERWISE.


01 ORDINARY HAZARD-GROUP

LOW TEST DATA

DATE: 06-24-2017
 TEST PRESSURE: 29 PSI
 RESTRICTION PRESSURE: 60 PSI
 FLOW RATE: 984 GPM
 CONDUIT BY: AUGUSTA UTILITIES DEPT.
 TEST LOCATION: 20" WATER MAIN ALONG ESSIE MCINTYRE ROAD NEAR T.W. JOSEY H.S. GYM

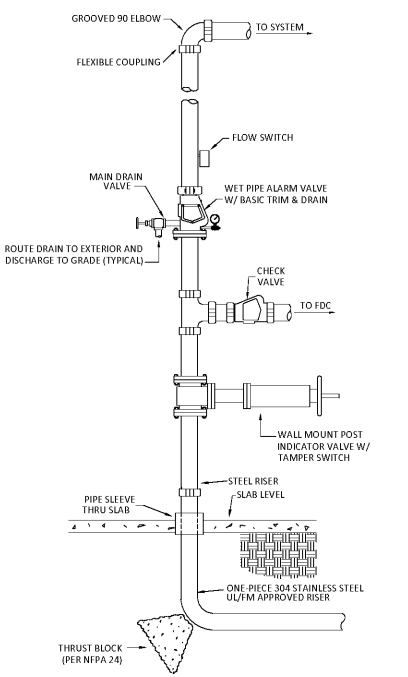

3 FIRE SPRINKLER RISER
 NOT TO SCALE

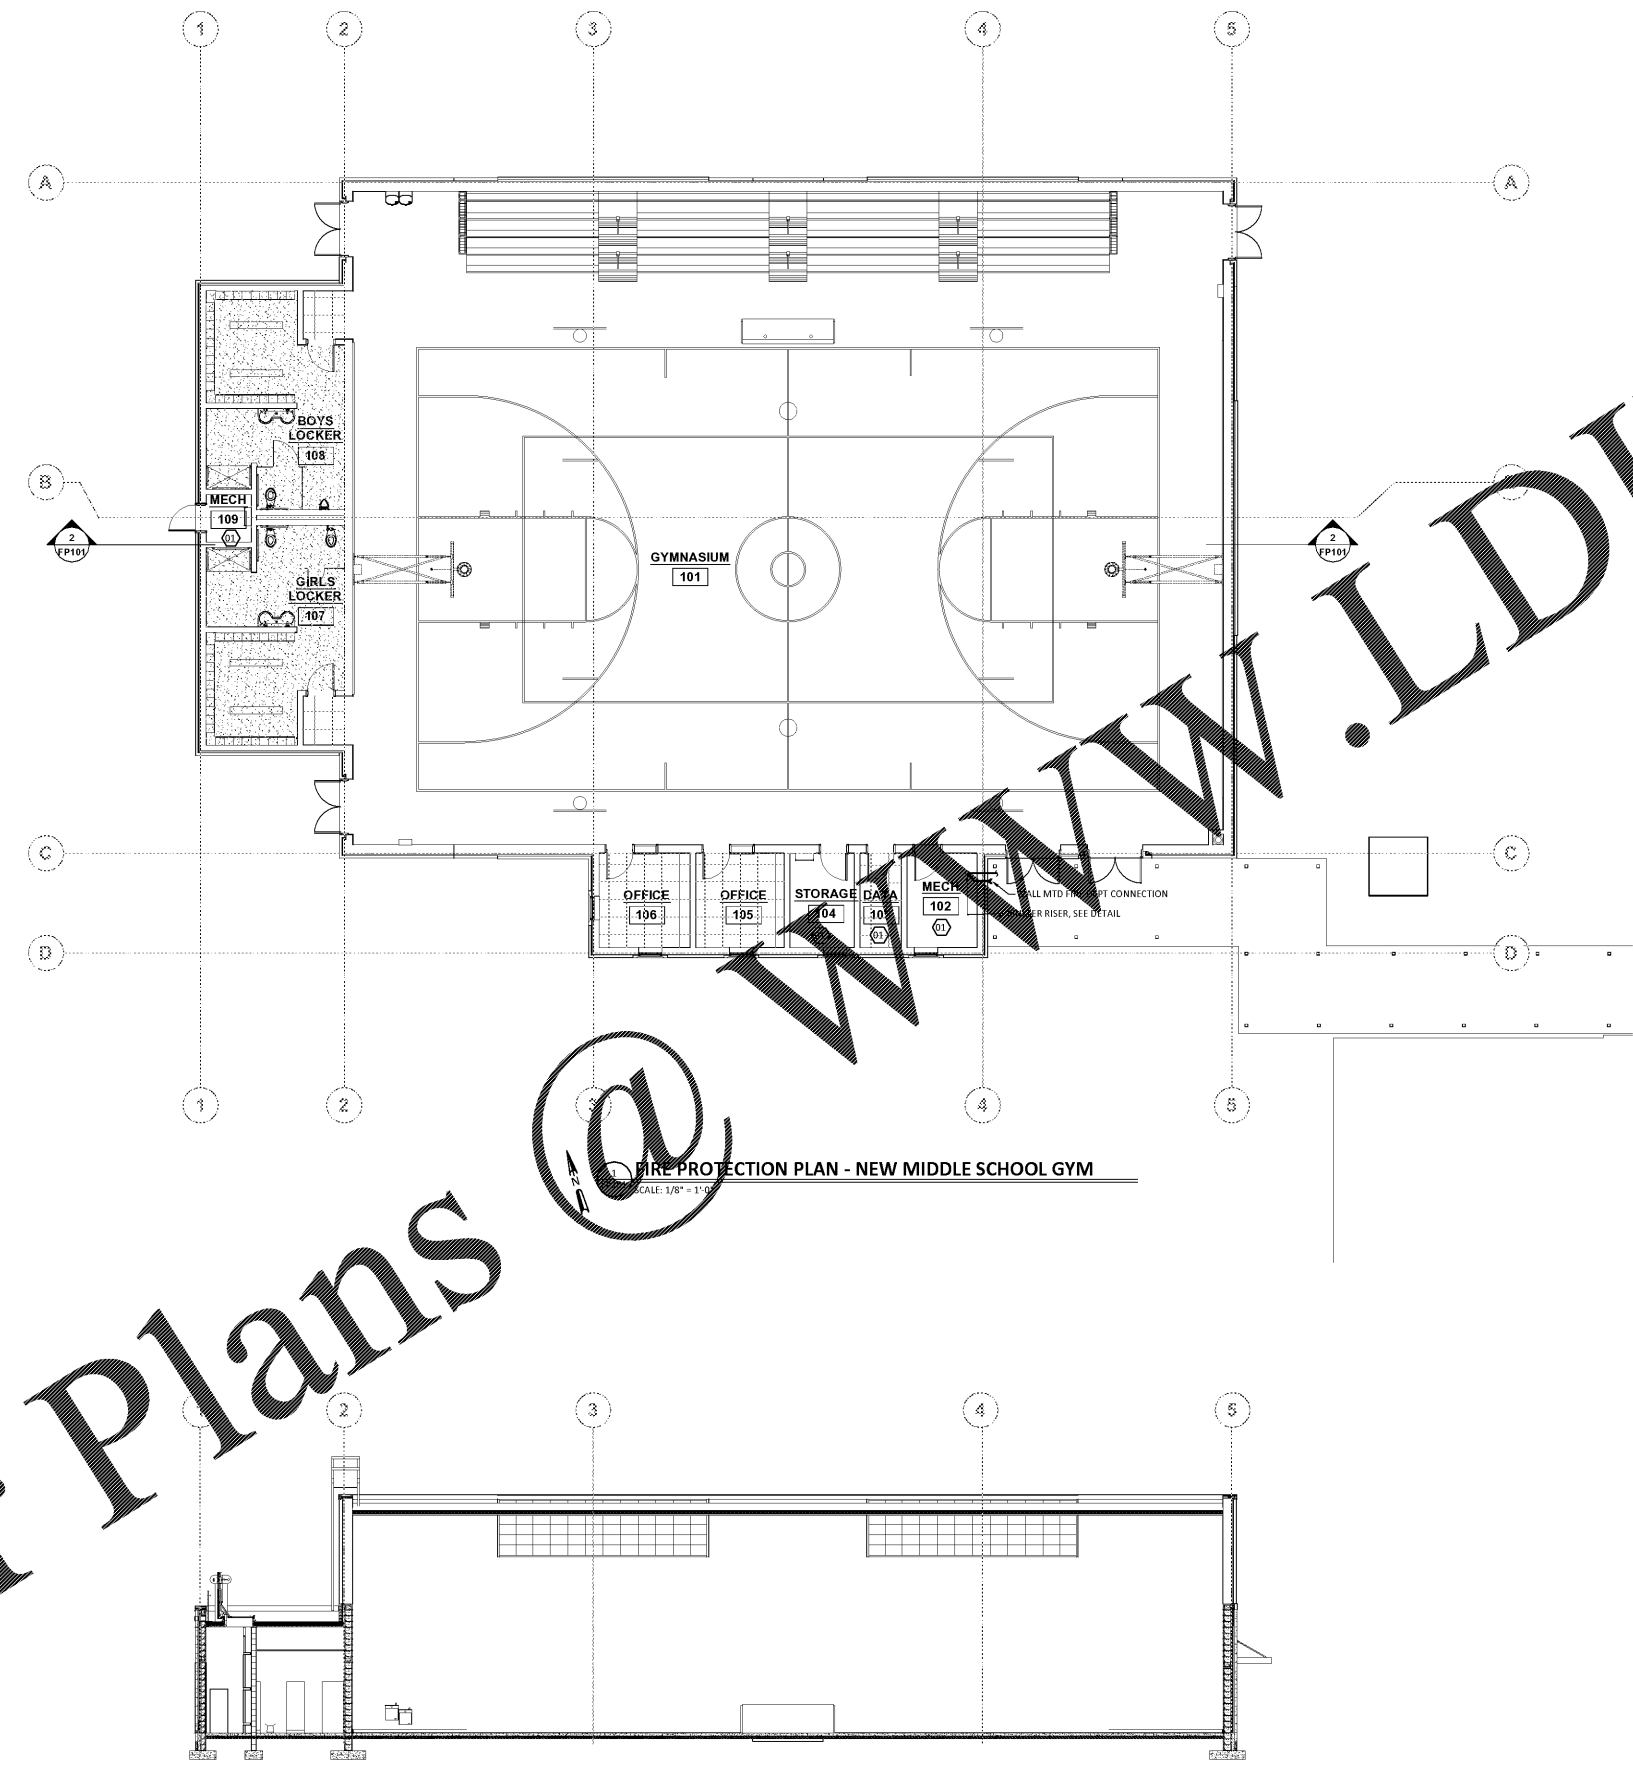

7 BUILDING SECTION
 NOT TO SCALE

dickinson
 ARCHITECTS
 Architecture/Interior/Planning
 771 Broad Street Suite
 Augusta, Georgia 30901
 (706) 725-7488
 www.dickinsonarchitects.com
 www.dickinsonarchitects.com

Member of the
 American Institute of
 Architects

THIS DRAWING IS THE PROPERTY OF DICKINSON ARCHITECTS, P.C. AND IS NOT TO BE REPRODUCED, COPIED, OR TRANSMITTED IN ANY FORM OR BY ANY MEANS, ELECTRONIC OR MECHANICAL, INCLUDING PHOTOCOPYING, RECORDING, OR BY ANY INFORMATION STORAGE AND RETRIEVAL SYSTEM, WITHOUT THE WRITTEN PERMISSION OF DICKINSON ARCHITECTS, P.C. AND IS TO BE RETURNED UPON REQUEST.

PROJECT TITLE:
**MURPHEY
 MIDDLE
 SCHOOL P.E.
 BUILDING**
 PROJECT #
B-17-005-3756.1

REVISIONS			
REV #	DATE	APPROVED BY	REVISION
1	11/27/18	JMF	STATE FINAL
2	11/20/18	JMF	ISSUE FOR BID



DA PROJECT NUMBER & NAME:
 1707.1

DRAWING TITLE:
**FIRE PROTECTION
 PLAN - NEW
 MIDDLE SCHOOL
 GYM**

DRAWING NO:
FP101

Order Plans

WWW.LDILINE.COM