



dickinson
ARCHITECTS
Architecture Interior Design Planning
771 Broad Street, Suite 200
Atlanta, Georgia 30309
404.227.7488
m.dickinson@dickinsonarchitects.com
www.dickinsonarchitects.com

Member of the
American Institute of
Architects

THIS DRAWING IS THE PROPERTY OF DICKINSON ARCHITECTS, P.C. AND IS NOT TO BE REPRODUCED OR COPIED IN WHOLE OR IN PART WITHOUT THE WRITTEN PERMISSION OF DICKINSON ARCHITECTS, P.C. ANY OTHER REPRODUCTION OF THIS DRAWING WITHOUT THE WRITTEN PERMISSION OF DICKINSON ARCHITECTS, P.C. IS PROHIBITED.



PROJECT TITLE:
**MURPHEY
MIDDLE
SCHOOL P.E.
BUILDING
PROJECT #
B-17-005-3756.1**

REV #	DATE	APPROV BY	REVISION
1	11/02/18	JMF	STATE FINAL
2	11/20/18	JMF	ISSUE FOR BID



DA PROJECT NUMBER & NAME:
PROJECT NUMBER
DRAWING TITLE:
**PLUMBING PLAN
MIDDLE SCHOOL
GYM**

DRAWING NO:
P101

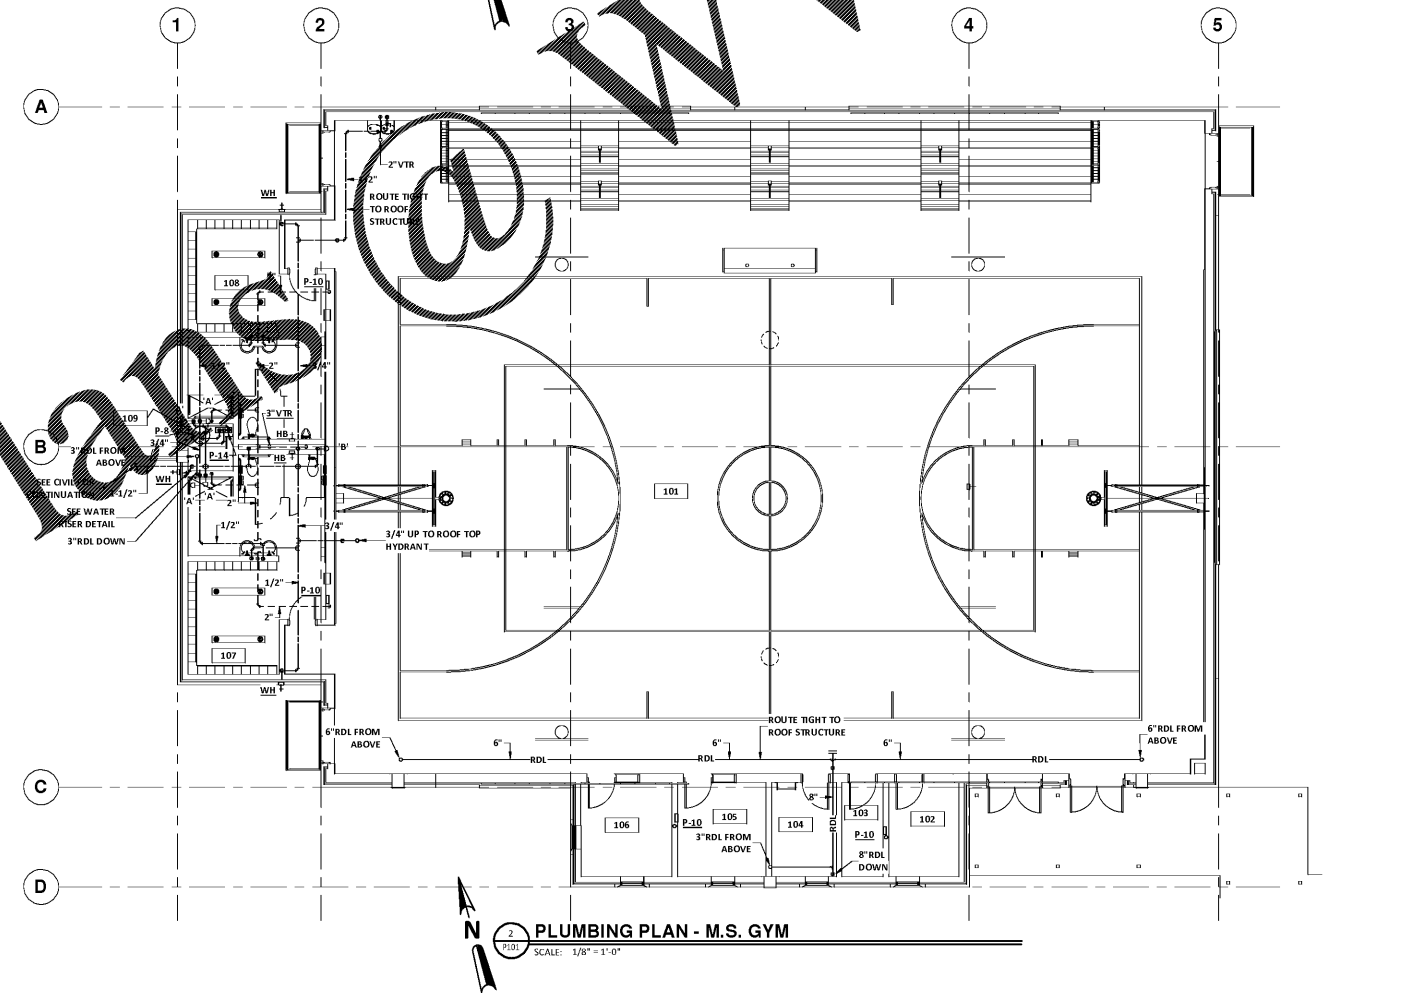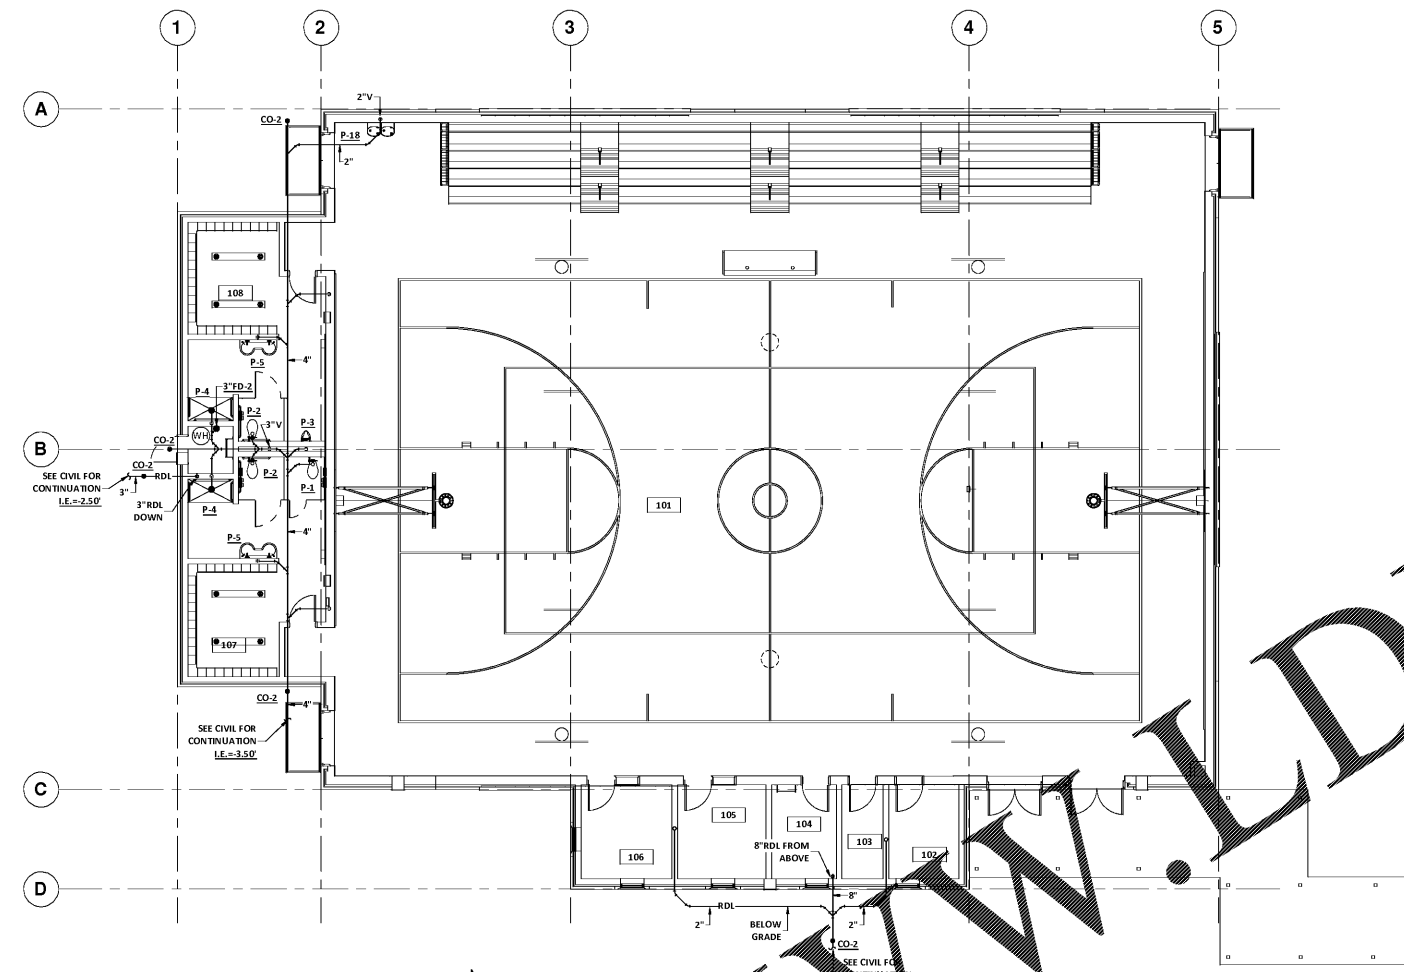

1" = 10' REFERENCE SCALE
PLOT DATE: 11/02/2018
FILE NAME: 17094MECH
BASESHEET: 17094MECH
PLOT SCALE: 1" = 96"
RWW

CONTRACT: B-17-005-3756.1
PROJECT: MURPHEY MIDDLE SCHOOL P.E. BUILDING
ARCHITECT: DICKINSON ARCHITECTS, P.C.
PLUMBER: R. W. WATSON, P.E.
DATE: 11/02/2018

Order Plans

WWW.LDILine.com