




Member of the American Institute of Architects

THIS DRAWING IS THE PROPERTY OF DICKINSON ARCHITECTS, P.C. AND IS NOT TO BE REPRODUCED OR COPIED IN WHOLE OR IN PART OR USED FOR ANY OTHER PURPOSE WITHOUT THE WRITTEN CONSENT OF DICKINSON ARCHITECTS, P.C.


PROJECT TITLE:
MURPHEY
MIDDLE
SCHOOL P.E.
BUILDING
PROJECT #
B-17-005-3756.1

REV #	DATE	APPROV BY	REVISION
1	11/02/18	JMF	STATE FINAL
2	11/20/18	JMF	ISSUE FOR BID

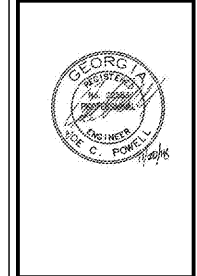

DA PROJECT NUMBER & NAME:
PROJECT NUMBER
DRAWING TITLE:
PLUMBING ROOF PLAN - MIDDLE SCHOOL GYM

DRAWING NO:
P102

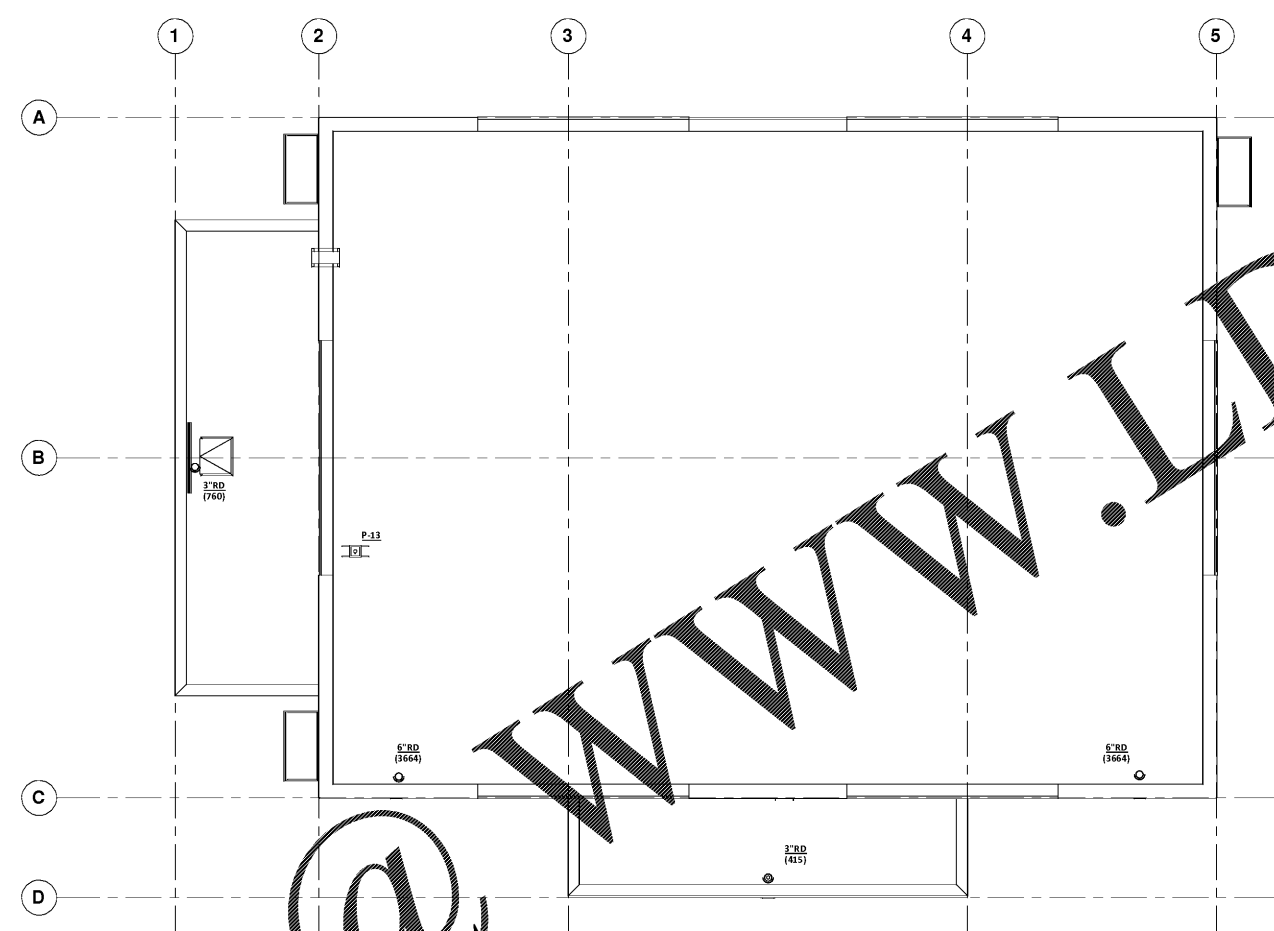

PLUMBING ROOF PLAN - M.S.
SCALE: 1/8" = 1'-0"



Order Plans @

WWW.LDILine.com