




THIS DRAWING IS THE PROPERTY OF DICKINSON ARCHITECTS, P.C. AND IS NOT TO BE REPRODUCED OR COPIED IN WHOLE OR IN PART OR FOR ANY PURPOSES WITHOUT THE WRITTEN PERMISSION OF DICKINSON ARCHITECTS, P.C. ANY REPRODUCTION OF THIS DRAWING WITHOUT THE WRITTEN PERMISSION OF DICKINSON ARCHITECTS, P.C. MAY BE SUBJECT TO LEGAL ACTION.

PROJECT TITLE:
**MURPHEY
MIDDLE
SCHOOL P.E.
BUILDING
PROJECT #
B-17-005-3756.1**

REVISIONS			
REV #	DATE	APPRD BY	REVISION
1	11/02/18	MAP	STATE FINAL
2	11/20/18	MAP	ISSUE FOR BID

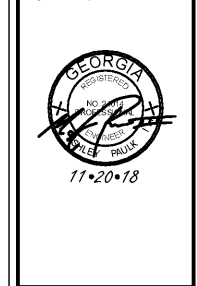

DA PROJECT NUMBER & NAME:
1707.1

 
DRAWING TITLE:
**FIRE ALARM AND
INTERCOM
SYSTEM PLAN**

DRAWING NO:
E401

DA PROJECT NUMBER & NAME:
1707.1

DRAWING TITLE:
**FIRE ALARM AND
INTERCOM
SYSTEM PLAN**

DRAWING NO:
E401



ATTIC STOCK:


- 2 UNITS
- ⊗ 3 UNITS
- ⊗ 4 UNITS
- ⊗ 5 UNITS
- ⊗ 6 UNITS
- ⊗ 7 UNITS
- ⊗ 8 UNITS

GENERAL NOTES:

1. CONNECT ALL FIRE ALARM DEVICES ON THIS SHEET TO NEW FIRE ALARM CONTROL PANEL LOCATED IN DATA 103.
2. CONNECT ALL INTERCOM DEVICES ON THIS SHEET TO NEW INTERCOM NOISE LOCATED IN DATA 103. RACK MOUNT INTERCOM NOISE IN DATA RACK.
3. NUMBER BY SPEAKER DESIGNATES CALLING ZONE.

KEYED NOTES:

1. PROVIDE CONTROL MODULE TO SHUNT OFF POWER TO LOCAL SOUND UPON FIRE ALARM ACTIVATION.
2. LOCATE 4'-10" ABOVE TOP OF BLEACHER.
3. ATLAS SOUDOLIER #PVT CALL STATION WITH MONITOR SPEAKER.
4. CEILING FINISH IN THIS AREA IS EXPOSED STRUCTURE. ALL SPEAKERS SHALL BE SURFACE MOUNT TYPE IN SURFACE ENCLOSURES. ALL CABLING IN THIS AREA SHALL BE IN CONDUIT. SEE LIGHTING PLAN FOR CEILING TYPE.

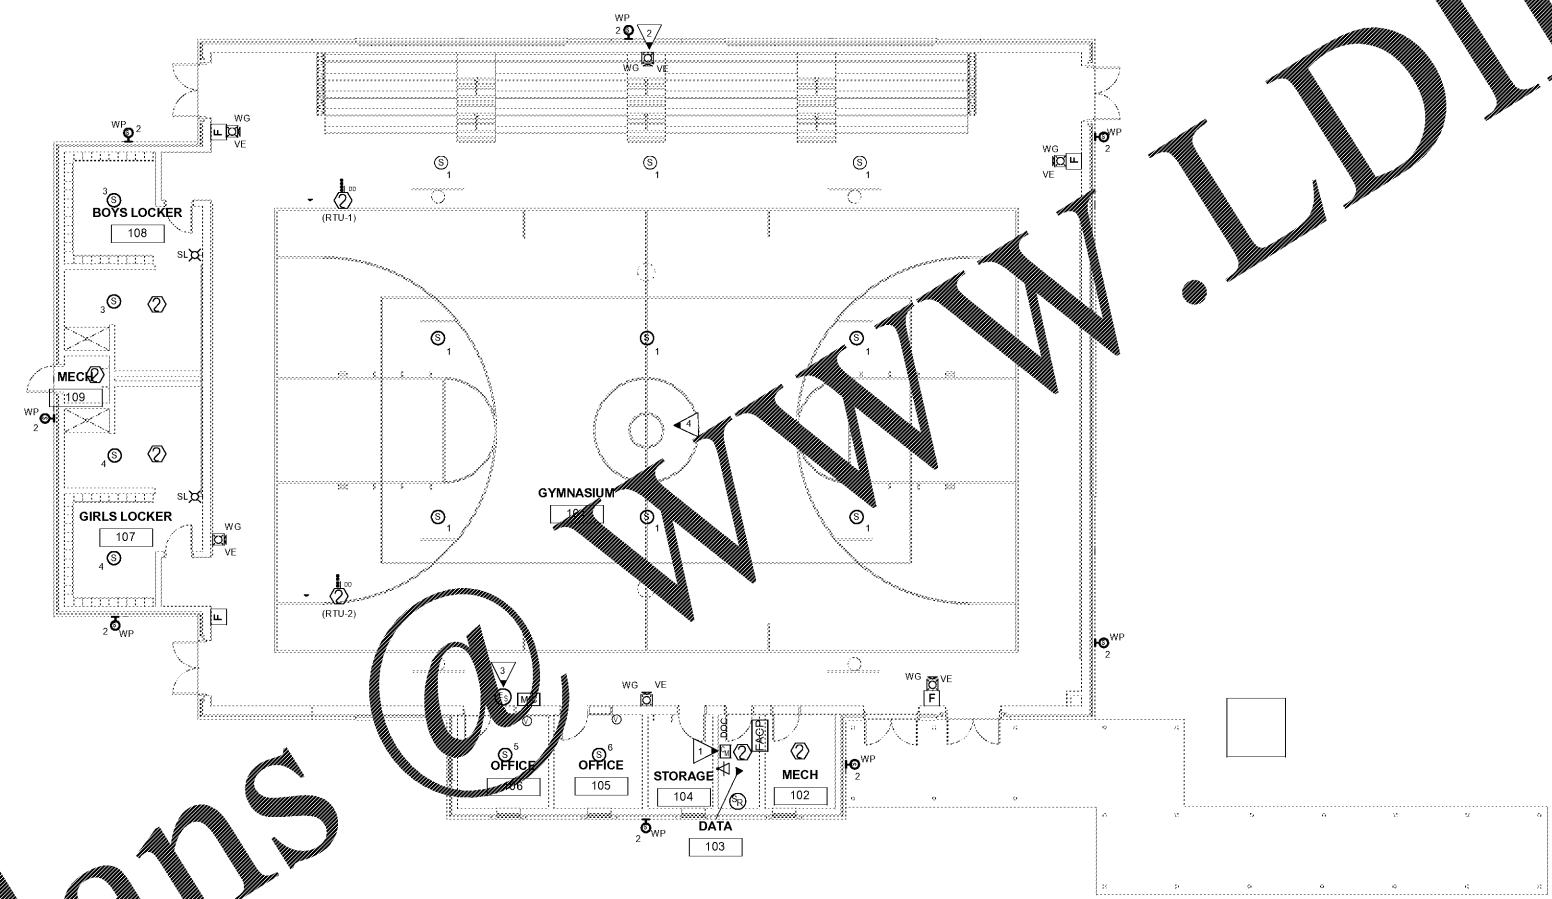

1 FIRE ALARM AND INTERCOM SYSTEM PLAN
E401 SCALE: 1/8" = 1'-0"

Order Plans