


Order Plans

WWW.LDLINE.COM

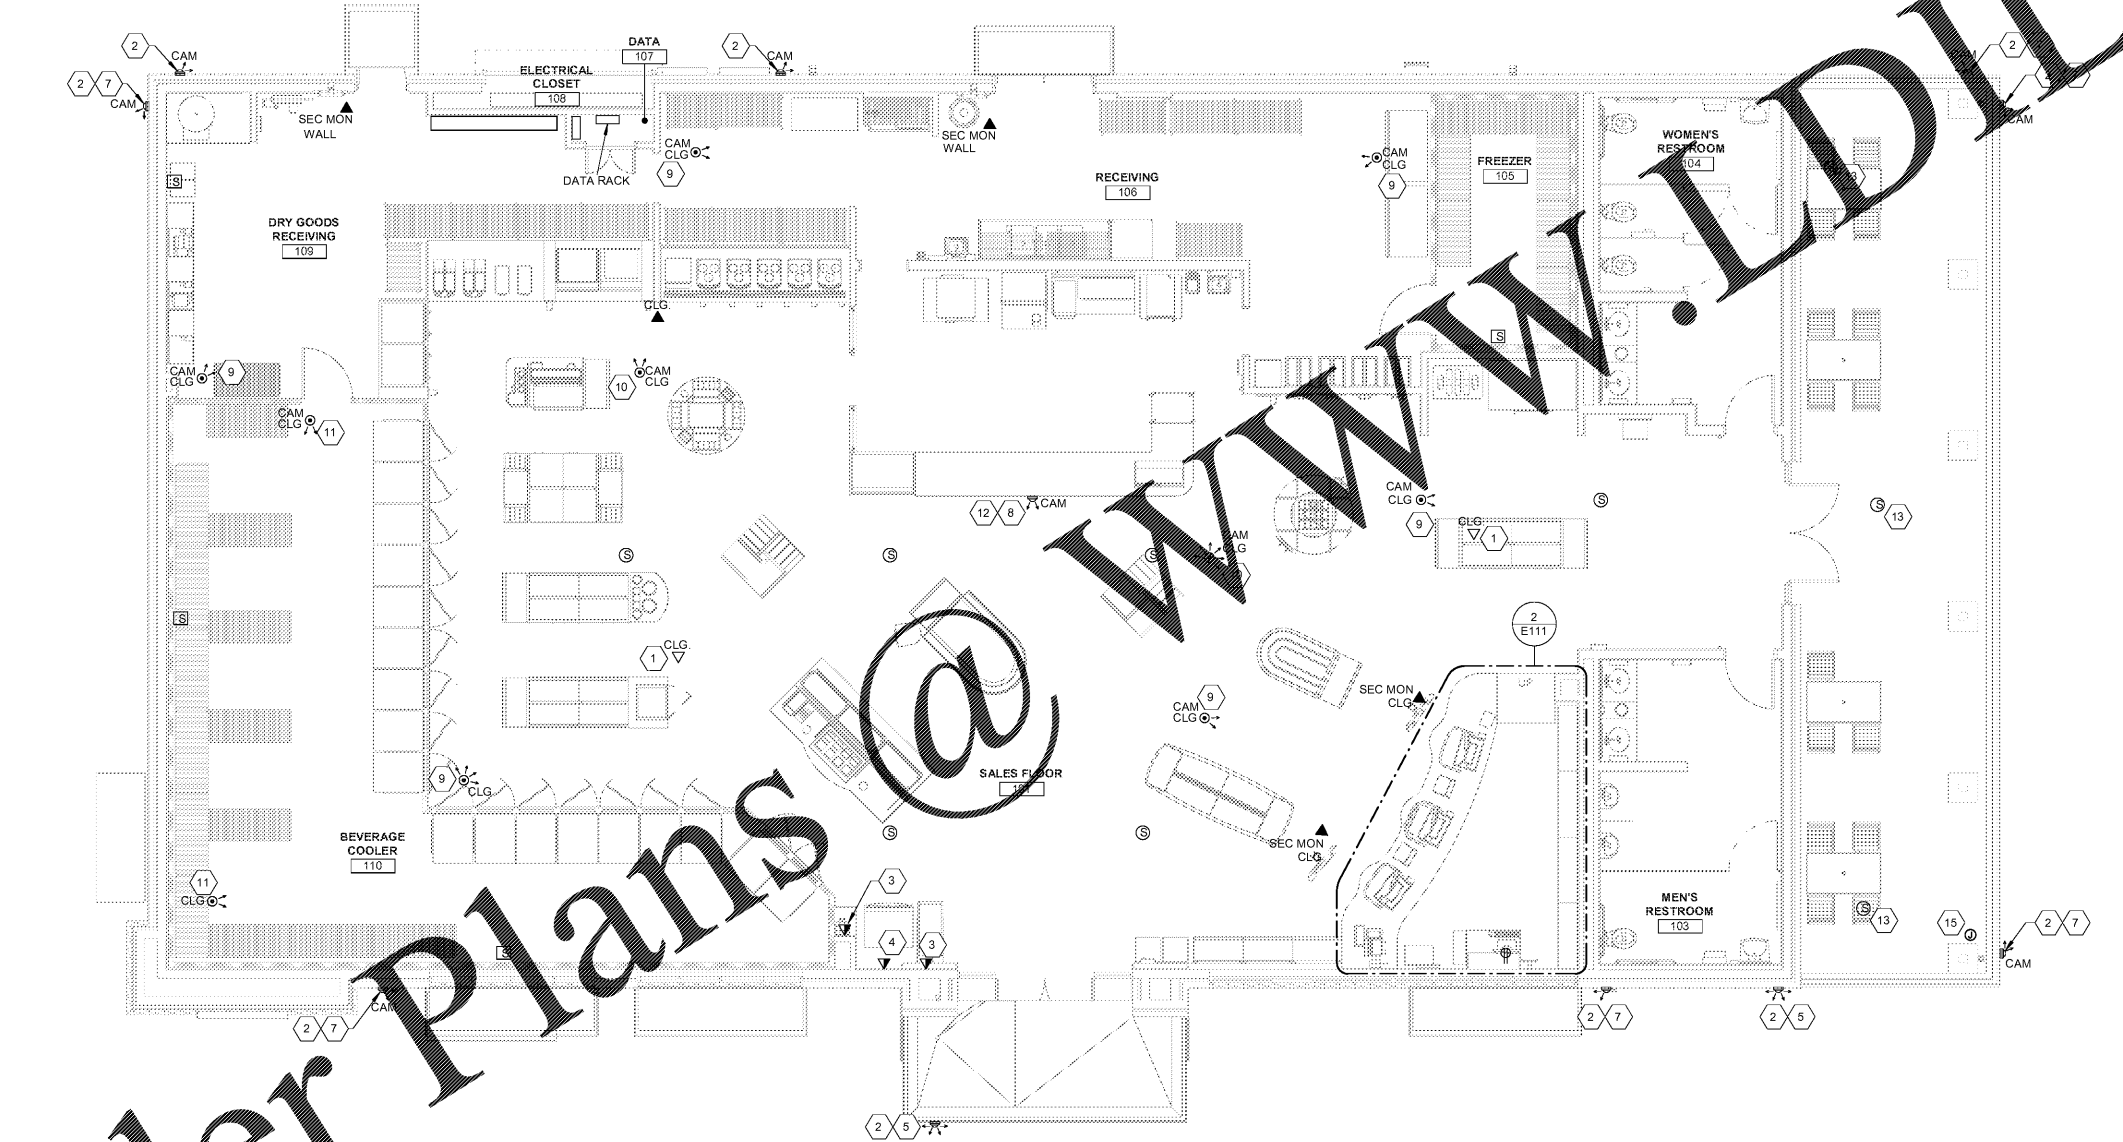

1 LOW VOLTAGE PLAN
1/8" = 1'-0"

GENERAL NOTES

1. SECURITY SYSTEM, INCLUDING MONITOR, RECORDER, CAMERAS, EQUIPMENT UPS AND 500 FT. ROLL OF RG591 CABLE TO BE PROVIDED BY RACE TRAC AND INSTALLED BY THE RACE TRAC VENDOR
 2. SECURITY SYSTEM AND UPS TO BE LOCATED ON SHELVING AND CONNECTED AS SHOWN ON SHEET E600.
 3. ALL SECURITY SYSTEM CABLES TO BE RUN OVERHEAD IN ACCESSIBLE CEILING SPACE (BY RACETRAC VENDOR).
 4. COORDINATE ALL CAMERA LOCATIONS WITH RACE TRAC BEFORE INSTALLATION.
 5. ELECTRICAL CONTRACTOR SHALL FIELD VERIFY ALL EQUIPMENT CONNECTION TYPES AND PROVIDE APPROPRIATE PLUG. CONTRACTOR IS RESPONSIBLE FOR MAKING ALL FINAL CONNECTIONS TO EQUIPMENT PROVIDED BY OTHERS.
 6. PROVIDE MANUFACTURER RECOMMENDED CABLE TO FUEL CANOPY SECURITY CAMERA. SEE ELECTRICAL SITE PLAN FOR LOCATION.
 7. TWO CAT 5 CABLE WITH RJ-45 CONNECTORS IS TO BE PULLED FROM THE ATM TO DATA PANEL. ALL CAT 5 CABLE IS TO BE CLEARLY LABELED AT EACH END. ALL RJ-45 CONNECTORS CHECKS TO BE AT&T TERMINATION (KEYS IN THE).
 8. LEVITON # 45080-256 WALL PLATE WITH THE FOLLOWING "QUICK PORTS" CONNECTIONS: 1-VOICE, 1-VOICE, 1-UTILITY PHONE, 1-606-VOICE.
- VEEDER BOOT #41108-DATA (RJ-45) WIRE STRAIGHT THROUGH & TERMINATE @ DATA PANEL.
VEEDER #41108-DATA (RJ-45) WIRE STRAIGHT THROUGH & TERMINATE @ DATA PANEL.
- SAFE #41008-DATA (RJ-45) WIRE STRAIGHT THROUGHOUT & TERMINATE @ DATA PANEL.
- LABEL ALL CONNECTIONS AND PLUG 6TH CONNECTOR OPENING (NO HAND WRITTEN LABELS).

SHEET KEYNOTES

1. OUTLETS LOCATED ABOVE CEILING FOR FUTURE WIRELESS ACCESS POINT.
2. MOUNT SECURITY CAMERA AT 12'-0".
3. PROVIDE MANUFACTURER RECOMMENDED CABLING BACK TO TELECOMMUNICATIONS CLOSET. SEE ARCHITECTURAL DRAWINGS FOR MOUNTING HEIGHT.
4. PROVIDE (2) CATS LINES FROM ATM TO THE TELEPHONE BOARD/FRAME RELAY ROUTER. INSTALL RJ11 CONNECTOR ON LINE TO TELEPHONE BOARD/RJ45 CONNECTOR TO ROUTER.
5. SMP OUTDOOR-VD-5340
7. HMP-OUTDOOR FIXED-EDR4700
8. HMP-INDOOR VARIOFICAL-FD-3400
9. HMP-INDOOR FIXED-EFD4700
10. HMP-INDOOR VARIOFICAL-FD-2400
11. HMP-OUTDOOR BULLET-EBL2100
12. MOUNT CAMERA ON FACE OF SOFFIT ABOVE FOOD BAR.
13. EXTERIOR GRADE RECESSED SPEAKER.
15. L.V.E.C SHALL PROVIDE (1) SPARE 3/4" CONDUIT WITH PULL-STRING.

RaceTrac
COPYRIGHT NOTICE
THESE PLANS ARE SUBJECT TO FEDERAL COPYRIGHT LAWS. ANY USE OF SAME WITHOUT THE EXPRESSED WRITTEN PERMISSION OF RACETRAC PETROLEUM, INC. IS PROHIBITED. ©2016 RACETRAC PETROLEUM, INC.

DESIGN PROFESSIONALS
HILLFOLEYROSSI & ASSOCIATES
ARCHITECTURE
ENGINEERING
3680 Pleasant Hill Road
Suite 200
Duluth, Georgia 30096
p 770.622.9858
f 770.622.9535
www.hillfoleyrossi.com

© Copyright (as dated below)
This drawing and all reproductions thereof are the property of Hillfoley Ross & Associates, LLC (HRA). It is intended for the exclusive use of the project named herein. Reproduction without the written consent of HRA is prohibited. All copies are to be returned to HRA upon project completion.

ISSUE/REVISION RECORD

DATE	DESCRIPTION
08/21/18	ISSUED FOR PERMIT

RaceTrac
RACETRAC PETROLEUM, INC.
200 GALLERIA PARKWAY SOUTHEAST
SUITE 900
ATLANTA, GEORGIA 30339
(770) 431-7600

PROJECT NAME
EAST MAIN STREET

CARTERSVILLE GEORGIA
1325 E. MAIN ST.
CARTERSVILLE, GA 30121

RACETRAC STORE NUMBER
1310

PROTOTYPE SERIES 5.5K 2.0
2018 RH MO

PLAN MODIFICATION NOTICE

SPB NO.	DATE



08/21/18
PROJECT NUMBER
18.714.00

SHEET TITLE
LOW VOLTAGE PLAN

SHEET NUMBER
E120
ISSUED FOR PERMIT