




2 CORNER TOWER FRONT ELEVATION  
3/16" = 1'-0"

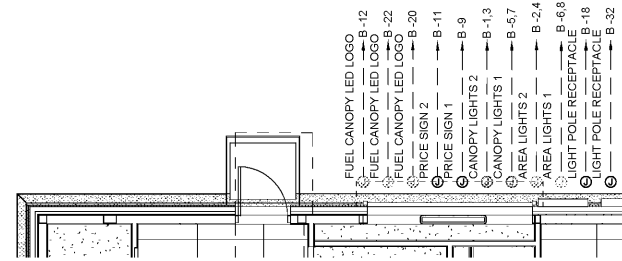

3 TYPICAL SITE LIGHTING CIRCUITS  
3/16" = 1'-0"

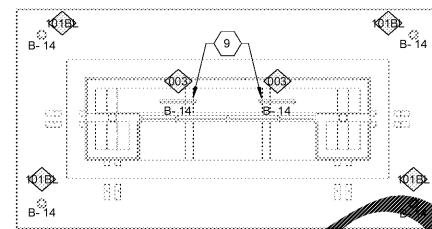

4 FRONT ENTRY TOWER LIGHTING  
3/16" = 1'-0"

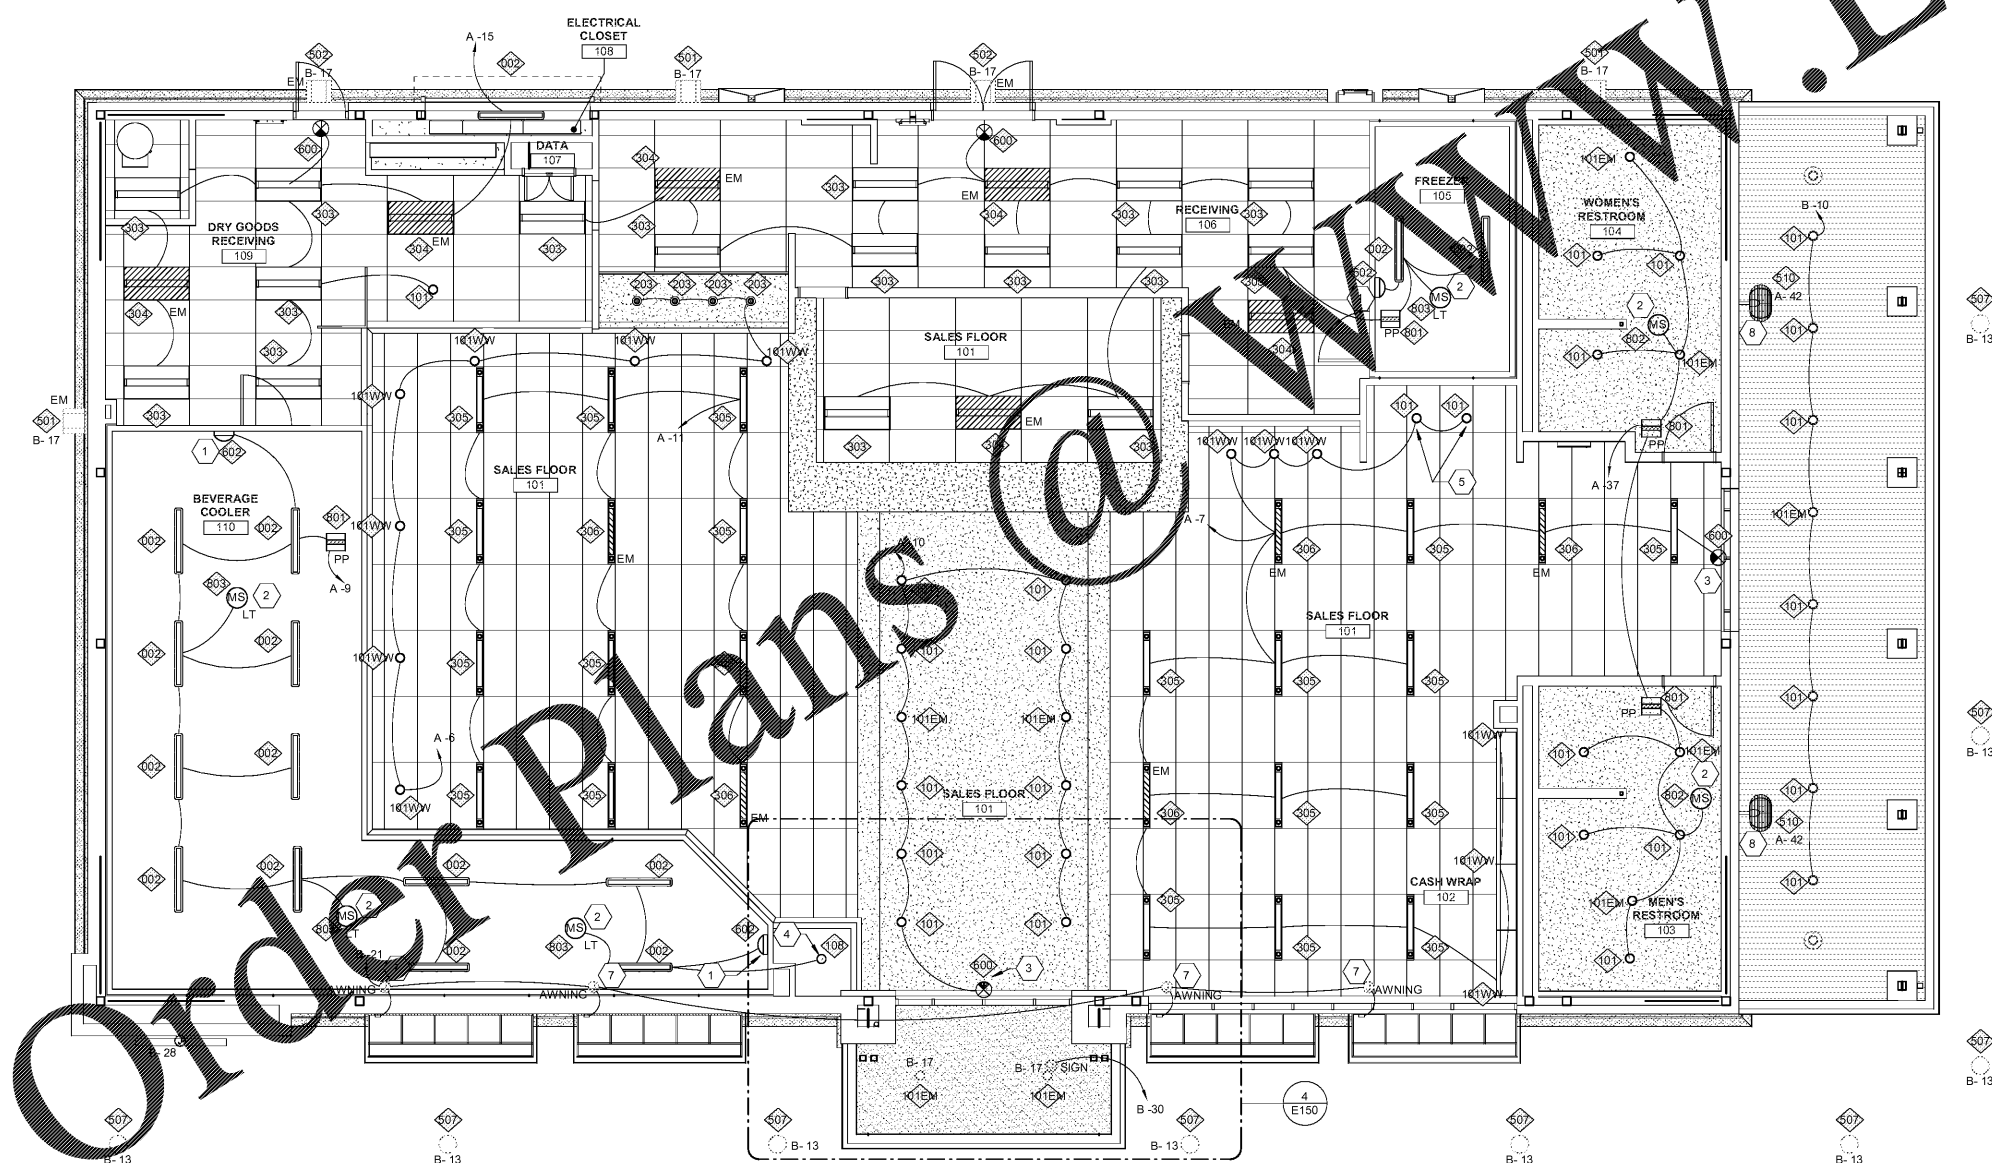

1 LIGHTING PLAN  
3/16" = 1'-0"

GENERAL NOTES

- ALL EXIT SIGNS AND/OR EMERGENCY LIGHTS SHALL BE CONNECTED AHEAD OF ANY LIGHT SWITCHES. DO NOT SWITCH EXIT SIGNS AND/OR EMERGENCY LIGHTS INDICATED WITH LETTERS 'EM'. AN UNSWITCHED HOT CONDUCTOR SHALL BE ROUTED DIRECTLY FROM THE PANELBOARD TO THE FIXTURE (BY-PASS ANY CONTRACTORS).
- SEE LIGHT FIXTURE SCHEDULE (E001) FOR FIXTURE INFORMATION.
- COORDINATE ALL BUILDING MOUNTED LIGHT FIXTURES WITH ARCHITECTURAL ELEVATIONS PRIOR TO ROUGH-IN.

**RaceTrac**  
COPYRIGHT NOTICE  
THESE PLANS ARE SUBJECT TO FEDERAL COPYRIGHT LAWS. ANY USE OF SAME WITHOUT THE EXPRESSED WRITTEN PERMISSION OF RACETRAC PETROLEUM, INC. IS PROHIBITED. 2016 RACETRAC PETROLEUM, INC.

**DESIGN PROFESSIONALS**  
**HILLFOLEYROSSI & ASSOCIATES**

ARCHITECTURE  
ENGINEERING

3680 Pleasant Hill Road  
Suite 200  
Duluth, Georgia 30096  
p 770.622.9858  
f 770.622.9535  
www.hillfoleyrossi.com

© Copyright (as dated below)  
This drawing and all reproductions thereof are the property of Hillfoleyrossi & Associates, LLC (HRA). It is intended for the exclusive use of the project named herein. Reproduction without the written consent of HRA is prohibited. All rights are to be returned to HRA upon project completion.

ARCHITECTURE  
ENGINEERING

3680 Pleasant Hill Road  
Suite 200  
Duluth, Georgia 30096  
p 770.622.9858  
f 770.622.9535  
www.hillfoleyrossi.com

ISSUE/REVISION RECORD

DATE	DESCRIPTION
08/21/18	ISSUED FOR PERMIT

**RaceTrac**  
RACETRAC PETROLEUM, INC.  
200 GALLERIA PARKWAY SOUTHEAST  
SUITE 900  
ATLANTA, GEORGIA 30339  
(770) 431-7600

PROJECT NAME  
**EAST MAIN STREET**

**CARTERSVILLE GEORGIA**  
1325 E. MAIN ST.  
CARTERSVILLE, GA 30121

RACETRAC STORE NUMBER  
**1310**

PROTOTYPE SERIES 5.5K 2.0  
**2018 RH MO**

PLAN MODIFICATION NOTICE

SPB NO.	DATE
STANDARD PLAN BULLETINS (SPB) MODIFY THE PROTOTYPE SERIES SET NOTED ABOVE. THE LISTED SPB REPRESENTS THE LATEST MODIFICATION INCORPORATED TO THIS PROTOTYPE SERIES SET AT ORIGINAL RELEASE. THE ISSUE/REVISION RECORD COLUMN ABOVE LISTS ANY REVISIONS OR SPB INCORPORATED IN THIS SET AFTER THE ORIGINAL RELEASE. CONTACT RACETRAC ENGINEERING AND CONSTRUCTION FOR ANY SUBSEQUENT BULLETINS NOT INCORPORATED HEREIN.	

PROFESSIONAL SEAL

08/21/18

PROJECT NUMBER  
18.714.00

SHEET TITLE  
**LIGHTING PLAN**

SHEET NUMBER  
**E150**  
ISSUED FOR PERMIT