


Order Plans

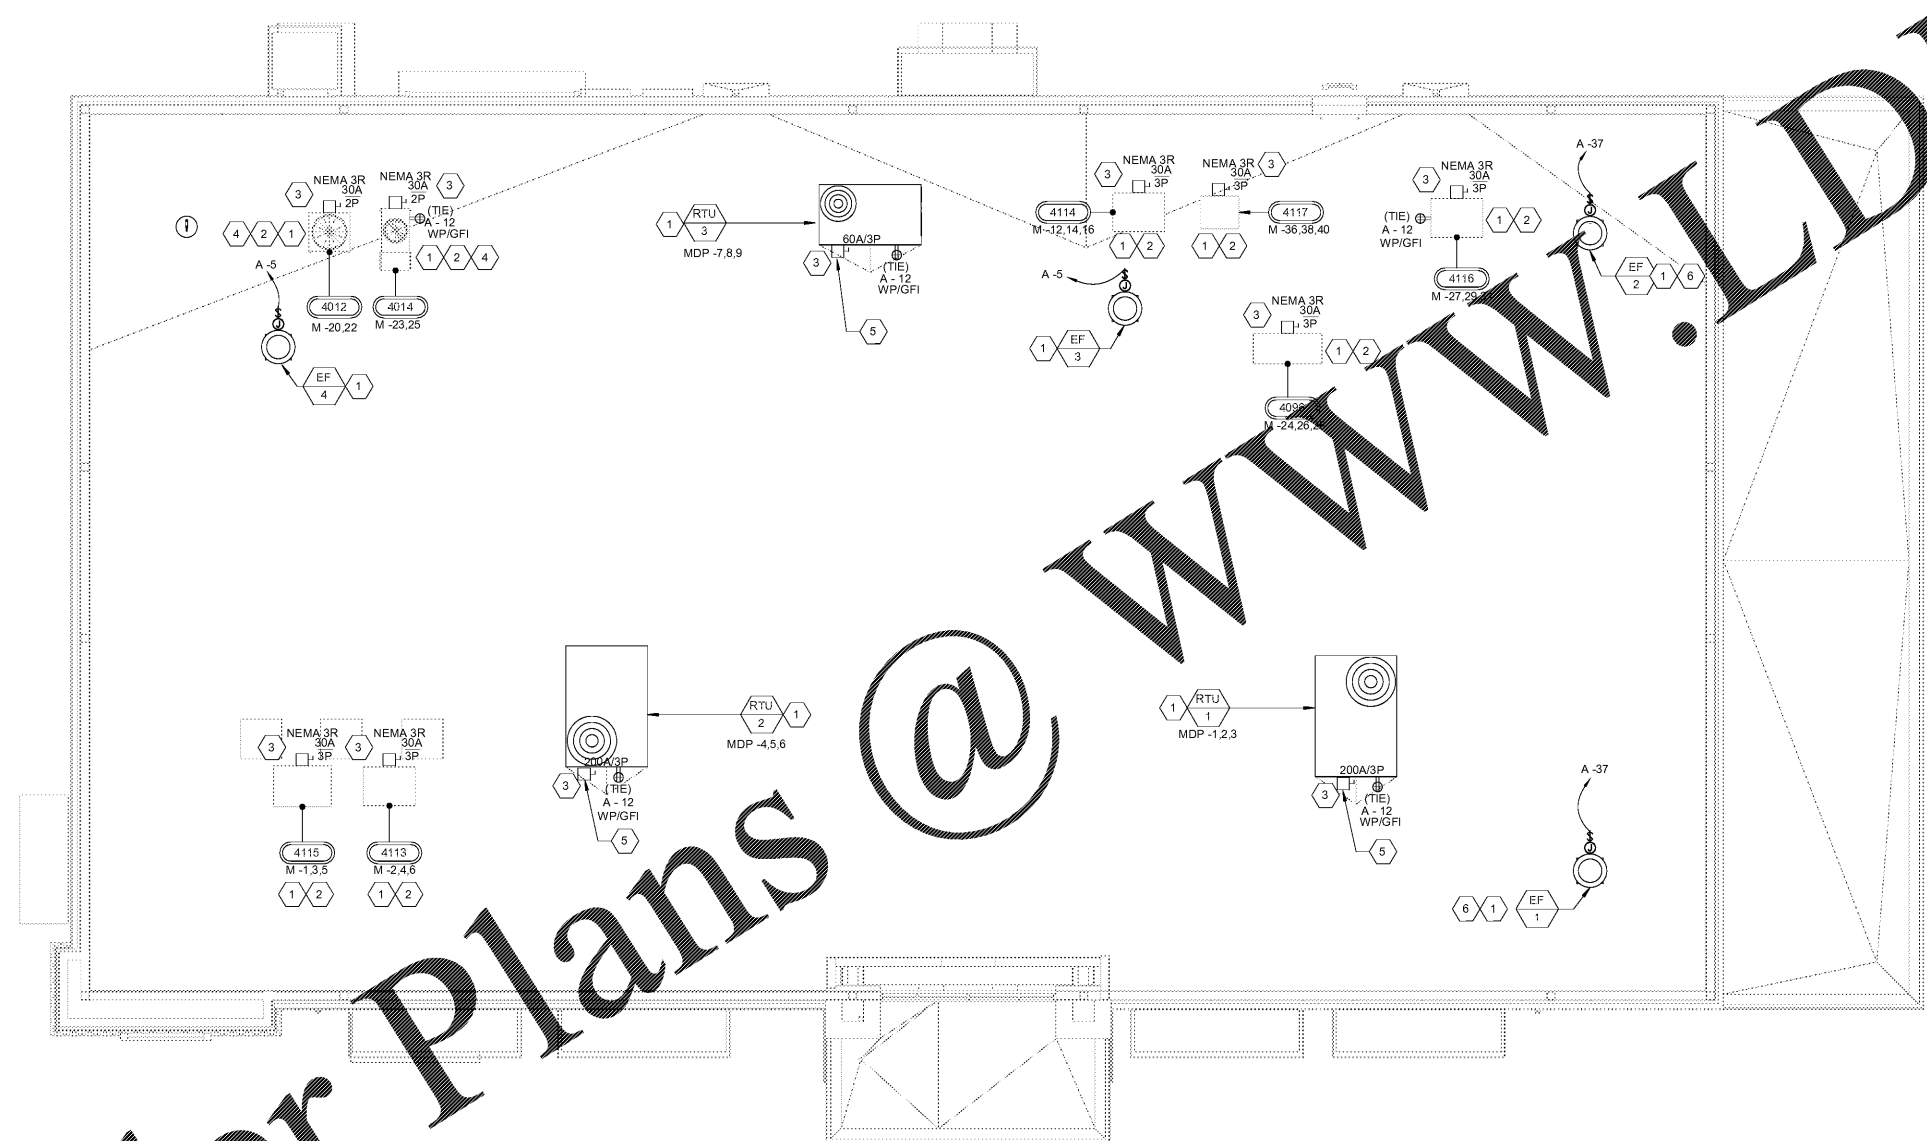

GENERAL NOTES

1. DISCONNECTS FOR HVAC EQUIPMENT FURNISHED BY HVAC MANUFACTURER.
2. DISCONNECTS FOR REFRIGERATION EQUIPMENT PROVIDED BY EC.
3. RECEPTACLES SHOWN ON HVAC EQUIPMENT PROVIDED BY HVAC MANUFACTURER. WIRING TO THE RECEPTACLES BY EC.
4. ELECTRICAL CONTRACTOR TO APPLY NAME LABELS TO COMPRESSOR HOUSINGS AFTER INSTALLATION. LABELS SUPPLIED BY RACETRAC.

RaceTrac
COPYRIGHT NOTICE
 THESE PLANS ARE SUBJECT TO FEDERAL COPYRIGHT LAWS. ANY USE OF SAME WITHOUT THE EXPRESSED WRITTEN PERMISSION OF RACETRAC PETROLEUM, INC. IS PROHIBITED. © 2016 RACETRAC PETROLEUM, INC.

DESIGN PROFESSIONALS
HR
 HILLFOLEYROSSI & ASSOCIATES

ARCHITECTURE
 ENGINEERING
 3680 Pleasant Hill Road
 Suite 200
 Duluth, Georgia 30096
 p 770.622.9858
 f 770.622.9535
 www.hillfoleyrossi.com

© Copyright (as dated below)
 This drawing and all reproductions thereof are the property of Hillfoleyrossi & Associates, LLC (HRA). It is intended for the sole use of the project named herein. Reproduction without the written consent of HRA is prohibited. All copies are to be returned to HRA upon project completion.

ISSUE/REVISION RECORD

DATE	DESCRIPTION
08/21/18	ISSUED FOR PERMIT

RaceTrac
 RACETRAC PETROLEUM, INC.
 200 GALLERIA PARKWAY SOUTHEAST
 SUITE 900
 ATLANTA, GEORGIA 30339
 (770) 431-7600

PROJECT NAME
EAST MAIN STREET

CARTERSVILLE GEORGIA
 1325 E. MAIN ST.
 CARTERSVILLE, GA 30121

RACETRAC STORE NUMBER
1310

PROTOTYPE SERIES 5.5K 2.0
 2018 RH MO

PLAN MODIFICATION NOTICE
 SPB NO. DATE

STANDARD PLAN BULLETINS (SPB) MODIFY THE PROTOTYPE SERIES SET NOTED ABOVE. THE LISTED SPB REPRESENTS THE LATEST MODIFICATION INCORPORATED TO THIS PROTOTYPE SERIES SET AT ORIGINAL RELEASE. THE ISSUE/REVISION RECORD COLUMN ABOVE LISTS ANY REVISIONS OR SPB INCORPORATED IN THIS SET AFTER THE ORIGINAL RELEASE. CONTACT RACETRAC ENGINEERING AND CONSTRUCTION FOR ANY SUBSEQUENT BULLETINS NOT INCORPORATED HEREIN.

PROFESSIONAL SEAL

 WILLIAM S. GADDY, JR.
 REGISTERED PROFESSIONAL ENGINEER
 STATE OF GEORGIA
 No. 127204

PROJECT NUMBER
 18.714.00

SHEET TITLE
ROOF POWER PLANS

SHEET NUMBER
E200
 ISSUED FOR PERMIT

SHEET KEYNOTES

1. ELECTRICAL CONTRACTOR SHALL PROVIDE ALL INTERCONNECTING WIRE AND OVER CURRENT PROTECTION REQUIRED BY THE MANUFACTURER. REFER TO INSTALLATION INSTRUCTIONS.
2. ROUTE BRANCH CIRCUITS DOWN THROUGH ROOF VIA REFRIGERANT LINE ROOF JACK PROVIDED AND INSTALLED BY MECHANICAL CONTRACTOR. COORDINATE 'ATR' HUB LOCATIONS WITH ARCHITECTURAL & MECHANICAL DRAWINGS.
3. PROVIDE FUSES ACCORDING TO MANUFACTURER RECOMMENDATIONS.
4. CONDENSER TO BE FED FROM ITS ASSOCIATED ICE MAKER ON SALES FLOOR.
5. DISCONNECT SWITCH INTEGRAL TO UNIT. REFERENCE MECHANICAL SHEETS FOR ADDITIONAL INFORMATION.
6. EXHAUST FANS EF-1 & EF-2 SHALL BE CONTROLLED BY OCCUPANCY SENSOR IN RESTROOMS.