

ISSUE/REVISION RECORD

DATE	DESCRIPTION
08/21/18	ISSUED FOR PERMIT

SPB NO.	DATE
STANDARD PLAN BULLETINS (SPB) MODIFY THE PROTOTYPE SERIES SET NOTED ABOVE. THE LISTED SPB REPRESENTS THE LATEST MODIFICATION INCORPORATED TO THIS PROTOTYPE SERIES SET AT ORIGINAL RELEASE. THE ISSUE/REVISION RECORD COLUMN ABOVE LISTS ANY REVISIONS OR SPB INCORPORATED IN THIS SET AFTER THE ORIGINAL RELEASE. CONTACT RACETRAC ENGINEERING AND CONSTRUCTION FOR ANY SUBSEQUENT BULLETINS NOT INCORPORATED HEREIN.	



GENERAL NOTES


- ALL FIXTURES SHOWN IN THIS PHOTOMETRY PLAN ARE FULLY SPECIFIED.
- MOUNT AREA LUMINAIRE AT 28'-0" AFG (INCLUDING 2'-0" HANGERS).

STATISTICS

Description	Symbol	Qty	Min	Max/Min	Avg/Min
Beyond Property	+	0.0 fc	0.0 fc	N/A	N/A
Fuel Canopy	+	38.9 fc	37.5 fc	3.0 ft	2.3 ft
	+	0.0 fc	14.5 fc	0.0 fc	N/A

LUMINAIRE SCHEDULE

Code	Qty	Catalog Number	Description	Lamp	File	Lumens	LLF	Watts
A	24	SCVLED-13L-SC50	LED CANOPY LIGHT	LIGHT EMITTING DIODES	SCVLED-13L-SC50/ES	1282	0.90	84.3
B	2	A2B105	WITH WHITE TRIM & RECESSED WHITE PLASTIC LENS	LED8 LUMEN	LR6/ies	647	0.90	11.5
C	9	SP2-STR-V4-2050-FCO-MOODKBS-12-LED-DB	SPECTRA FIXTURE	12 LED ARRAY	SP2-STR-V4-2050-FCO-MOODKBS-12-LED-DB/ES	2047	0.90	27.3
D	3	XALM-2LED-VHO-50-L	LED AREA LIGHT WITH BACKLIGHT CONTROL	LIGHT EMITTING DIODES	XALM-2LED-VHO-50-L/ES	25413	0.90	313.6
E	2	XALM-FTLED-VHO-50-L	LED AREA LIGHT WITH BACKLIGHT CONTROL	LIGHT EMITTING DIODES	XALM-FTLED-VHO-50-L/ES	26023	0.90	315
F	2	XWM-FTLED-0650	LED WALL PACK	LIGHT EMITTING DIODES	XWM-FTLED-0650/ES	6025	0.90	53.9
G	4	XWM-2LED-0350	LED WALL PACK	LIGHT EMITTING DIODES	XWM-2LED-0350/ES	3456	0.90	29.2

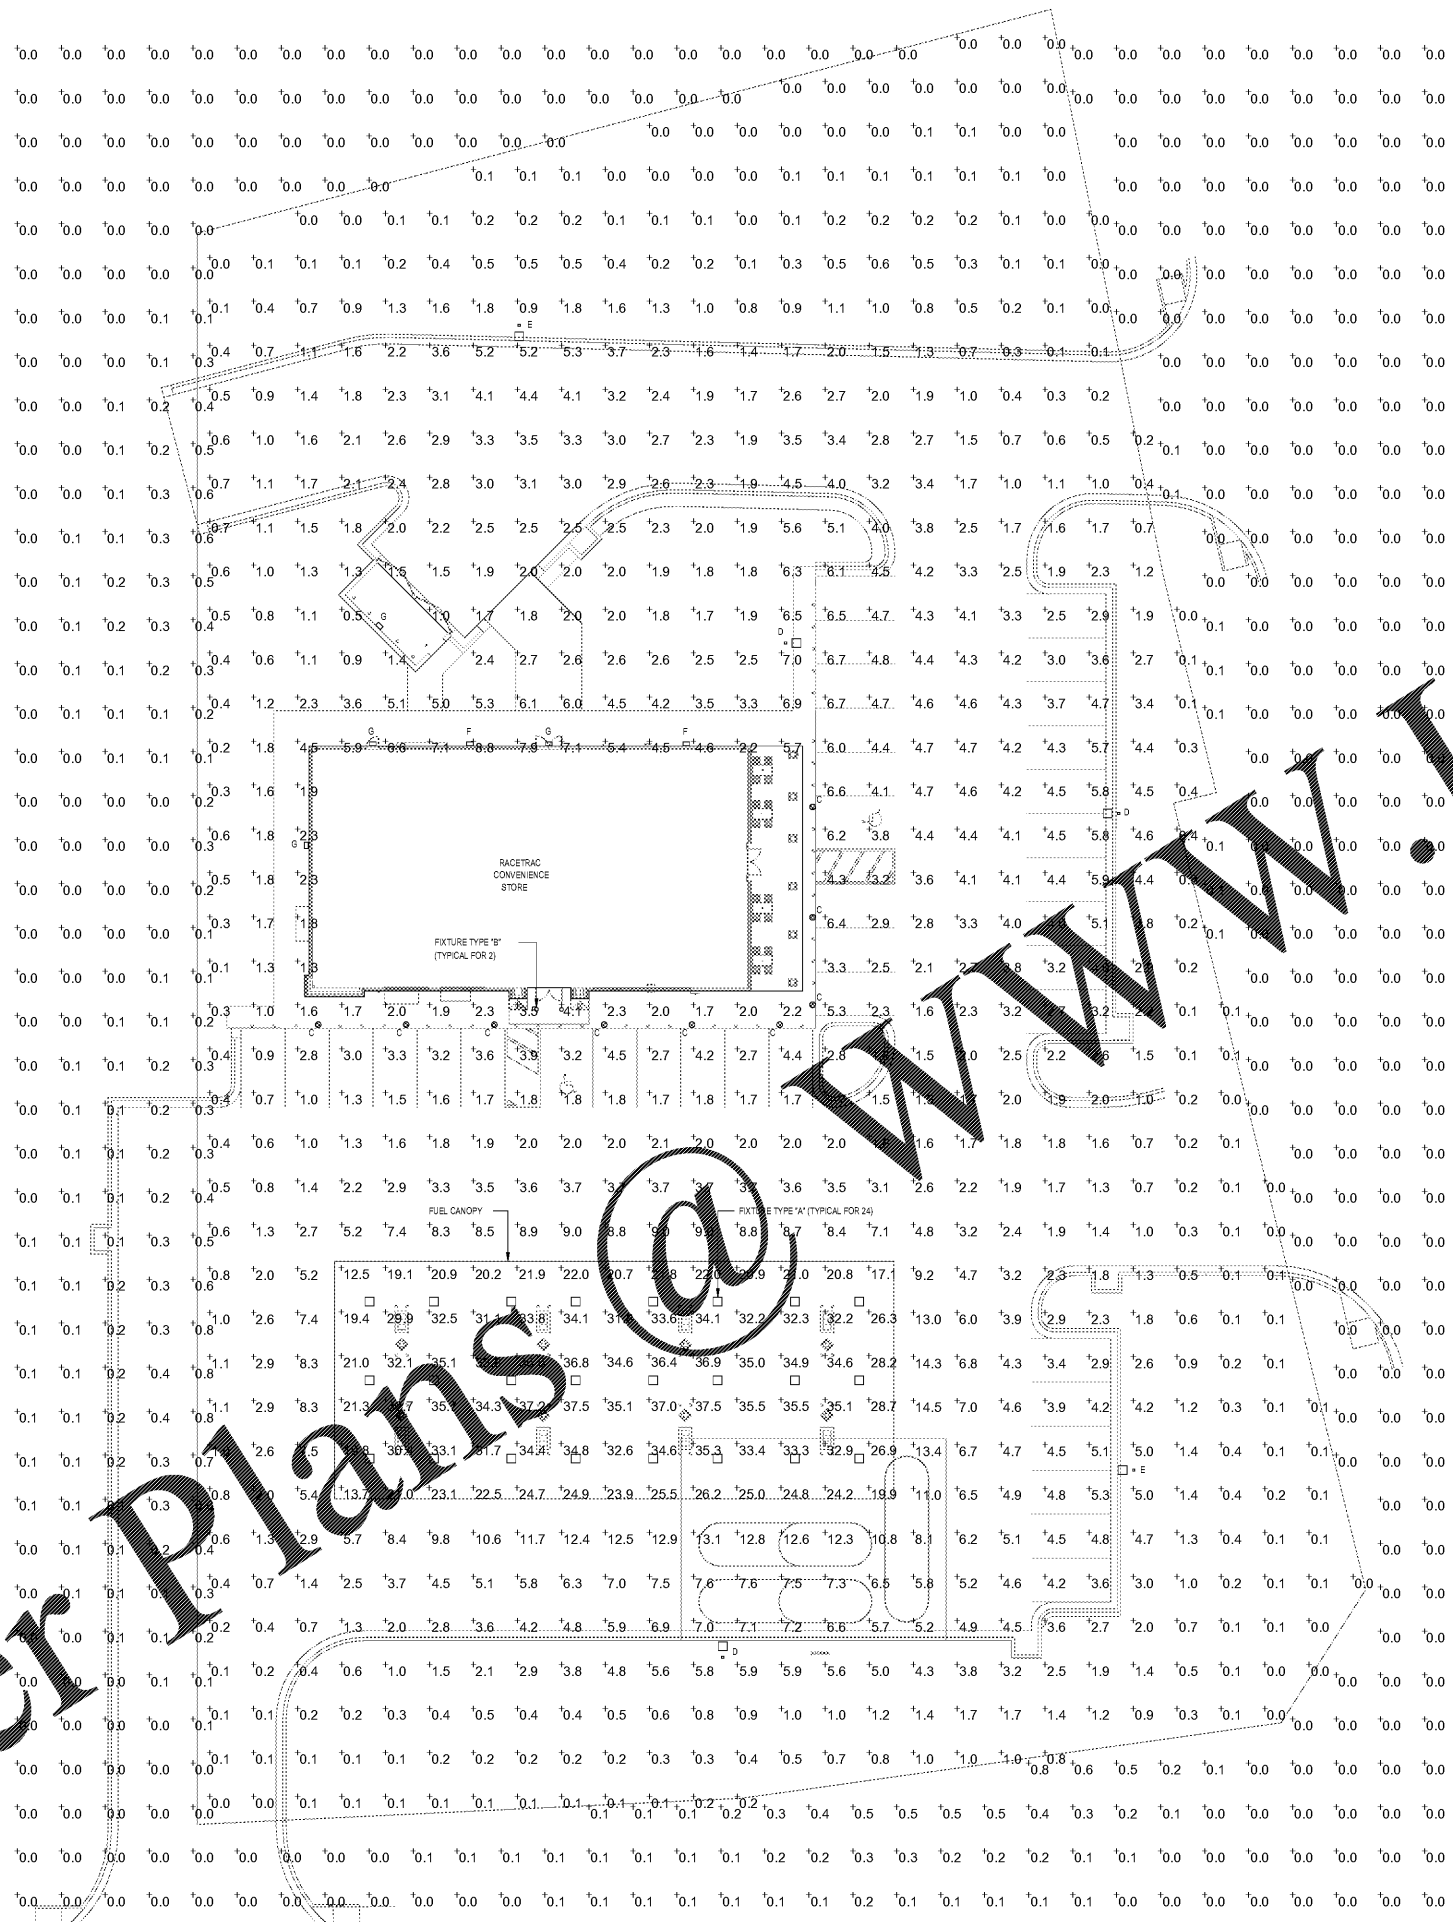

1 SITE PHOTOMETRY PLAN
 SP-1 SCALE: 1"=20'

Order Plans @ www.wldline.com