




submission:	Date
OWNER/LL REVIEW	11/01/2018
S&D SET	11/01/2018
PERMIT SET	11/01/2018

revisions:	Date
# Description	



NOTE:  
COORDINATE WITH ELECTRICAL SHEETS

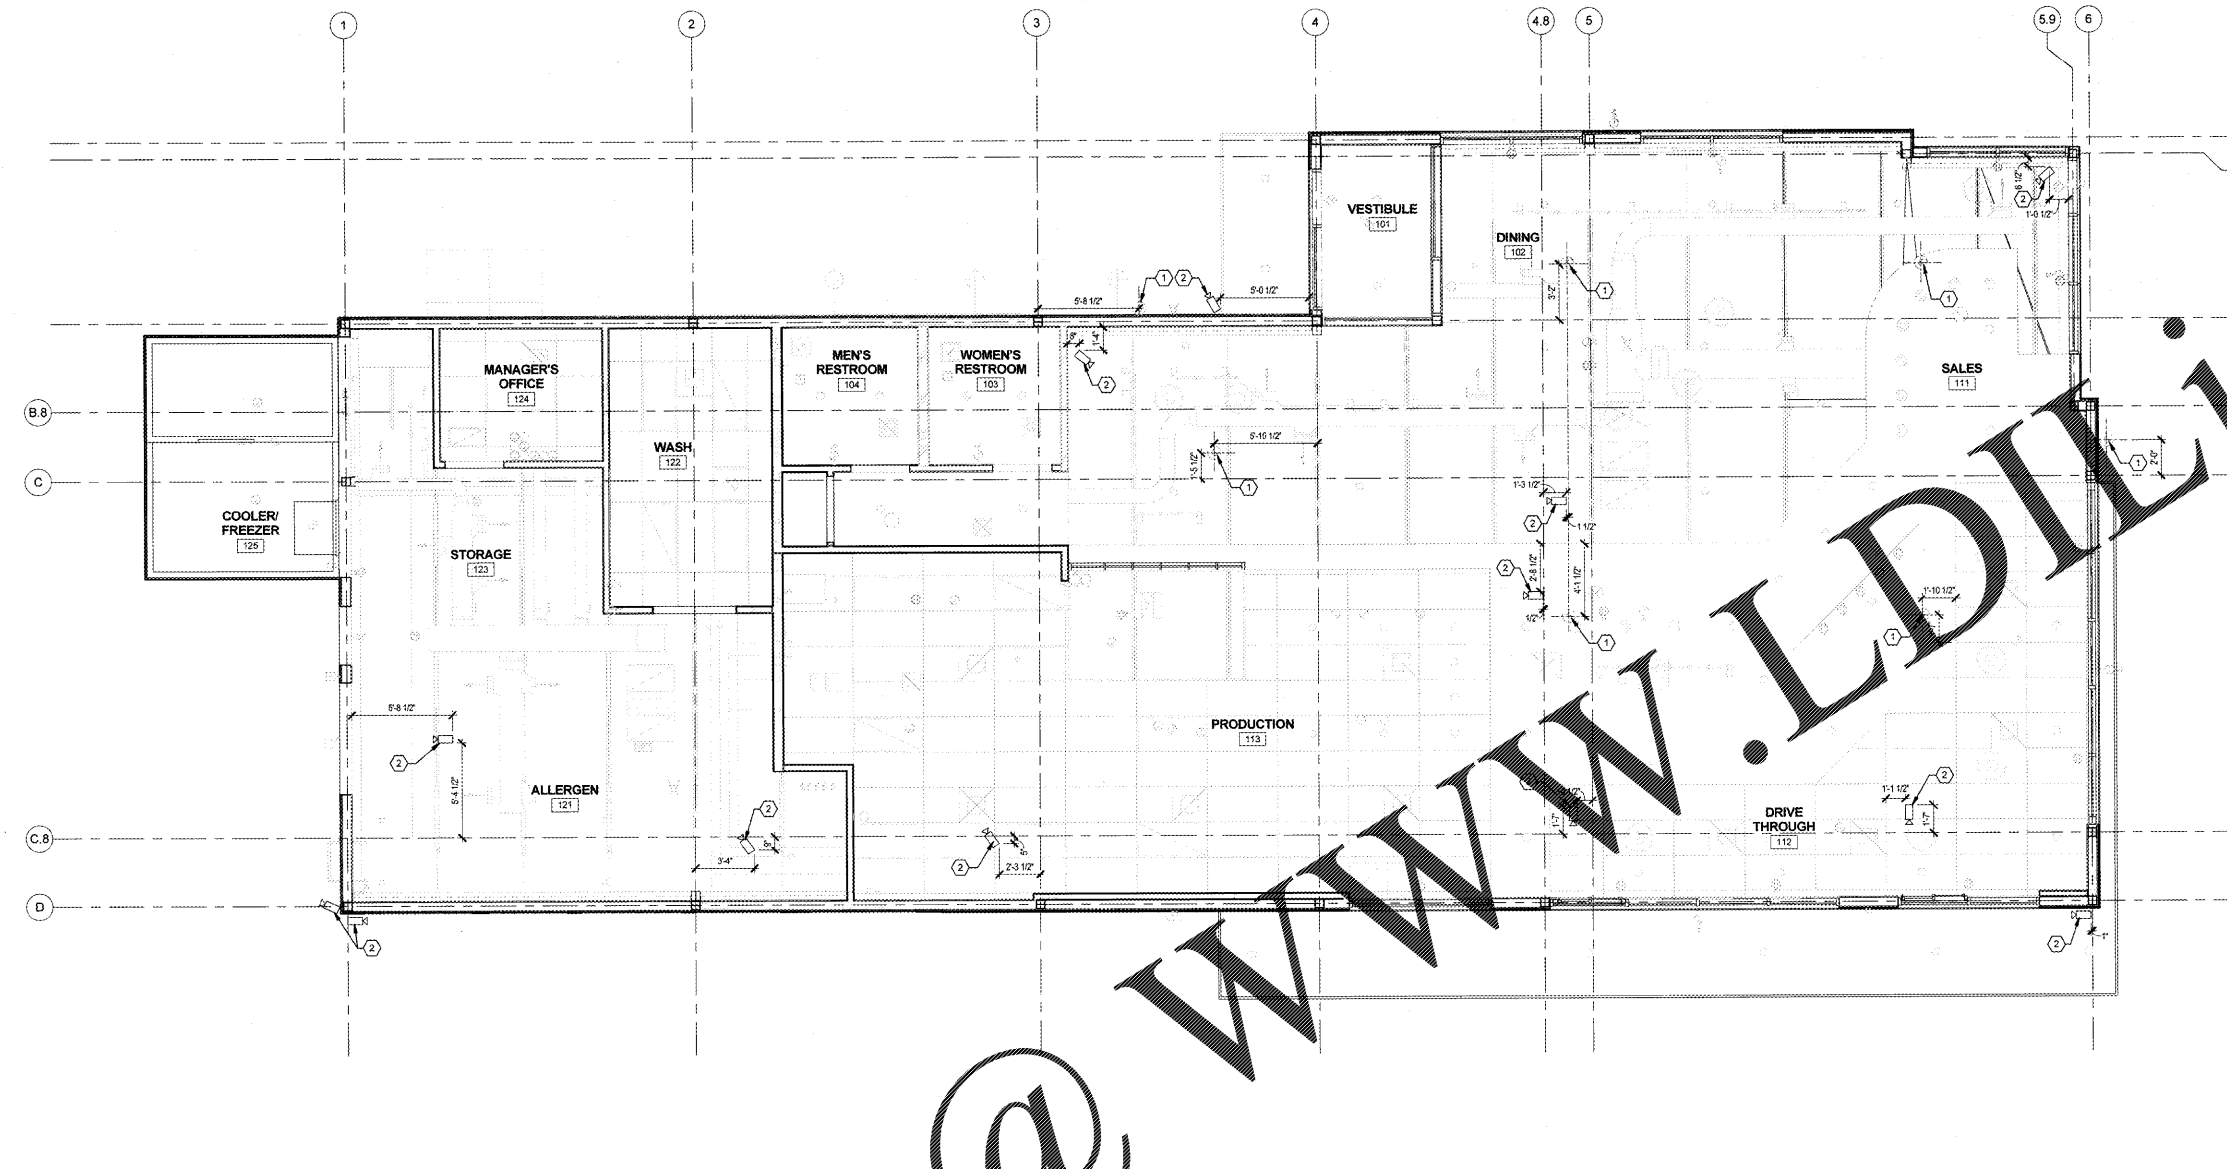

01 reflected ceiling plan - low voltage  
SCALE | 1/4" = 1'-0"

keynotes

- 1 SPEAKER BY VENDOR. SEE ELECTRICAL DRAWINGS.
- 2 SECURITY CAMERA BY VENDOR. SEE CAMERA SCHEDULE IN ELECTRICAL DRAWINGS.

symbol legend


NOTE: REFER TO ELECTRICAL SHEET FOR MORE INFORMATION

SYMBOL	TYPE	DESCRIPTION	QTY
(Symbol)	TYPE	DRIVE THRU CAMERA REFER TO SCHEDULE OF E-SHEETS	03 NOS.
(Symbol)	TYPE	SPEAKER BY VENDOR REFER TO SCHEDULE OF E-SHEETS FOR POWER INFORMATION	06 NOS.

\*CAMERA COLORS TO BE VERIFIED PRIOR TO ORDER

Order Plans @

seal

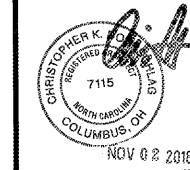

sheet info

LOW VOLTAGE  
PLAN  
A121