

keynotes

- 1 KITCHEN HOOD EXHAUST FAN AND CURB FURNISHED BY CAPTIVEAIRE AND INSTALLED BY MECHANICAL CONTRACTOR. INSTALL PER MANUFACTURER'S SPECIFICATIONS AND LOCAL CODE REQUIREMENTS
- 2 DEDICATED OUTSIDE AIR SYSTEM. INSTALL PER MANUFACTURER'S SPECIFICATIONS AND LOCAL CODE REQUIREMENTS
- 3 COOLING TUNNEL CONDENSING UNIT. TO BE FURNISHED AND INSTALLED ON EQUIPMENT RAILS BY VENDOR. GENERAL CONTRACTOR TO INSTALL EQUIPMENT RAILS. INSTALL EQUIPMENT AND RAILS PER MANUFACTURER'S SPECIFICATIONS AND PER WIND RESISTANCE REQUIREMENTS IN ACCORDANCE WITH THE MECHANICAL CODE. PROVIDE REFRIGERANT CONDUIT PATHWAY. REFER TO DETAILS 2 AND 3. SHEET M401. REFER TO KITCHEN EQUIPMENT SCHEDULE FOR SPECIFICATIONS. MAKE AND MODEL OF THE CONDENSING UNIT. WEIGHT=215 LBS.
- 4 PROVIDE RESTROOM EXHAUST FAN AND ROOF CURB FURNISHED BY MECHANICAL CONTRACTOR. INSTALL PER MANUFACTURER'S SPECIFICATIONS AND LOCAL CODE REQUIREMENTS
- 5 REFER TO PLUMBING DRAWINGS FOR WATER HEATER VENT INFORMATION.
- 6

architect + engineer

wd PARTNERS

brand · operations · lead

DISCOVERY
DOUGHERTY 43017
814 399-0001
WDPARTNERS.COM

project no. | KRKDS0003

owner



project info

CONCORD
NORTH CAROLINA

 
issue dates

submission:	Date
OWNER/LL REVIEW	11/01/2018
BID SET	11/01/2018
PERMIT SET	11/01/2018

revisions:

#	Description	Date

seal




NOV 02 2018

sheet info

MECHANICAL
ROOF PLAN

M101

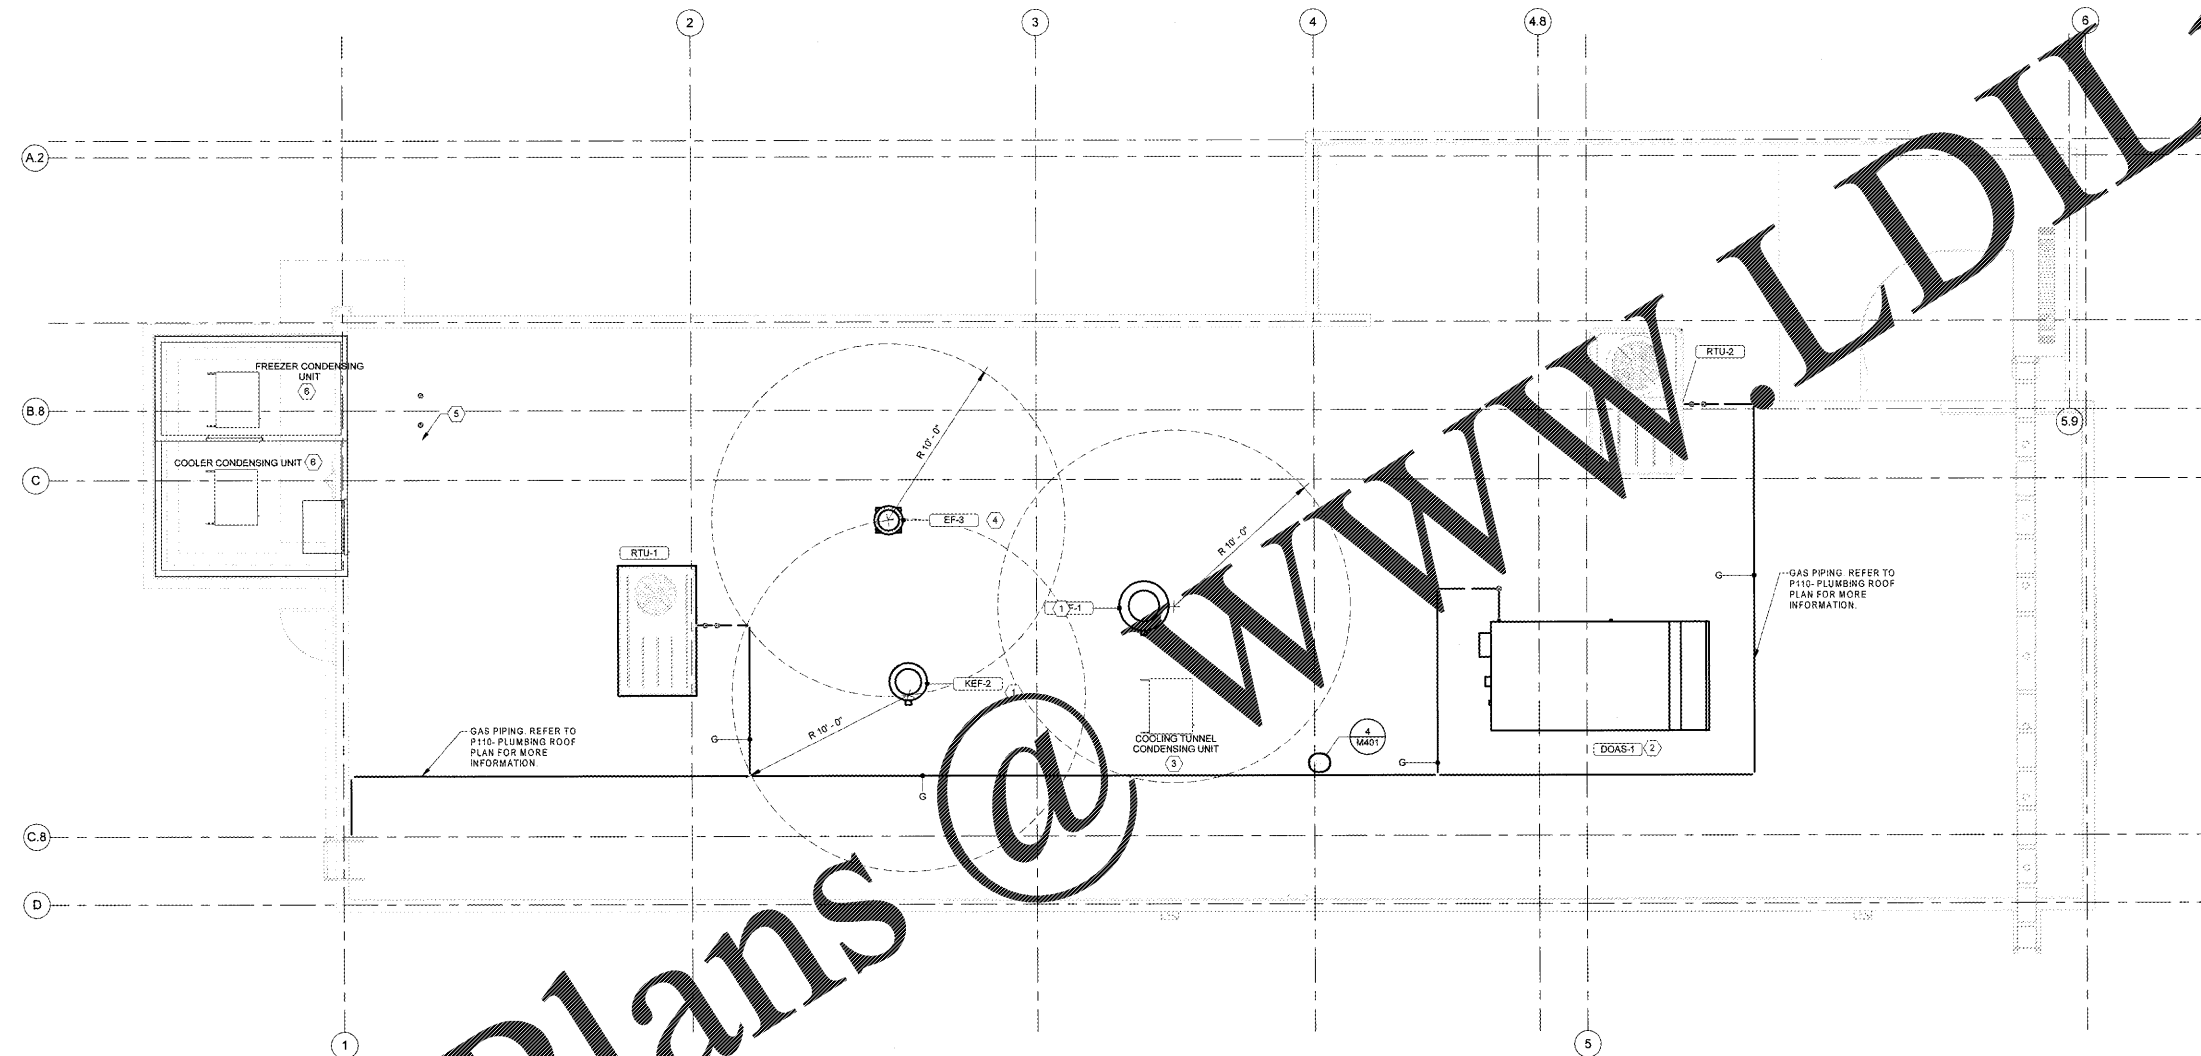

Order Plans @ www.LDILine.com

1 roof mechanical plan
SCALE | 1/4" = 1'-0"

