

keynotes

- 1 ROUTE EVAP COIL CONDENSATE PIPE, SIZED PER COIL REQUIREMENTS, TO PENETRATE THROUGH COOLER/FREEZER WALL AND DOWN EXTERIOR WALL AND DISCHARGE TO SPLASH BLOCK SEAL AROUND PIPING AND BOLT PENETRATIONS THRU COOLER/FREEZER BOX WALLS OR CEILING WITH BACKER ROD SEALANT.
- 2 PROVIDE INDIRECT WASTE CONNECTION TO FLOOR SINK WITH AIR GAP. SEE EQUIPMENT SCHEDULE FOR SIZE OF INDIRECT WASTE LINE.
- 3 ROUTE INDIRECT WASTE FROM KITCHEN EQUIPMENT TO FLOOR SINK. SLOPE PIPING 1/4" PER FOOT TO DISCHARGE OVER FLOOR SINK WITH AIR GAP.
- 4 PROVIDE COMPLETE HEAT TRACING SYSTEM ON CONDENSATE LINE LOCATED IN THE WALK IN FREEZER COMPARTMENT. FINAL CONNECTION TO THE ELECTRICAL SYSTEM SHALL BE BY THE ELECTRICAL CONTRACTOR. REFER TO THE HEAT TRACING DETAIL IN SHEET P550 FOR FURTHER INFORMATION.
- 5 PROVIDE 3" VENT THRU ROOF. FIELD COORDINATE EXACT LOCATION FOR VENT THRU ROOF. ALL ROOFING WORK FOR INSTALLATION TO BE BY THE LANDLORD'S ROOFING CONTRACTOR AT THE PLUMBING CONTRACTOR'S EXPENSE.
- 6 SANITARY VENT ROUTED UNDER COUNTER OVER TO FULL HEIGHT WALL.

architect + engineer



project no. | KRKDS0003

owner



project info

CONCORD  
NORTH CAROLINA

issue dates

submission:	Date
OWNER/LL REVIEW	11/01/2018
800 SET	11/01/2018
PERMIT SET	11/01/2018

revisions:


#	Description	Date
---	-------------	------

seal



sheet info

PLUMBING  
WASTE & VENT  
PLAN  
**P100**

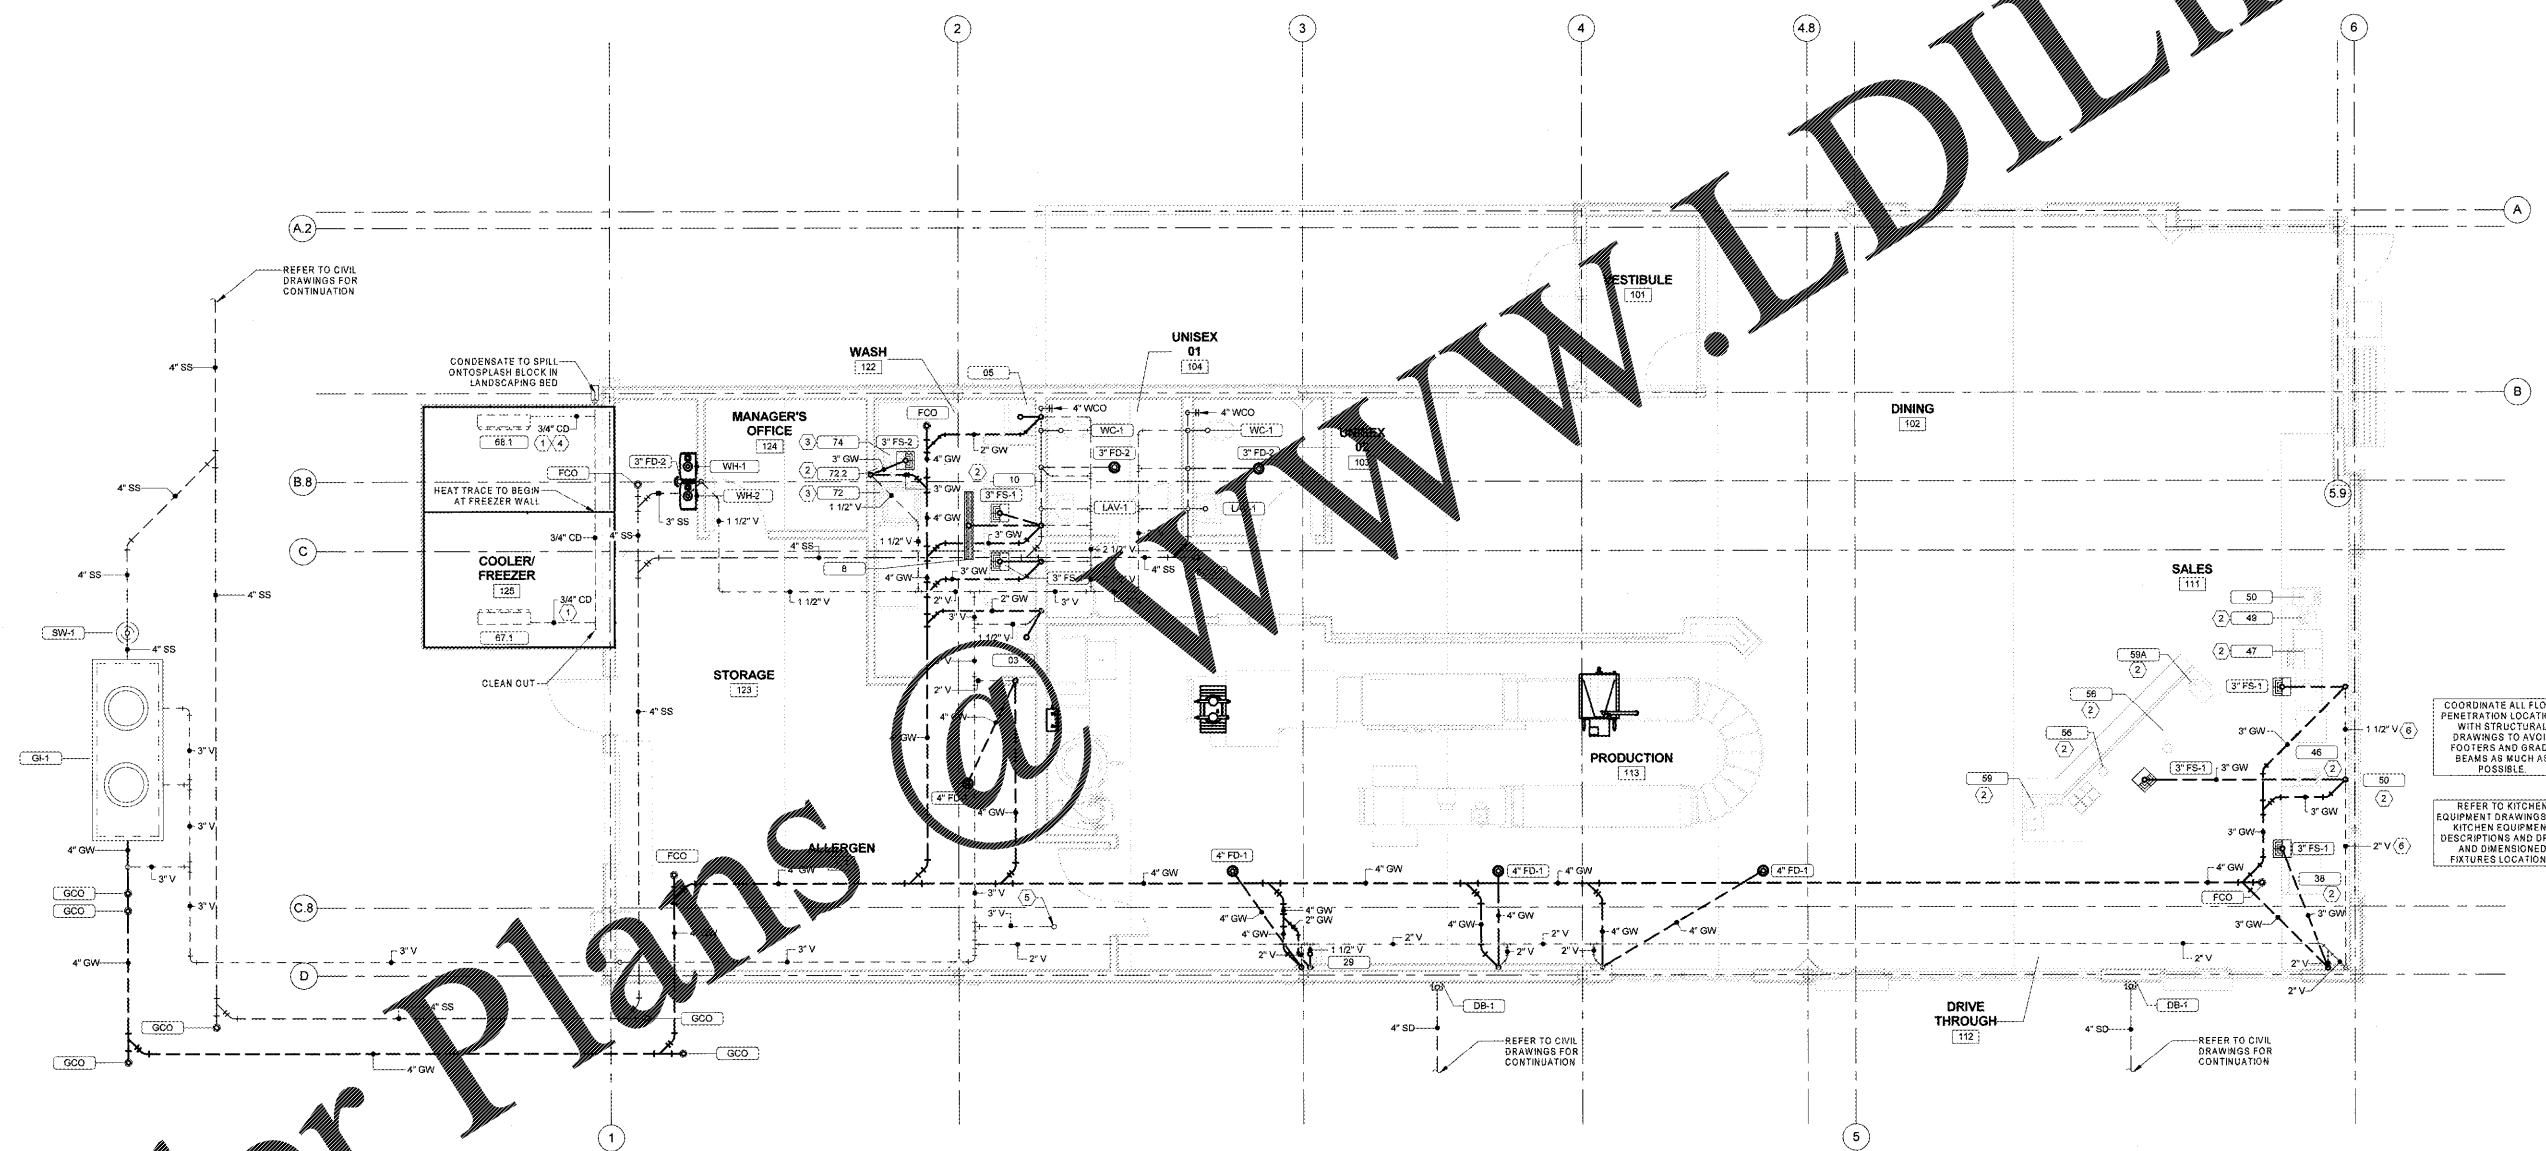

Order Plans

1 sanitary waste & vent plumbing plan  
SCALE | 1/4" = 1'-0"