



225 VANCE STREET, SUITE 301
NEW YORK, NY 10014

CONCORD
NORTH CAROLINA


submission:	Date
OWNER REVIEW	11/01/2018
BID SET	11/01/2018
PERMIT SET	11/01/2018

#	Description	Date




ELECTRICAL SITE PLAN


ES-1

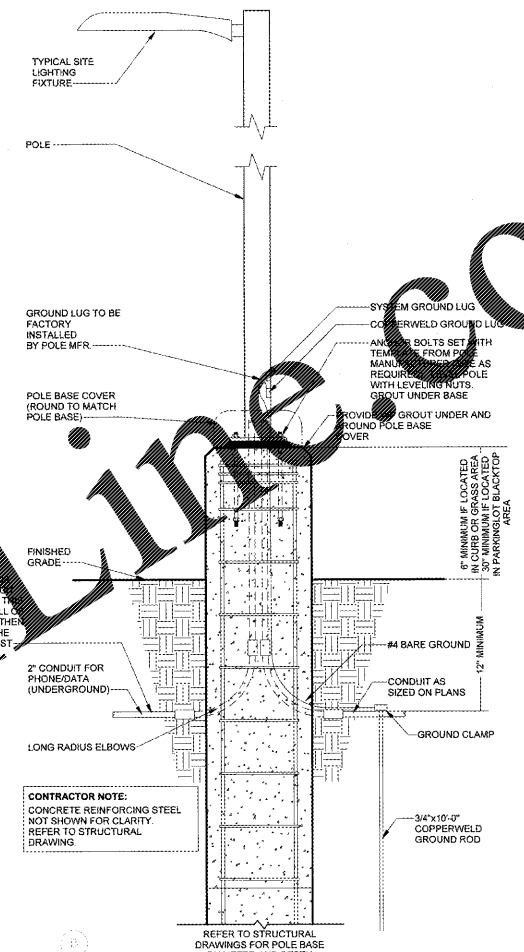


6 electrical pole base detail
SCALE | 3/4" = 1'-0"

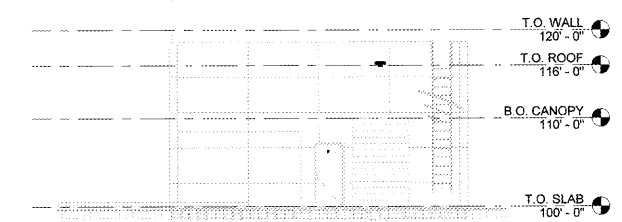


5 east elevation
SCALE | 1/8" = 1'-0"

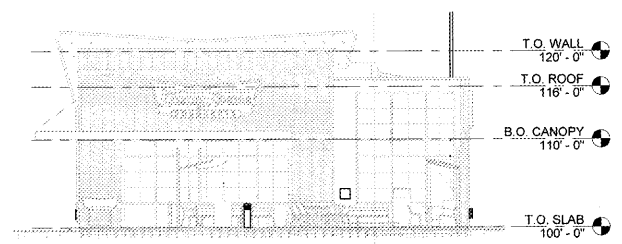

4 west elevation
SCALE | 1/8" = 1'-0"

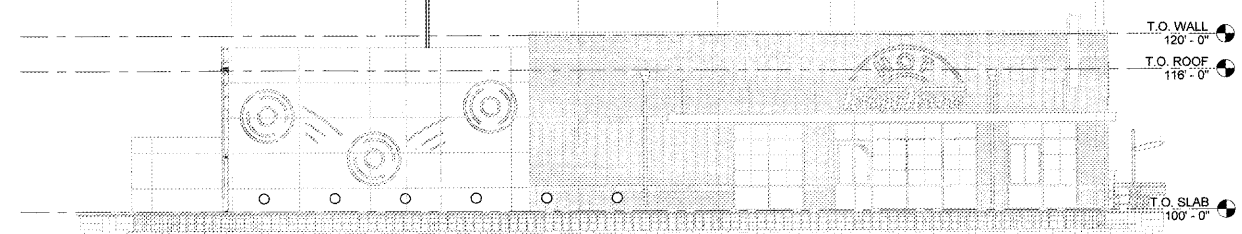

2 south elevation
SCALE | 1/8" = 1'-0"

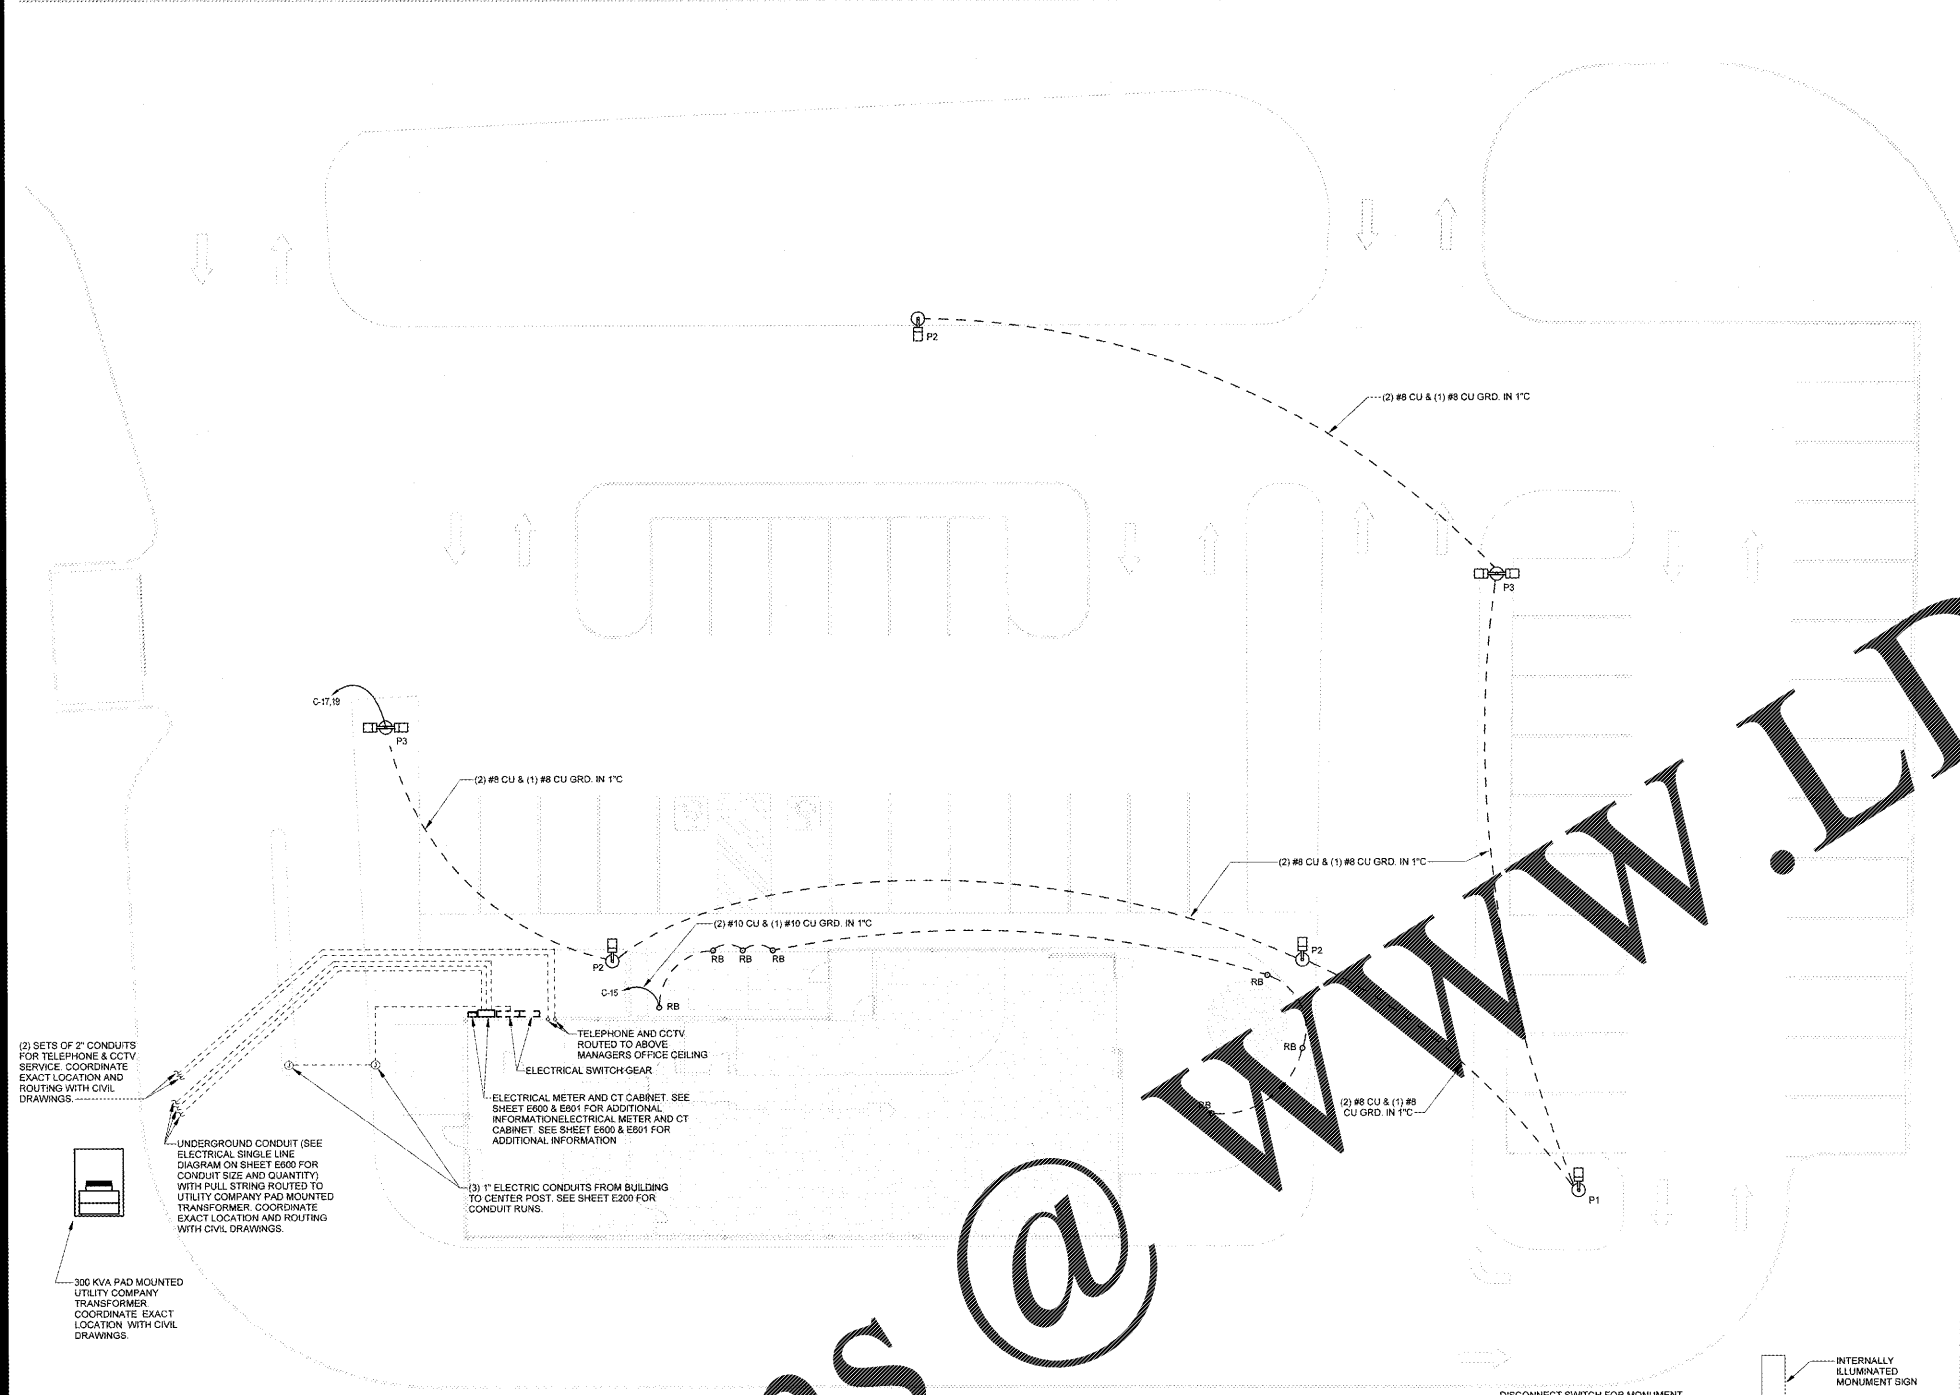


3 electrical site plan
SCALE | 3/32" = 1'-0"

GENERAL SITE PLAN NOTES

- CONDUIT RUNS ARE DYNAMIC. CONTRACTOR TO RUN CONDUIT ALONG PATH OF EAST REVISIONS IN ADDITION TO CALCULATED TAGS. WHEN CHOOSING WIRE SIZE FOR THE GIVEN PANEL.
- EXTRA FEES WILL BE PAID FOR ROCK BORING UNLESS OWNER'S REPRESENTATIVE AGREES THERE IS NO OTHER AVAILABLE.
- SEE FINAL SITE PLAN FOR LOCATION OF LOT LIGHTS AND PYLON SIGN.

TYPE MARK	MFR	CATALOG NO.	DESCRIPTION	MOUNTING	LAMP	VOLTAGE	WATTS	COMMENTS	REMARKS
P1	LITHONIA	08N1-LED-P1-40K-10K-MVOLT-SPA	NIGHTTIME FRIENDLY LED AREA LUMINAIRE	28'-0"	LED	208 V	102.00 VA	NO DIMMING	POLE LITHONIA LIGHTING CAT# SSS-28-4G-2M15-DRLC
P2	LITHONIA	08N1-LED-P2-40K-10K-MVOLT-4G	NIGHTTIME FRIENDLY LED AREA LUMINAIRE	28'-0"	LED	208 V	102.00 VA	NO DIMMING	POLE LITHONIA LIGHTING CAT# SSS-28-4G-2M15-DRLC
P3	LITHONIA	08N1-LED-P3-40K-10K-MVOLT-SPA	NIGHTTIME FRIENDLY LED AREA LUMINAIRE	28'-0"	LED	208 V	102.00 VA	NO DIMMING	POLE LITHONIA LIGHTING CAT# SSS-28-4G-2M15-DRLC
RB	ACILITY BRANES LIGHTING	3120C-HSR-8028-40K-MVOLT-FT-CPFL	3110 COVER ROLLARD FORWARD THROW DISTRIBUTION WITH COATED 1000 MH ED-17	SEE PLANS	LED	120 V	72.38 VA	NO DIMMING	CUSTOM GREEN FINISH

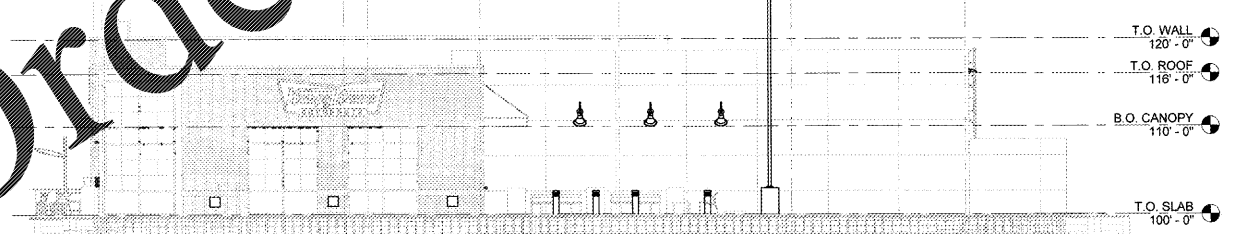

1 north elevation
SCALE | 1/8" = 1'-0"

Order Plans @

WWW.LDLine.com