


Order Plans @ WWW.LDILine.com

BLDG

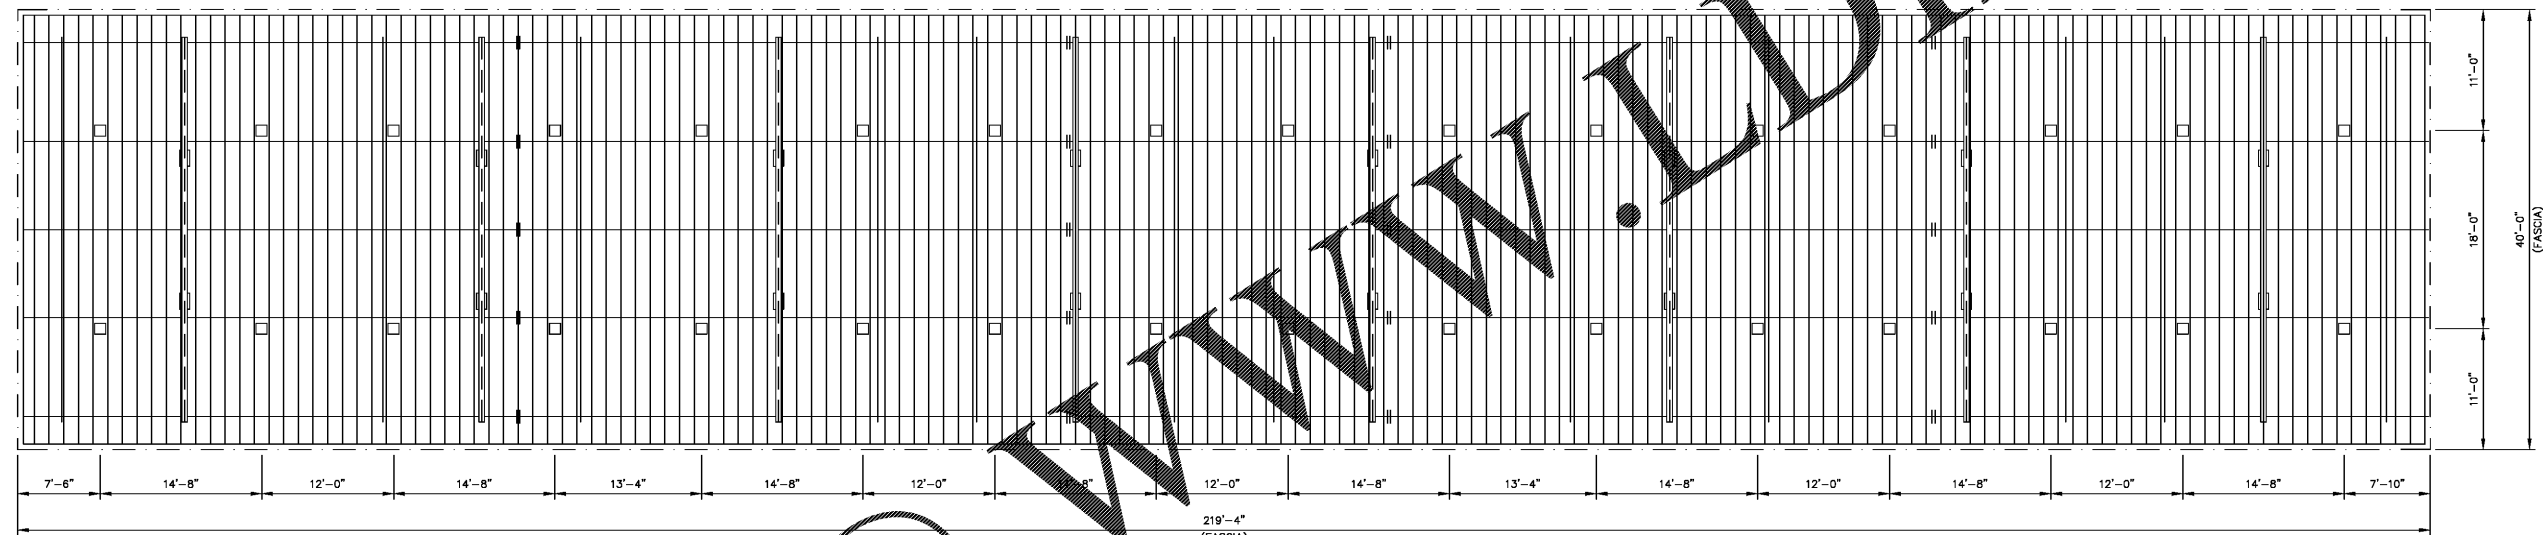

219'-4"
(FASCIA)
CANOPY LIGHTING LAYOUT
(32) LED LIGHT FIXTURES

LAWRENCE R. PILON/ PROFESSIONAL ENGINEER
51 MAPLEVIEW DRIVE/PENNELLSVILLE, NY 13132
(315) 668-0039

MCGEE
CORPORATION
12701 East Independence
Blvd. P.O. Box 1375
Matthews, NC 28106-1375
Phone: (704) 882-1500
Facts: (800) 528-5589

PR. JOB NO. 54661
FINAL JOB NO. 54661
DRAWING NO. P054661B
RACETRAC #1242
MLK PKWY & ZEBULON RD
GRIFFIN, GA 30223 (SPALDING)
SCALE: 1/8"=1'-0"
DATE: 8/24/17
IN ACCORDANCE WITH REV. LETTER: A
DRAWN BY: LLE
CHK'D BY:

These prints are the property of McGee Corp. Reproduction or reuse is prohibited without written permission.

METAL CANOPY 40'-0" x 219'-4"
LIGHTING LAYOUT PLAN
SHEET 3 OF 4

