


LIGHT FIXTURE SCHEDULE

MARK	LUMINAIRE		LAMP	VOLT	WATT	MOUNTING	FINISH	DESCRIPTION	FOOTNOTES
	MAKE	MODEL							
A	LITHONIA	EPANL 2X2 4000LM 80CRI 40K MIN10 ZT MVOLT	LED (INCLUDED)	277	31	LAY-IN	WHITE	LED TROFFER LIGHT, ACRYLIC LENS, 4000K, 80CRI, 4000 NOMINAL LUMENS	
BB	KICHLER	TREMILLO #49201 BK	SYLVANIA #LED16A21DIM083 SURP	120	16	WALL 7'-0"			3
X	LITHONIA	LQMS 3 R 120/277 ELN	LED (INCLUDED)	277 /120	1	--	BLACK	LED EXIT SIGN	1,2
XZ	LITHONIA	LHGM LED B R HO	LED (INCLUDED)	277 /120	4	--	BLACK	LED EXIT SIGN WITH REMOTE CAPACITY	1,2
YB	LITHONIA	ELMT 8 LP06VS LTP	LED (INCLUDED)	277 /120	19	--	BLACK	LED EMERGENCY LIGHT, LINEAR PATTERN, LITHIUM IRON PHOSPHATE BATTERY	1,2
Z	LITHONIA	ELA LEDT WP M12	LED (INCLUDED)	--	--	--	--	LED EMERGENCY REMOTE HEADS	1,2

- FOOTNOTES:**
- SEE S/E401, "EGRESS MOUNTING DETAIL".
 - CONNECT FIXTURE EMERGENCY BATTERY PACK TO UN-SWITCHED CONDUCTOR OF CIRCUIT INDICATED.
 - SEE ARCHITECTURAL ELEVATIONS FOR EXACT MOUNTING HEIGHTS.

- NOTES:**
- MOUNTING HEIGHTS TO BOTTOM OF FIXTURE UNLESS NOTED OTHERWISE.
 - PROVIDE FIXTURE SAFETY CHAINS WHERE REQUIRED.
 - ALL LAY-IN FIXTURES SHALL BE FURNISHED WITH "FIXTURE SUPPORT CLIPS" PER NEC SECTION 410.

4 LIGHTING CONTROL SCHEMATICS

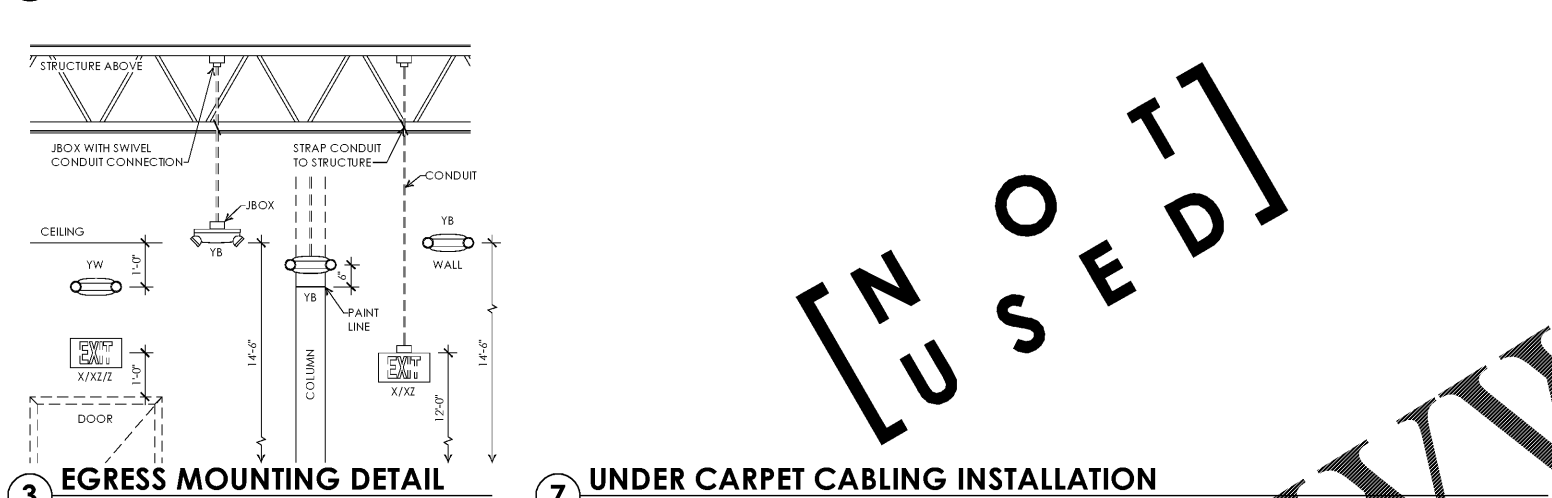

3 EGRESS MOUNTING DETAIL


SCALE: 1/2" = 1'-0"

7 UNDER CARPET CABLING INSTALLATION

SCALE: 1/4" = 1'-0"

2 TRACK MOUNTING DETAIL

SCALE: 1/2" = 1'-0"

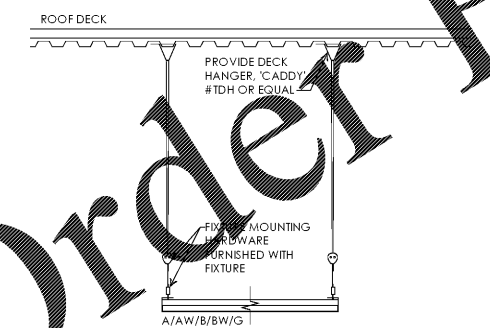

1 SUSPENDED MOUNTING DETAIL


SCALE: 1/2" = 1'-0"

6 JUNCTION BOX INSTALLATION

SCALE: 3/8" = 1'-0"

5 EXTERIOR SIGN ROUGH-IN

SCALE: 3/16" = 1'-0"

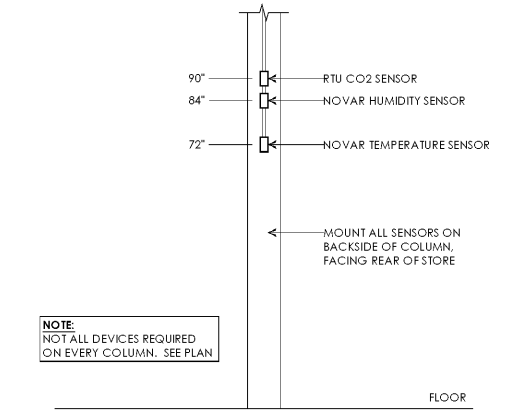

9 SENSOR MOUNTING DETAIL

SCALE: 1/2" = 1'-0"

10 FIRE ALARM RISER DIAGRAM

SCALE: NONE

ARCHITECTURAL DESIGN GUILD
 2100 S. Sullivan Blvd.
 St. Louis, MO 63143
 www.adg-stl.com
 P: 314.644.1234
 F: 314.644.4373
 C O F . # 3 2 7 8 6
 E X P . 2 / 2 8 / 2 0 1 9
 ALL ARCHITECTURAL AND ENGINEERING DRAWINGS ARE IN EXCLUSIVE AND EXCLUSIVE DESIGN AND MADE WITHOUT PRIOR WRITTEN CONSENT OF THE ARCHITECT. ALL COMMON LAW RIGHTS OF COPYRIGHT AND OTHERWISE ARE HEREBY SPECIFICALLY RESERVED

Office DEPOT OfficeMax
 6600 NORTH MILITARY TRAIL
 BOCA RATON, FL 33496
 PHONE: (561) 438-6299
 FAX: (561) 438-7237

Office DEPOT
 STORE #0409
 BOCA RATON, FL
 4901 N. FEDERAL HIGHWAY
 BOCA RATON, FL 33431
 ISSUE DATE: 11/09/2018
 STORE NUMBER: #0409
 LEASABLE AREA: 29,701 S.F.
 GROSS FLOOR AREA: 28,752 S.F.
 JOB NUMBER: 2018.012000

ISSUE	ISSUED FOR	DATE
		11/09/18

JOHN M. BRUNS
 LICENSE
 No. 54430
 STATE OF FLORIDA
 PROFESSIONAL ENGINEER
 JOHN M. BRUNS
 #54430 | EXP. 02/28/2019

SCHEDULES & DETAILS
 DRAWN: JEC
 CHECKED: JMB

E401

Order Plans@www.LDILine.com
 [NOT USED]