

CHATTANOOGA
CHRISTIAN SCHOOL



Chattanooga Christian School

CCS Gym Expansion
+ Spirit Store

Construction Documents

INDEX OF DRAWINGS

GENERAL	CIVIL	ARCHITECTURAL SITE	ARCHITECTURAL	STRUCTURAL	FIRE PROTECTION	PLUMBING	MECHANICAL	ELECTRICAL
G000 COVER SHEET	C-1.0 EROSION CONTROL PLAN	AC100 SITE PLAN	A001 DEMO PLANS	S100 STRUCTURAL PLANS, NOTES, + DTLs.	FP001 COVER SHEET	P001 COVER SHEET	M001 COVER SHEET	E001 COVER SHEET
G210 GYM EXPANSION CODE REVIEW + LIFE SAFETY	C-1.1 EROSION CONTROL DETAILS		A100 GYM ADDITION FOUNDATION PLAN	S101 STRUCTURAL METAL STUD FRAMING	FP101 SPRINKLER PLAN - GYM ADDITION	P101 WASTE & VENT - GYM ADDITION	M002 SPEC SHEET	E0101 DEMO PLAN
G220 SPIRIT SHOP CODE REVIEW + LIFE SAFETY	C-2.0 SITE PLAN		A110 GYM ADDITION FLOOR PLAN		FP102 SPRINKLER PLAN - SPIRIT SHOP	P102 WASTE & VENT - SPIRIT SHOP	MD101 DEMO PLAN	E101 LIGHTING PLAN - GYM ADDITION
G300 WALL TYPES	C-3.0 GRADING AND DRAINAGE PLAN		A120 SPIRIT SHOP FLOOR PLAN			P201 DOMESTIC & GAS - GYM ADDITION	M101 HVAC PLAN - GYM ADDITION	E102 LIGHTING PLAN - SPIRIT SHOP
	C-4.0 MISC. DETAILS		A210 GYM ADDITION DOOR SCHEDULE AND DETAILS				M102 HVAC PLAN - SPIRIT SHOP	E201 POWER PLAN - GYM ADDITION
	C-5.0 CIVIL SITE MISC. DETAILS		A220 SPIRIT SHOP DOOR SCHEDULE AND DETAILS				M400 SCHEDULES	E202 POWER PLAN - SPIRIT SHOP
			A231 GYM ADD. STOREFRONT ELEV. AND DETAILS				M500 DETAILS	E300 SCHEDULES AND DIAGRAMS
							M600 CONTROLS	

ARCHITECT:



franklin | architects

142 N Market Street P.O. Box 4048
Chattanooga, TN . 37405
v: 423.266.1207 f: 423.266.1216

CIVIL ENGINEER:


MILLER + McCOY, INC.
CONSULTING ENGINEERS
915 CREEKSIDE ROAD CHATTANOOGA, TENNESSEE 37406
PHONE (423) 698-2661 FAX (423) 698-2664

STRUCTURAL ENGINEER:

BILL KINNAMAN, P.E.

3756 Ringgold Road
Chattanooga, TN 37412
v: 423.698.4376

MEP ENGINEER

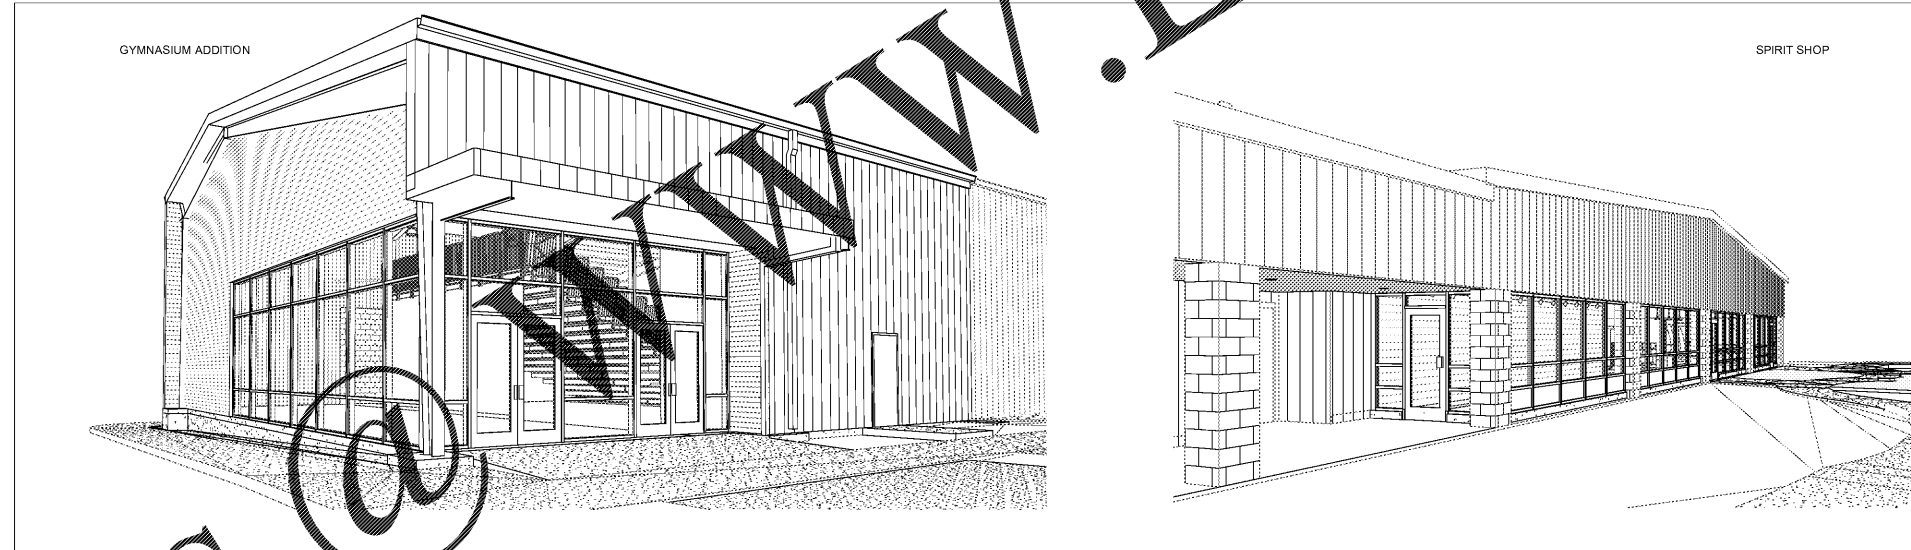

ABBREVIATIONS

ABV	ABOVE
ACT	ACOUSTICAL TREATMENT
AL	ALUMINUM
BL	BLOCK
BLC	BLOCK
BLK	BRICK
CE	CERAMIC
CL	CEILING
CL	CENTERLINE
CMU	CONCRETE MASONRY UNITS
CO	CASED OPENING
COL	COLUMN
CONC	CONCRETE
CONT	CONTINUOUS
CPT	CARPET
CT	CERAMIC TILE
EIFS	EXTERIOR INSULATION & FINISH SYSTEM
EXG	EXISTING
EXP	EXPOSED
FEC	FIRE EXTINGUISHER CABINET
FRP	FIBERGLASS REINFORCED PANEL
GWB	GYP SUM WALLBOARD
GYP	GYP SUM
HGT	HEIGHT
HM	HOLLOW METAL
HORIZ	HORIZONTAL
MATL	MATERIAL
NIC	NOT INCLUDED IN CONTRACT
PRE	PREFINISHED
PLAM	PLASTIC LAMINATE
PNT	PAINT
PT	PORCELAIN TILE
PWD	PLYWOOD
QT	QUARRY TILE
REIN	REINFORCEMENT
RB	RUBBER BASE
ST	STAIN
SV	SHEET VINYL
TBS	TO BE SELECTED
TYP	TYPICAL
UNO	UNLESS NOTED OTHERWISE
VCT	VINYL COMPOSITION TILE
WD	WOOD
VERT	VERTICAL
WWF	WELDED WIRE FABRIC

MATERIALS


	BRICK
	CMU
	STEEL
	BATT INSULATION
	RIGID INSULATION
	WOOD, FINISH
	WOOD, ROUGH FRAMING
	PLYWOOD
	CONCRETE
	ASPHALT PAVING
	GYP SUM BOARD
	STONE
	EARTH
	CRUSHED STONE

REFERENCE SYMBOLS

NAME	SYMBOL	DESCRIPTION	NAME	SYMBOL	DESCRIPTION
BUILDING SECTION MARK		DRAWING NUMBER	WINDOW TAG		WINDOW TYPE
WALL SECTION MARK		SHEET NUMBER	HEIGHT INDICATION		HEIGHT ABOVE FINISH FLOOR
EXTERIOR ELEVATION MARK		DRAWING NUMBER	SIGNAGE TAG		SIGNAGE TYPE
INTERIOR ELEVATION MARK		DRAWING NUMBER	TOILET ACCES. TAG		ACCESSORY TYPE
ENLARGED DRAWING/DETAIL TAG		DRAWING NUMBER	CASEWORK TAG		CASEWORK TYPE
ROOM TAG		ROOM NAME	CASEWORK TAG		WIDTH IN INCHES
DOOR TAG		DOOR NUMBER	CEILING TAG		CEILING TYPE
WALL TAG		PARTITION TYPE	CEILING TAG		HEIGHT ABOVE FINISH FLOOR
REVISION TAG		REVISION NUMBER	FINISH INDICATION		FINISH ABBREVIATION
			DISPLAY BOARD TAG		DISPLAY BOARD TYPE
					MARKERBOARD
					TACKBOARD
					SMART BOARD

TYPICAL NOTES:
DIMENSIONS ARE FROM FACE OF MASONRY OR CONCRETE WALLS, TO OUTSIDE FACE OF EXTERIOR STUD OF EXTERIOR WALLS, AND FACE OF STUD (ONE SIDE ONLY) OF INTERIOR STUD WALLS. OPENINGS IN STUD WALLS ARE DIMENSIONED TO CENTER OF OPENING. OPENINGS IN MASONRY WALLS ARE DIMENSIONED TO MASONRY OPENING.

VICINITY MAP

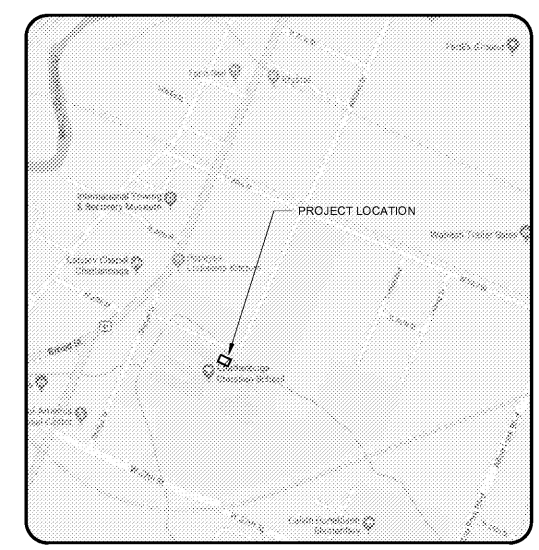

franklin | architects
142 N Market Street P.O. Box 4048
Chattanooga, TN . 37405
v: 423.266.1207 f: 423.266.1216


In association with:

CCS Gym
Expansion + Spirit
Store
for
**Chattanooga
Christian School**



3354 Charger Dr.
Chattanooga, TN 37409

This drawing is the property of
Franklin Associates Architects Inc.
Any use, reuse, reproduction, display
or sale of this drawing without the
express written consent of the Architect
is strictly prohibited.

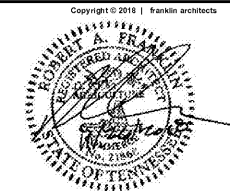

Construction
Documents

Revisions		
No.	Issue	Date

Sheet Information

Date 11/26/18
Job No. 6774.3 / 6774.4

 
Title

GENERAL

COVER SHEET

Sheet

G000



Last Plotted: 11/26/2018 1:53:03 PM