

ELECTRICAL SHEET NOTES - UNREFERENCED

- a. ALL EMERGENCY AND EXIT LIGHTING SHALL BE PROVIDED WITH A CONSTANT HOT AHEAD OF ANY SWITCHES/RELAYS/CONTACTORS. USE SAME CIRCUIT AS NORMAL LIGHTING IN THE AREA.

ELECTRICAL SHEET NOTES - REFERENCED

- ① LIGHTING IN RESTROOMS SHALL UTILIZE EXISTING CIRCUITS AND CONTROLS.
- ② UTILIZE EXISTING LIGHTING CIRCUIT MADE AVAILABLE DURING DEMO.
- ③ INSTALL NEW SWITCH AND SWITCH LEG TO ACCOMMODATE REMOVAL AND RELOCATION OF WALL.
- ④ USE EXISTING CIRCUIT AND MADE AVAILABLE DURING DEMO FOR EXTERIOR LIGHTING. PROVIDE NEW PHOTOCELL FOR OPERATION.

franklin | architects
 1415 Market Street P.O. Box 4048
 Chattanooga, TN 37405
 V: 423.266.1207 F: 423.266.1216

In association with:

Project No. 150-18

A.E.E.D., inc.
 Advanced Energy
 Engineering & Design, Inc.
 408 McCalle Ave
 Chattanooga, TN 37402
 www.aeedinc.com
 (423) 752-3438


**CCS Gym
 Expansion + Spirit
 Store**

for
**Chattanooga
 Christian School**



3354 Charger Dr.
 Chattanooga, TN 37409

This drawing is the property of
 Franklin Associates Architects Inc.
 Any use, reuse, reproduction, display
 or sale of this drawing without the
 express written consent of the Architect
 is strictly prohibited.

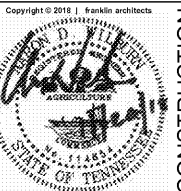

CONSTRUCTION
 DOCUMENTS

Revisions		
No.	Issue	Date

Sheet Information	
Date	11.26.2018
Job No.	6774.3 / 6774.4

Title

ELECTRICAL


**LIGHTING PLAN -
 GYM ADDITION**

Sheet

E101



ORIENTATION

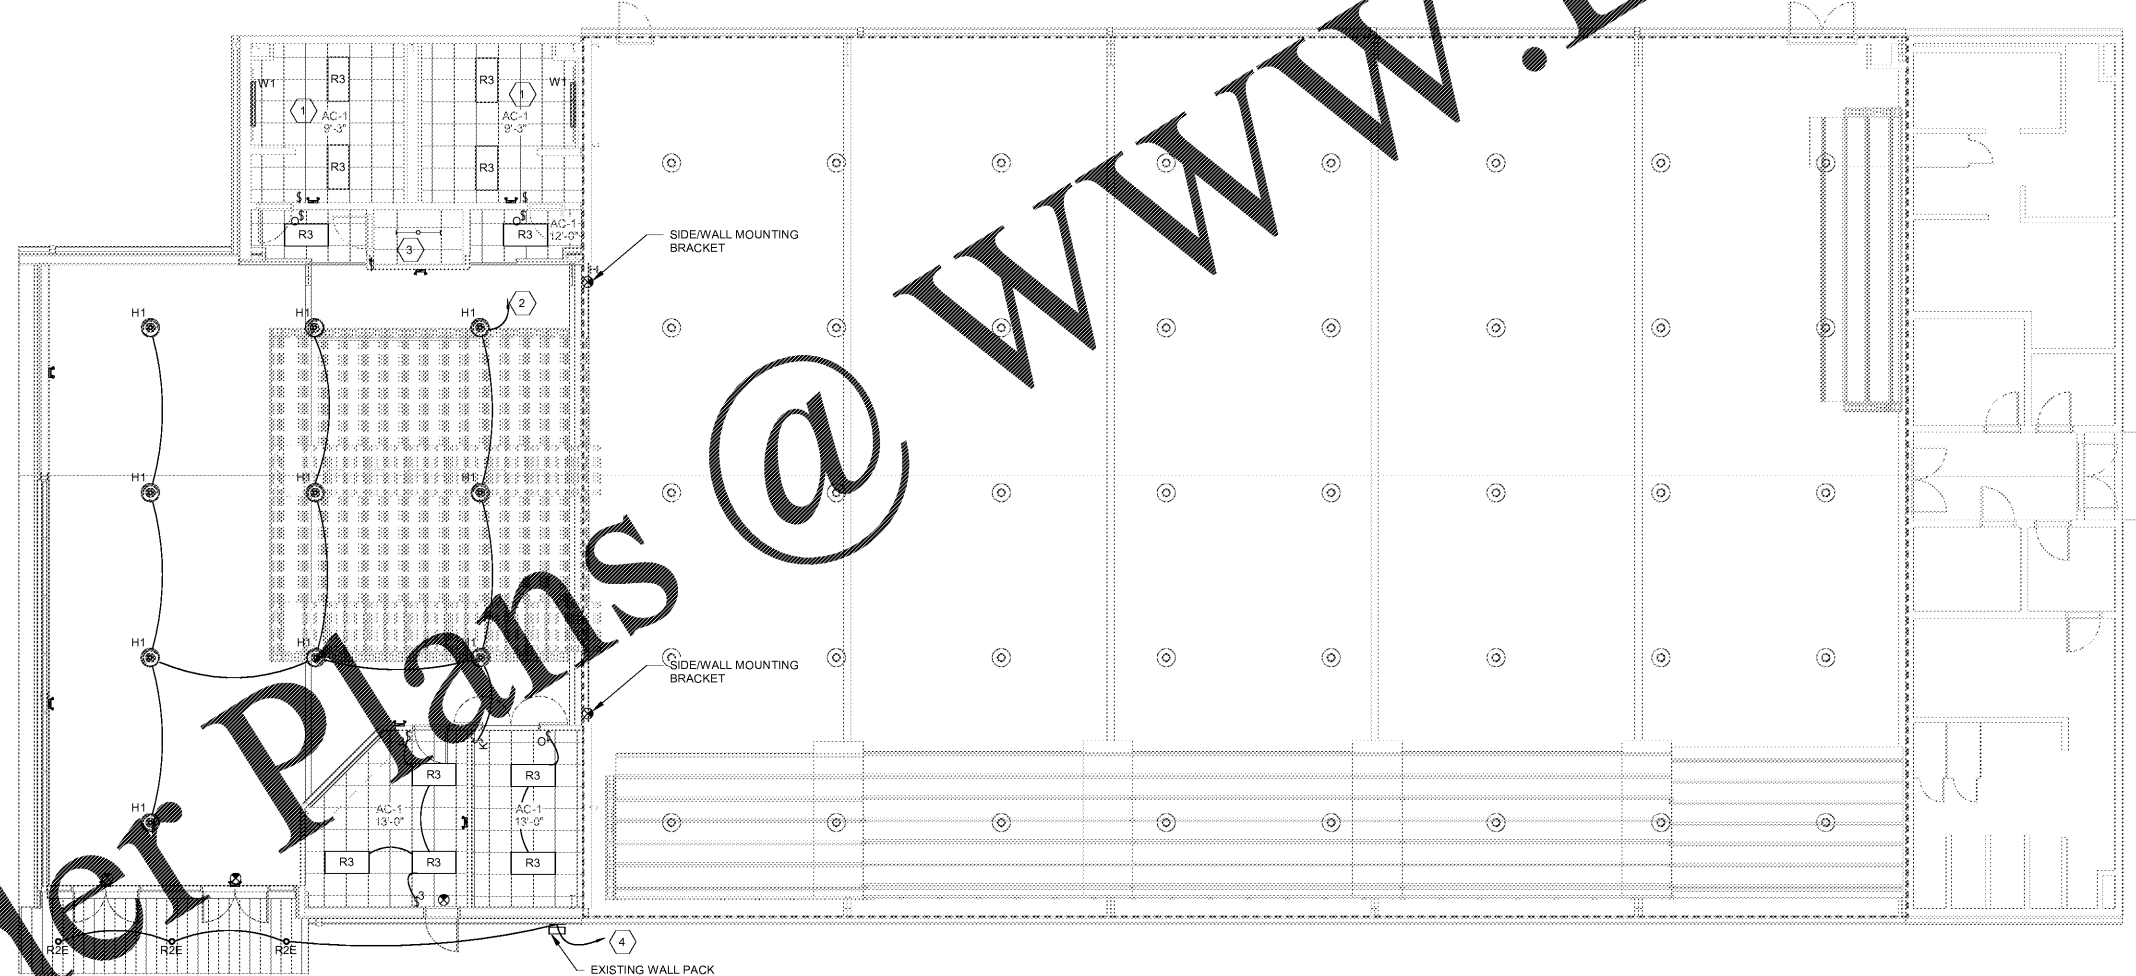

① Electrical - Lighting - Gym Addition
 1/8" = 1'-0"

Last Plotted: 11/27/2018 8:25:03 AM

Order Plans @

www.LDILine.com