

ELECTRICAL SHEET NOTES - UNREFERENCED

- a. ALL EMERGENCY AND EXIT LIGHTING SHALL BE PROVIDED WITH A CONSTANT HOT AHEAD OF ANY SWITCHES/RELAYS/CONTACTORS. USE SAME CIRCUIT AS NORMAL LIGHTING IN AREA.

ELECTRICAL SHEET NOTES - REFERENCED

- (1) TIE CANOPY/SOFFIT LIGHTS INTO EXISTING CIRCUIT UTILIZING EXISTING TIMECLOCK CONTROL.

franklin architects
 141 Mark Street P.O. Box 4048
 Chattanooga, TN 37405
 v: 423.266.1207 f: 423.266.1216

In association with:

Project No. 150-18

A.E.E.D., inc.
 Advanced Energy
 Engineering & Design, Inc.
 408 McCalle Ave
 Chattanooga, TN 37402
 www.aeedinc.com
 (423) 752-3438

**CCS Gym
 Expansion + Spirit
 Store**

for
**Chattanooga
 Christian School**



3354 Charger Dr.
 Chattanooga, TN 37409

This drawing is the property of
 Franklin Associates Architects Inc.
 Any use, reuse, reproduction, display
 or sale of this drawing without the
 express written consent of the Architect
 is strictly prohibited.

Copyright © 2018 | franklin architects



CONSTRUCTION DOCUMENTS

Revisions

No.	Issue	Date

Sheet Information

Date 11.26.2018

Job No. 6774.3 / 6774.4


Title

ELECTRICAL

**LIGHTING PLAN -
 SPIRIT SHOP**

Sheet

E102

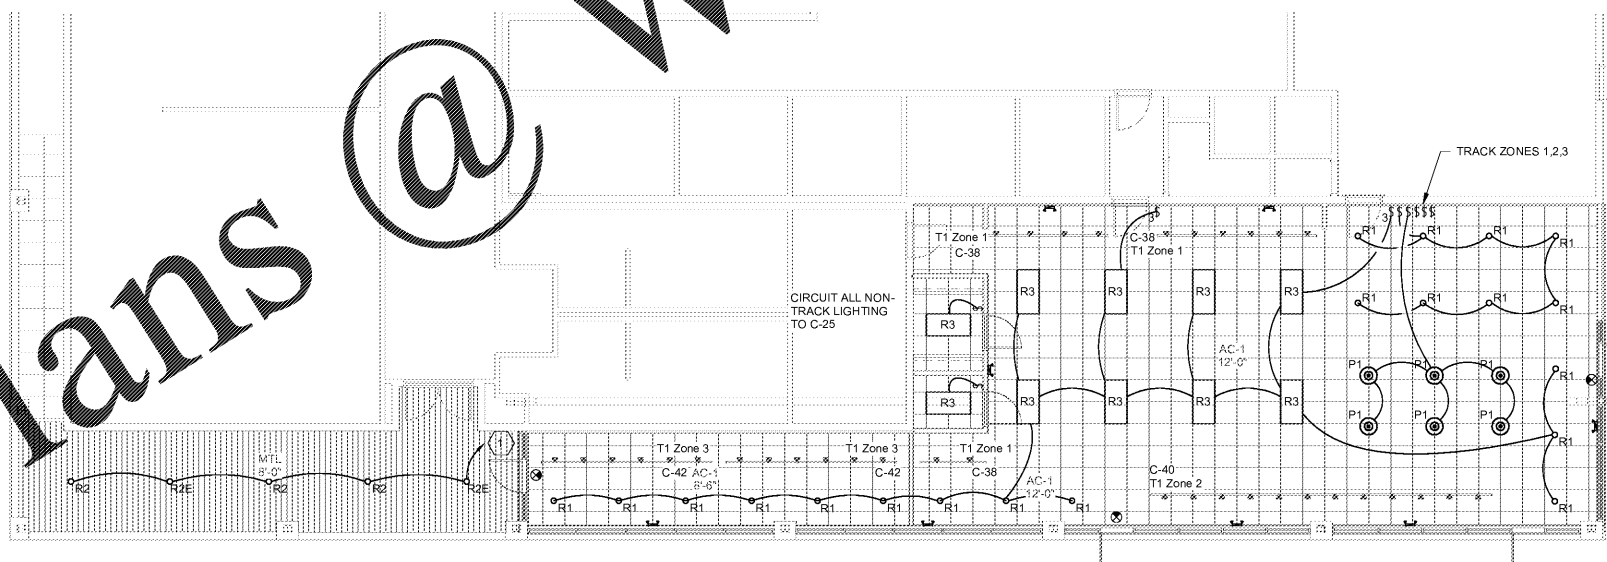

(1) Electrical - Lighting - Spirit Shop
 1/8" = 1'-0"

Order Plans @

WWW.LDILine.com