

**ELECTRICAL SHEET NOTES - UNREFERENCED**

a. TIE IN NEW FIRE ALARM DEVICES TO EXISTING SYSTEM. PROVIDE ALL NECESSARY COMPONENTS FOR A COMPLETE SYSTEM, INCLUDING REMOTE POWER SUPPLIES, ZONE MODULES, ETC. EXISTING SYSTEM DOES NOT UTILIZE VOICE EVACUATION AND THE INTENT IS TO LEAVE THE EXISTING SYSTEM IN OPERATION.

**ELECTRICAL SHEET NOTES - REFERENCED**

- ① POS. PROVIDE 1" CONDUIT FROM MILLWORK TO WALL AND UP TO CEILING SPACE FOR COMM WIRING.
- ② EXISTING LOAD CENTER RELOCATED FROM DEMOED CONCESSIONS STAND. INTERCEPT FEEDERS AT CEILING AND EXTEND OVER FROM EXISTING LOCATION.
- ③ UTILIZE EXISTING CIRCUIT MADE AVAILABLE DURING DEMO.
- ④ PROVIDE 120/1 POWER FOR HAND DRYER.
- ⑤ PROVIDE 208/120V 3 PH, 4W POWER FOR BLEACHER MOTOR (4#12 & #12 G IN 3/4" C. POWER TERMINATES AT JUNCTION UNDER FIRST RIER. COORDINATE WITH SUPPLIER/INSTALLER EXACT LOCATION AND REQUIREMENTS PRIOR TO ROUGH-IN. SAW CUT AND PATCH FLOOR AS REQUIRED.

**franklin | architects**  
 1411 Market Street P.O. Box 4048  
 Chattanooga, TN 37405  
 v: 423.266.1207 f: 423.266.1216

In association with:

Project No. 150-18

**A.E.E.D., inc.**  
 Advanced Energy  
 Engineering & Design, Inc.  
 408 McCalle Ave  
 Chattanooga, TN 37402  
 www.aeedinc.com  
 (423) 752-3438

**CCS Gym  
 Expansion + Spirit  
 Store**

for  
**Chattanooga  
 Christian School**



3354 Charger Dr.  
 Chattanooga, TN 37409

This drawing is the property of  
 Franklin Associates Architects Inc.  
 Any use, reuse, reproduction, display  
 or sale of this drawing without the  
 express written consent of the Architect  
 is strictly prohibited.



CONSTRUCTION DOCUMENTS

Revisions		
No.	Issue	Date

Sheet Information	
Date	11.26.2018
Job No.	6774.3 / 6774.4

Title

**ELECTRICAL**


**POWER PLAN - GYM  
 ADDITION**

Sheet

**E201**



ORIENTATION

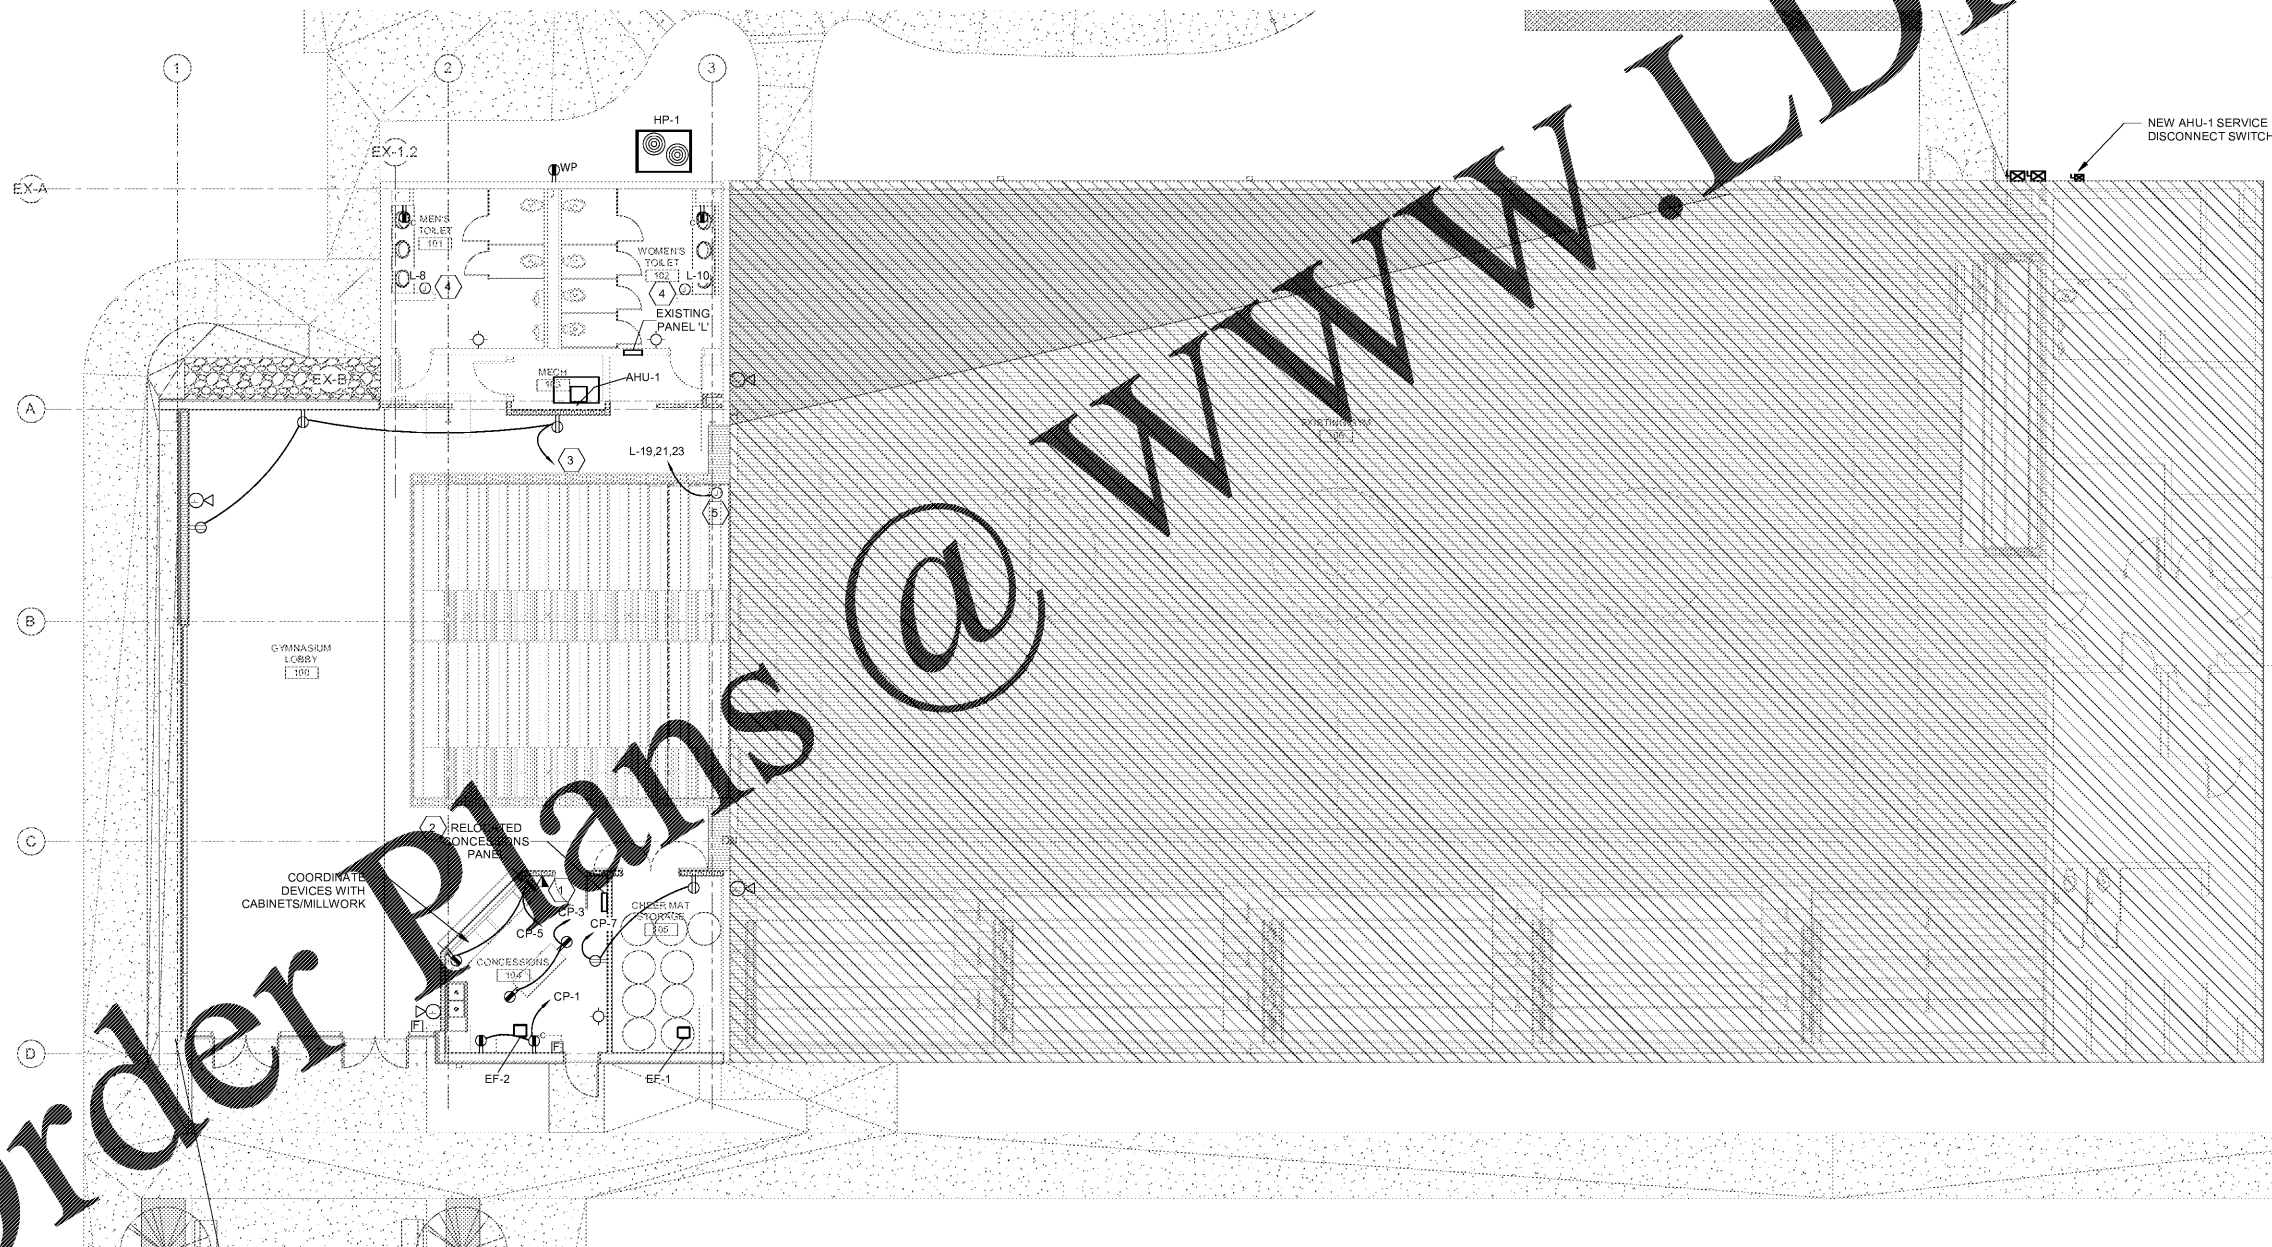

① Electrical - Power - Gym Addition  
 1/8" = 1'-0"

Last Plotted: 11/27/2018 8:25:13 AM

Order Plans

@

www.LDILine.com