

ELECTRICAL SHEET NOTES - UNREFERENCED
 a. TIE IN NEW FIRE ALARM DEVICES TO EXISTING SYSTEM. PROVIDE ANY NECESSARY COMPONENTS FOR A COMPLETE SYSTEM.

ELECTRICAL SHEET NOTES - REFERENCED
 (1) POS. PROVIDE 1" CONDUIT FROM MILLWORK TO WALL AND UP TO CEILING SPACE FOR COMM WIRING.

franklin|architects
 1411 Market Street P.O. Box 4048
 Chattanooga, TN 37405
 V: 423.266.1207 F: 423.266.1216

In association with:
 Project No. 150-18


A.E.E.D., inc.
 Advanced Energy
 Engineering & Design, Inc.
 408 McCalle Ave
 Chattanooga, TN 37402
 www.aeedinc.com
 (423) 752-3438

**CCS Gym
 Expansion + Spirit
 Store**
 for
**Chattanooga
 Christian School**



3354 Charger Dr.
 Chattanooga, TN 37409

This drawing is the property of
 Franklin Associates Architects Inc.
 Any use, reuse, reproduction, display
 or sale of this drawing without the
 express written consent of the Architect
 is strictly prohibited.

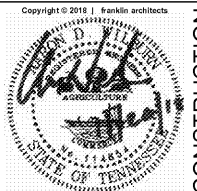

CONSTRUCTION DOCUMENTS


Revisions		
No.	Issue	Date

Sheet Information	
Date	11.26.2018
Job No.	6774.3 / 6774.4
Title	

ELECTRICAL
**POWER PLAN - SPIRIT
 SHOP**

Sheet
E202

① Electrical - Power - Spirit Shop
 1/8" = 1'-0"

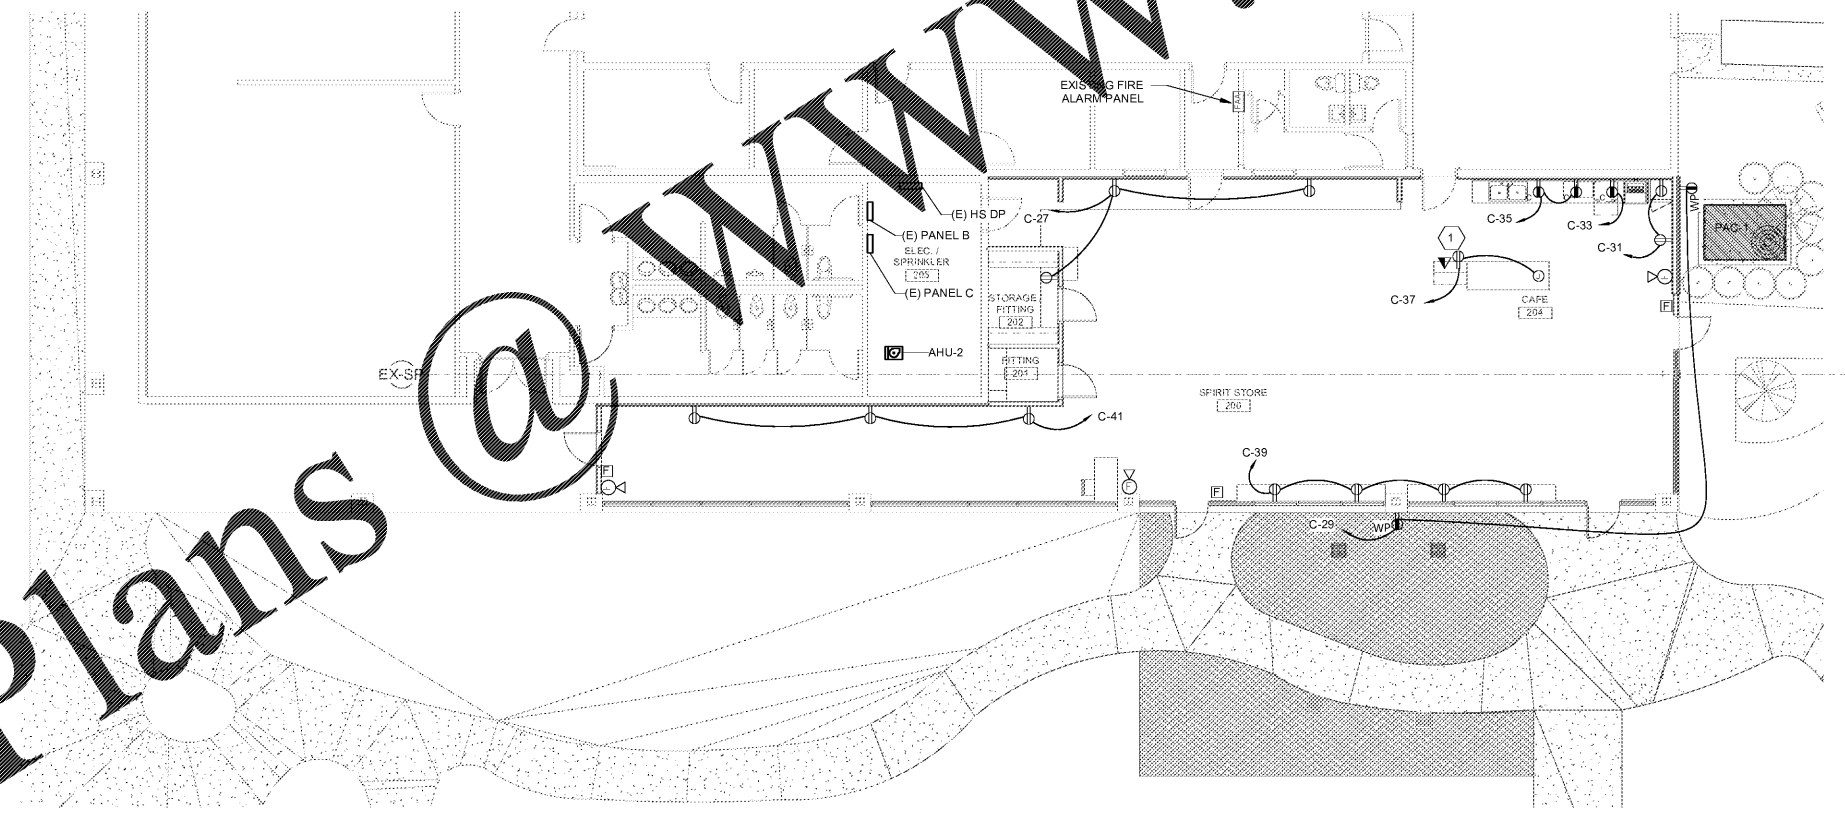

WWW.LDILine.com

Order Plans @

