



© Copyright (as dated below)
 This drawing and all reproductions thereof are the property of
 Hill Foley Rossi & Associates, LLC (HFR). It is intended for the
 use of the project named herein. Reproduction without the
 written consent of HFR is prohibited. All copies are to be
 returned to HFR upon project completion.

ISSUE/REVISION RECORD

DATE	DESCRIPTION
10/18/18	ISSUED FOR PERMIT
10/18/18	PERMIT COMMENTS

RaceTrac

RACETRAC PETROLEUM, INC.
 200 GALLERIA PARKWAY SOUTHEAST
 SUITE 900
 ATLANTA, GEORGIA 30339
 (770) 431-7600

PROJECT NAME

**PEACHTREE
 PKWY & ENG.**

PEACHTREE
 CORNERS

5780 PEACHTREE PKWY
 PEACHTREE CORNERS, GA

RACETRAC STORE NUMBER

1201

PROTOTYPE SERIES 5.5K 2.0

2018 RH MO

PLAN MODIFICATION NOTICE

SPB NO.	DATE

STANDARD PLAN BULLETINS (SPB) MODIFY THE
 PROTOTYPE SERIES SET NOTED ABOVE. THE
 LISTED SPB REPRESENTS THE LATEST
 MODIFICATION INCORPORATED TO THIS
 PROTOTYPE SERIES SET AT ORIGINAL RELEASE.
 THE ISSUE/REVISION RECORD COLUMN ABOVE
 LISTS ANY REVISIONS OR SPB INCORPORATED IN
 THIS SET AFTER THE ORIGINAL RELEASE.
 CONTACT RACETRAC ENGINEERING AND
 CONSTRUCTION FOR ANY SUBSEQUENT
 BULLETINS NOT INCORPORATED HEREIN.

PROFESSIONAL SEAL



10/18/18

PROJECT NUMBER

18.703.00

SHEET TITLE

**SITE PHOTOMETRY
 PLAN**

SHEET NUMBER

SP-1

ISSUED FOR PERMIT

GENERAL NOTES


1. MOUNT AREA LUMINAIRE TYPES 'D' & 'E' AT 28'-0" APG (INCLUDING POLE BASE)
2. MOUNT ROADWAY LUMINAIRE TYPE 'H' AT 35'-0" APG (INCLUDING POLE BASE)

STATISTICS

Description	Symbol	Avg	Min	Max/Min	Avg/Min
Beyond Property	+	0.0 fc	0.3 fc	0.0 fc	N/A
Fuel Canopy	□	19.8 fc	19.8 fc	4.7 fc	2.0:1
Empty Dr	+	1.1 fc	0.0 fc	N/A	N/A
Peachtree	+	17.7 fc	3.3 fc	0.7 fc	4.7:1
	+	4.1 fc	1.8 fc	0.4 fc	4.5:1

LUMINAIRE SCHEDULE

Symbol	Qty	Catalog Number	Description	Lamp	File	Lumens	LLF	Watts
□	28	WCP03L-D4-W-50	LED CANOPY LIGHT	LIGHT EMITTING DIODES	WCP03L-D4-W-50 IS	3481	0.90	25
○	2	A2B1-05	WITH WHITE TRIM AND RECESSED WHITE PLASTIC LENS	LED5 LUMEN RATING #680 LMS	LR6 IS	647	0.90	115
○	9	SP2-STR-V4-2050 -FCO-MDQKB-12 LED-08	SPECTRA FIXTURE	12 LED ARRAY	SP2-STR-V4-2050 -FCO-MDQKB-12 LED-08 IS	2047	0.90	27.3
□	4	XALM-2-LED-VHO-50-L	LED AREA LIGHT WITH BACKLIGHT CONTROL	LIGHT EMITTING DIODES	XALM-2-LED-VHO50-L IS	25413	0.90	313.6
□	2	XALM-FT-LED-VHO-50-L	LED AREA LIGHT WITH BACKLIGHT CONTROL	LIGHT EMITTING DIODES	XALM-FT-LED-VHO50-L IS	26028	0.90	315
□	3	XWM-FT-LED-04-50	LED WALL PACK	LIGHT EMITTING DIODES	XWM-FT-LED-04-50 IS	4509	0.90	38
□	17	BXSP-CXX-3MEF JLL WITH XA-SPBLS	CONFIGURED FROM XSP JLL WITH XA-SPBLS	CONFIGURED FROM 5MDA	BXSP-CXX-3ME-FJLL WITH XA-SPBLS CONFIGURED IS	11745	0.90	139

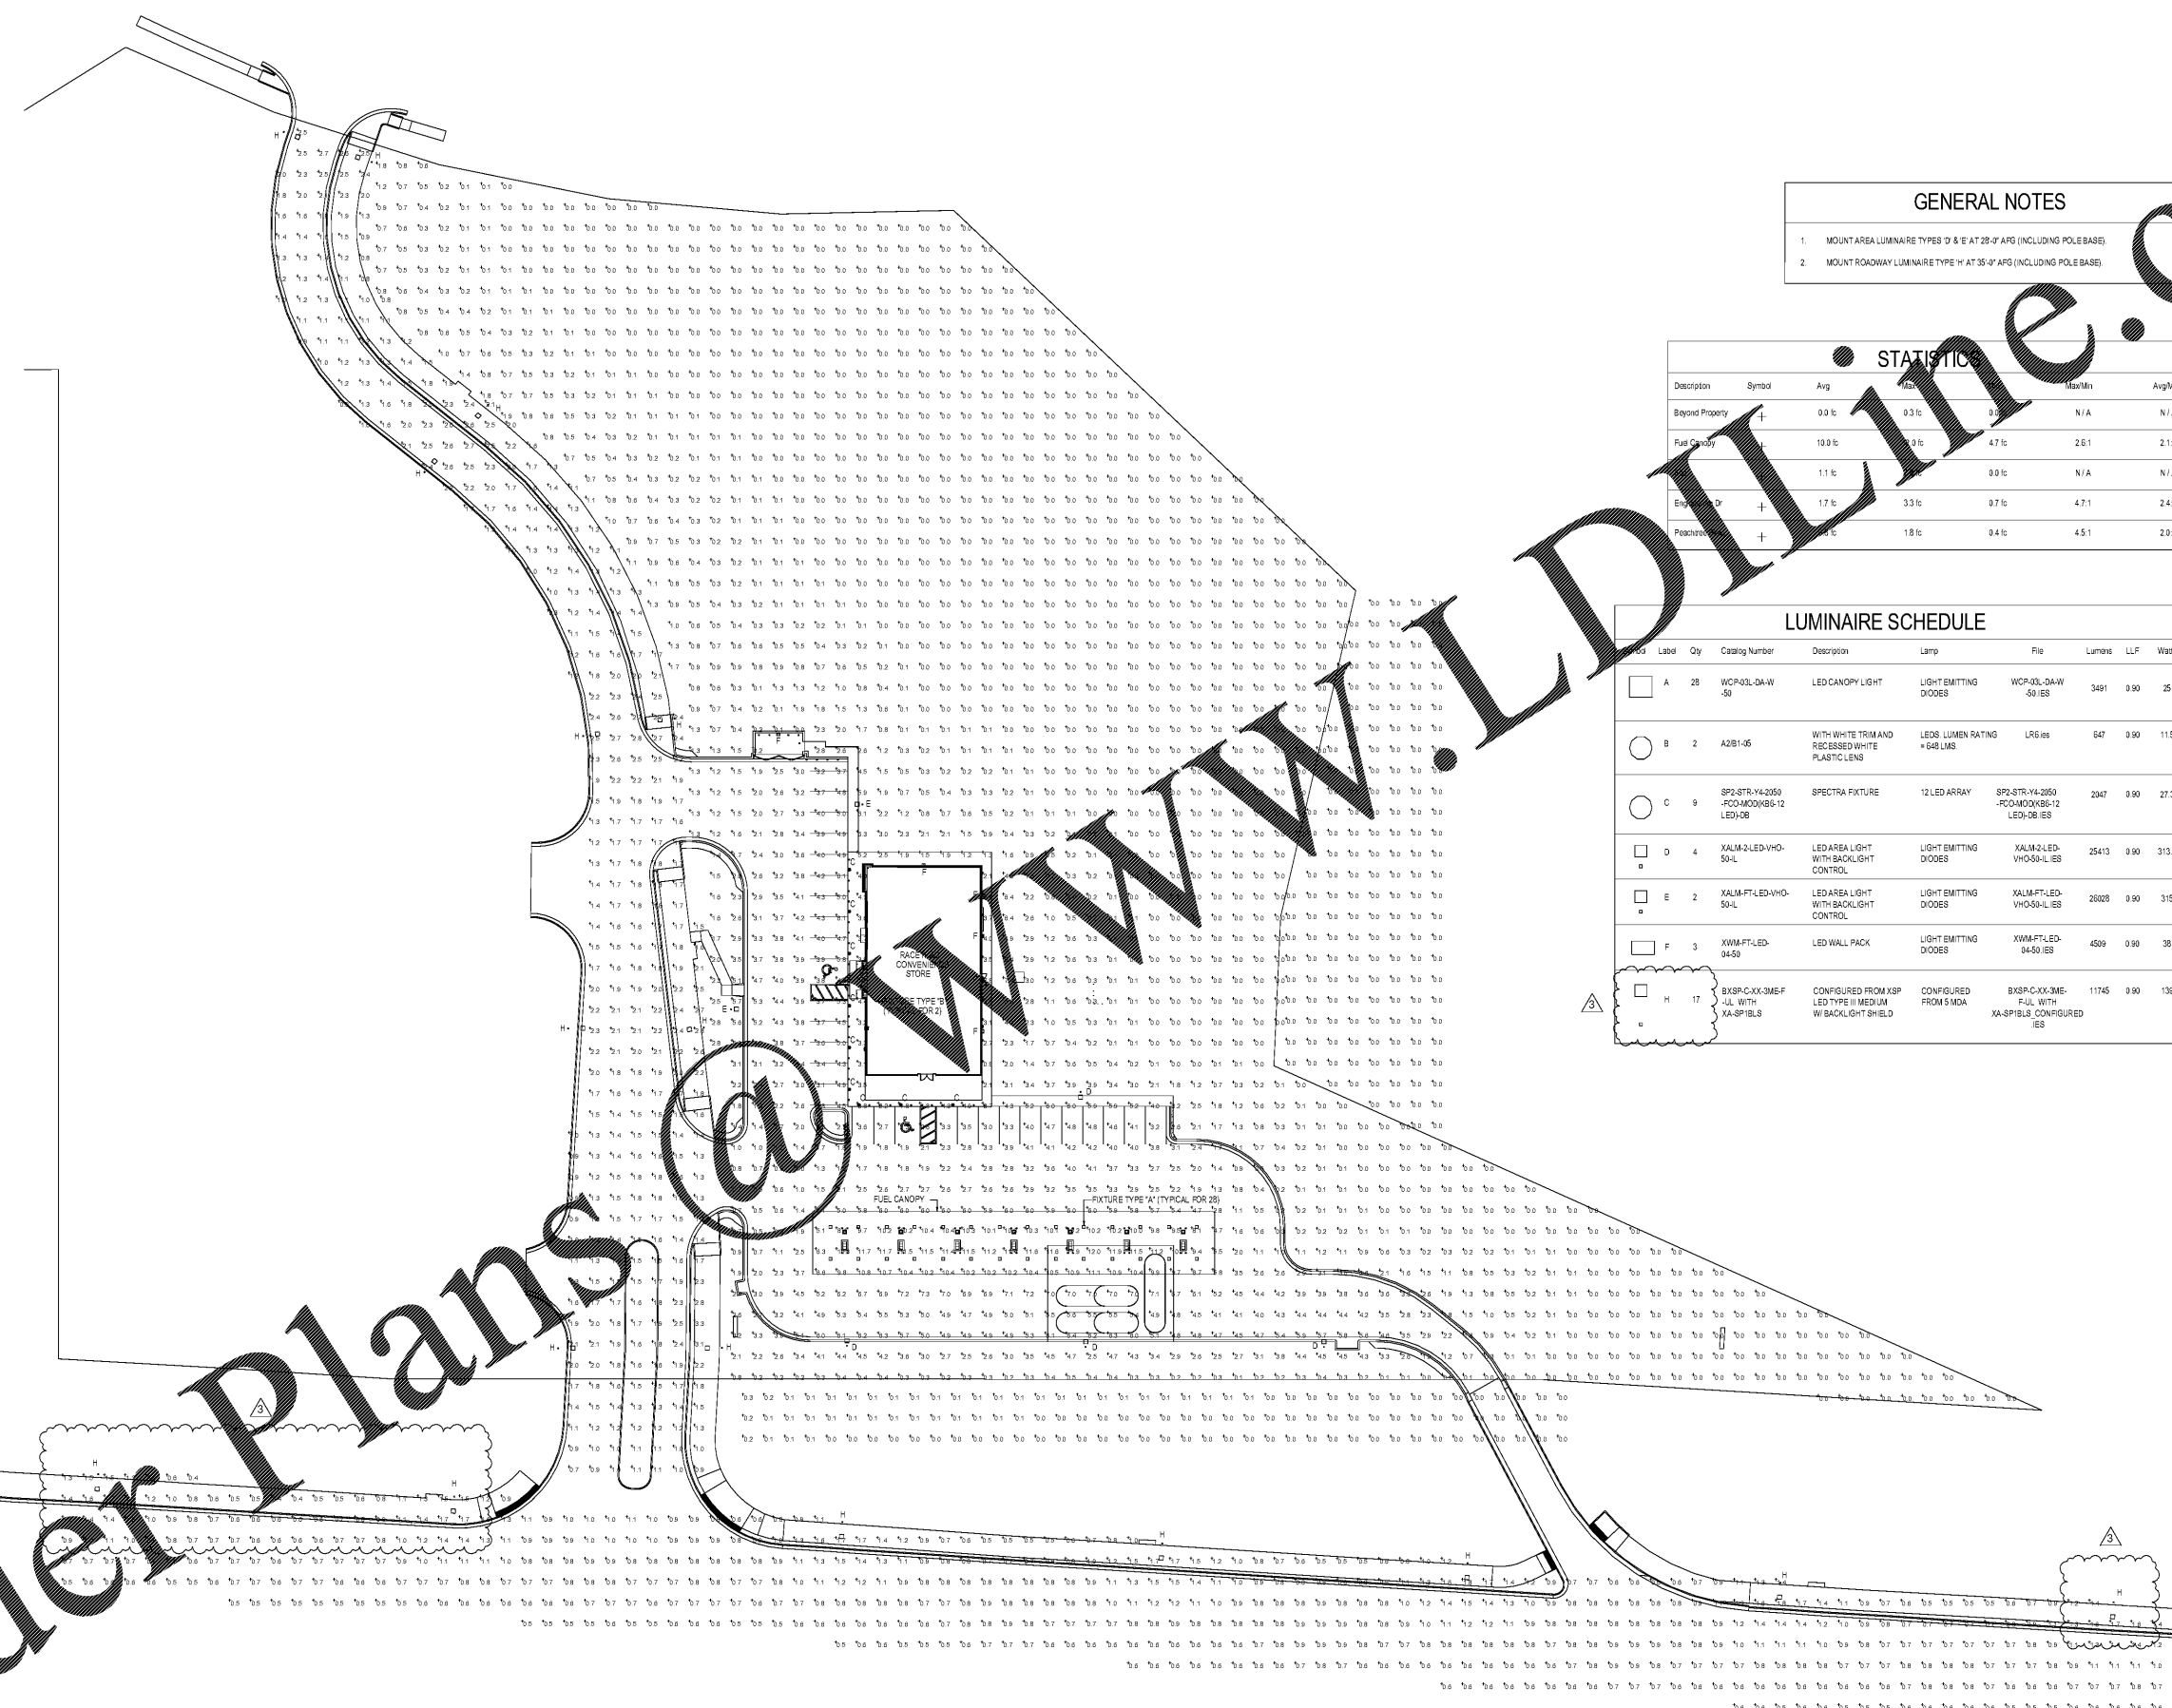

1 SITE PHOTOMETRY PLAN
 SCALE: 1" = 40'

Order Plans @
 www.lidline.com