


Order Plans

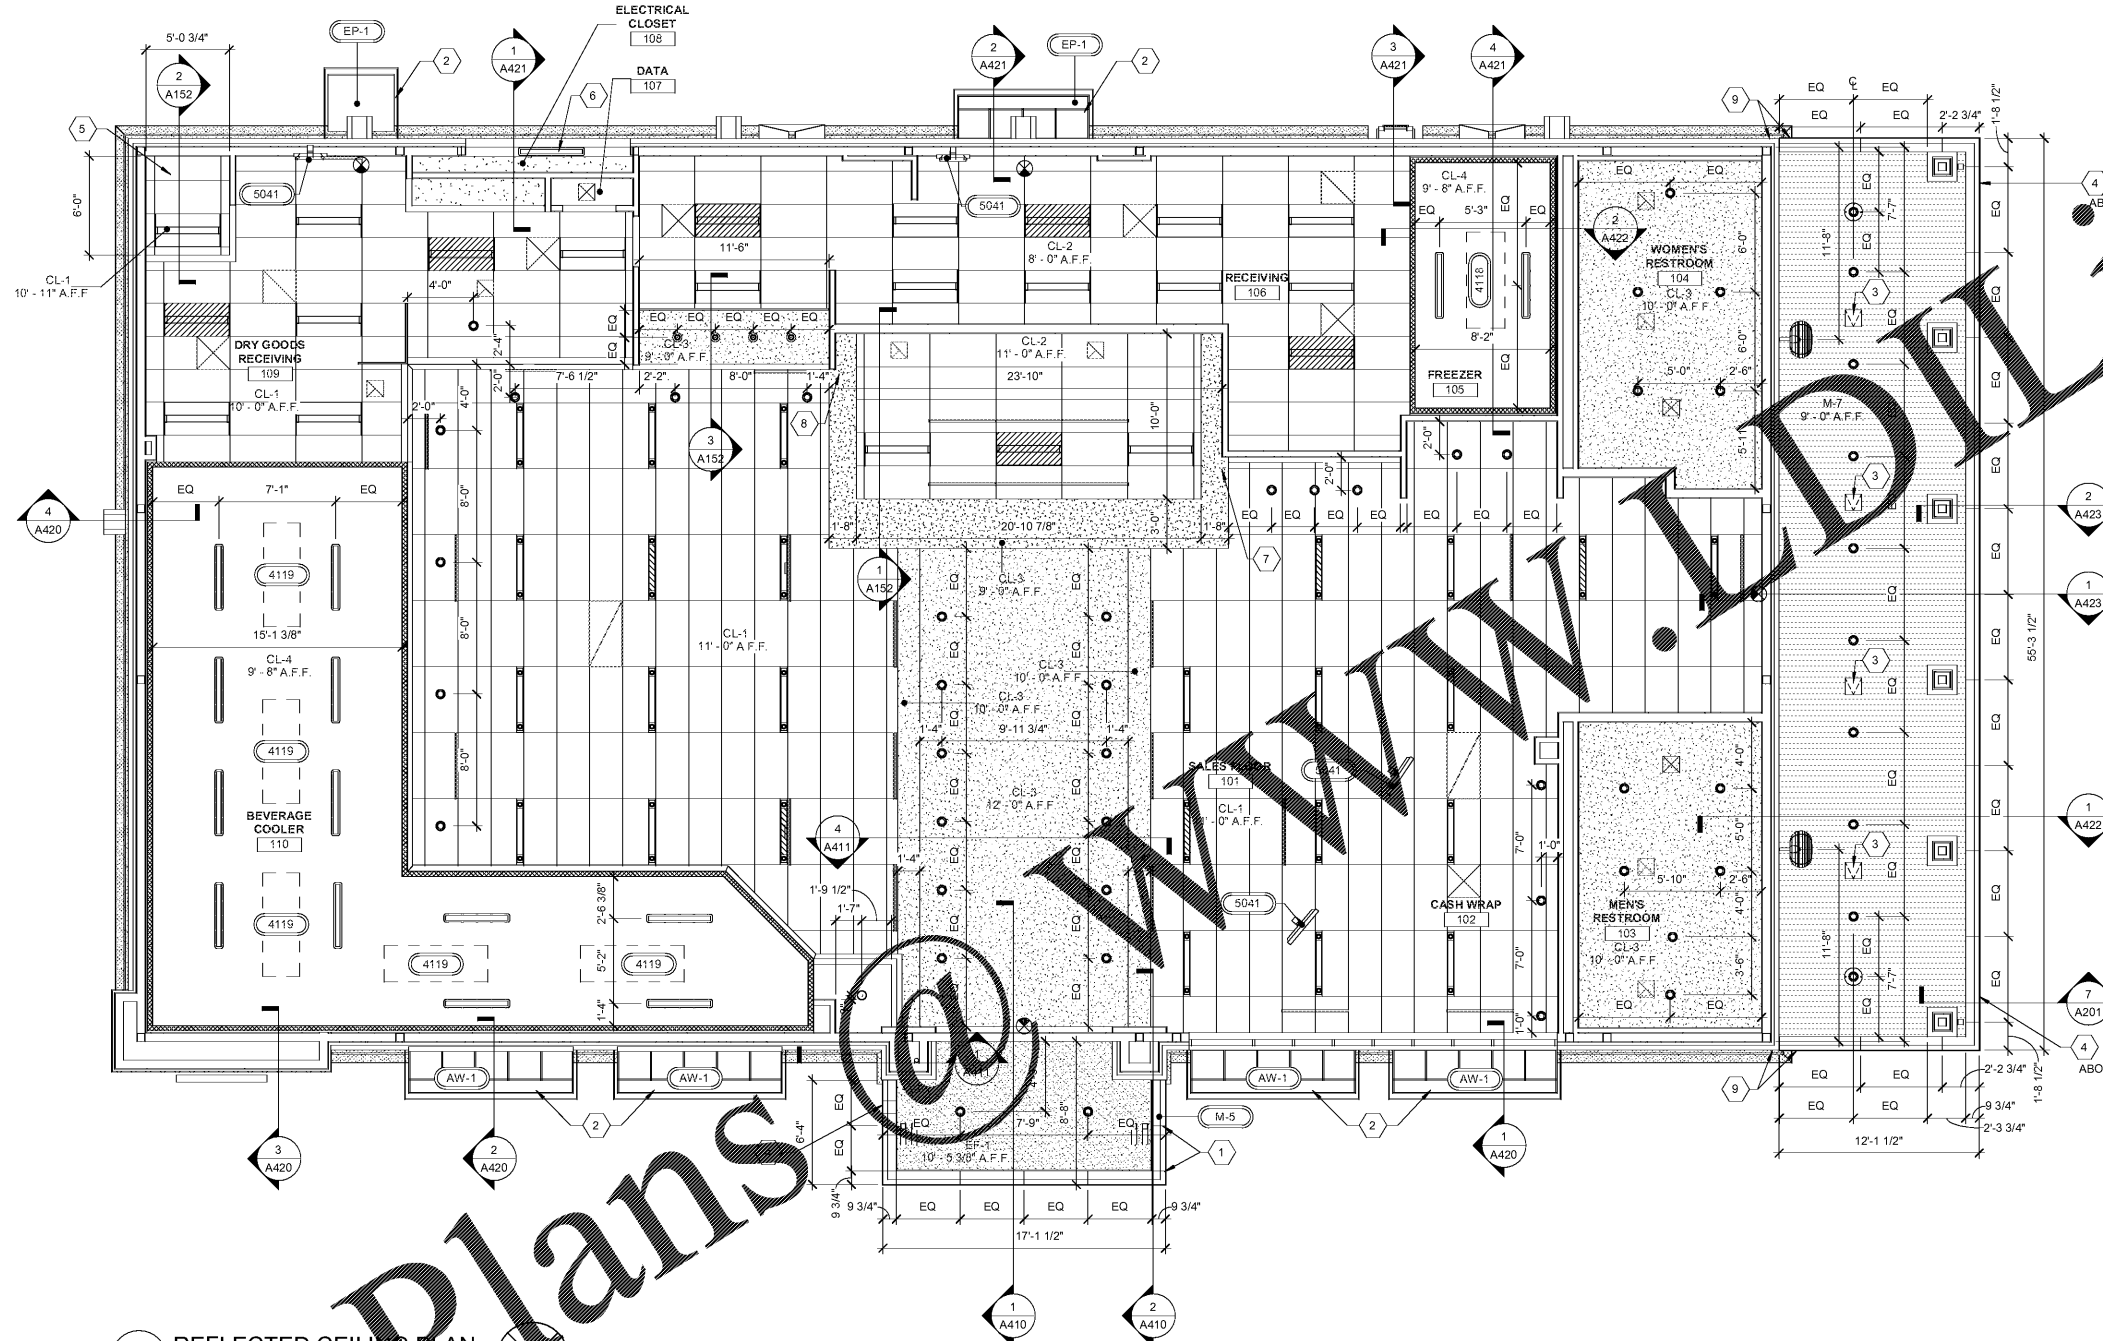

1 REFLECTED CEILING PLAN
3/16" = 1'-0"

GENERAL NOTES

- ALL DIMENSIONS ARE TO FACE OF FINISH UNLESS NOTED OTHERWISE.
- REFER TO SHEET A500 FOR INTERIOR FINISH LEGEND.
- REFER TO ELECTRICAL SHEETS FOR LIGHTING FIXTURE SCHEDULE.
- REFER TO MECHANICAL SHEETS FOR DIFFUSER SCHEDULE.
- REFER TO WALL SECTIONS FOR SOFFIT CONSTRUCTION. ALL SOFFITS SHALL BE CONSTRUCTED OF ARMSTRONG DRYWALL CEILING GRIDS UNLESS OTHERWISE INDICATED.

SHEET KEYNOTES

- ACM PANEL REVEAL LINE
- METAL AWNING
- 12X12 ACCESS PANEL WITH POWDER COAT TO MATCH SOFFIT
- OVERFLOW SCUPPER
- RAISED CEILING AREA FOR WATER HEAD
- LIGHT MOUNTED TO OVERHEAD DOOR HEAD
- REFER TO ISOMETRIC DETAIL 4/A152
- REFER TO ISOMETRIC DETAIL 5/A152
- ALUMINUM WATER EDGE OF AWNING WITH FACE OF BRICK

RaceTrac
 THESE PLANS ARE SUBJECT TO FEDERAL COPYRIGHT LAWS. ANY USE OF SAME WITHOUT THE EXPRESSED WRITTEN PERMISSION OF RACETRAC PETROLEUM, INC. IS PROHIBITED. 2016 RACETRAC PETROLEUM INC.

HILLFOLEYROSSI & ASSOCIATES
 ARCHITECTURE
 ENGINEERING

3680 Pleasant Hill Road
 Suite 200
 Duluth, Georgia 30096
 p 770.622.9858
 f 770.622.9535
 www.hillfoleyrossi.com

ISSUE/REVISION RECORD

DATE	DESCRIPTION
09/04/18	ISSUED FOR PERMIT

RaceTrac
 RACETRAC PETROLEUM, INC.
 200 GALLERIA PARKWAY SOUTHEAST
 SUITE 900
 ATLANTA, GEORGIA 30339
 (770) 431-7600

PROJECT NAME
PEACHTREE PKWY & ENG.

PROJECT ADDRESS
**PEACHTREE CORNERS
 5780 PEACHTREE PKWY
 PEACHTREE CORNERS, GA
 RACETRAC STORE NUMBER
 1201**

PROTOTYPE SERIES 5.5K 2.0
 2018 RH MO

PLAN MODIFICATION NOTICE
 SPB NO. DATE

STANDARD PLAN BULLETINS (SPB) MODIFY THE PROTOTYPE SERIES SET NOTED ABOVE. THE LISTED SPB REPRESENTS THE LATEST MODIFICATION INCORPORATED TO THIS PROTOTYPE SERIES SET AT ORIGINAL RELEASE. THE ISSUE/REVISION RECORD COLUMN ABOVE LISTS ANY REVISIONS OR SPB INCORPORATED IN THIS SET AFTER THE ORIGINAL RELEASE. CONTACT RACETRAC ENGINEERING AND CONSTRUCTION FOR ANY SUBSEQUENT BULLETINS NOT INCORPORATED HEREIN.

PROFESSIONAL SEAL

PROJECT NUMBER
 18.703.00

SHEET TITLE
REFLECTED CEILING PLAN AND DETAILS

SHEET NUMBER
A150
 ISSUED FOR PERMIT

REFLECTED CEILING PLAN LEGEND

- EXTERIOR LIGHT FIXTURE
- SURFACE MOUNTED LIGHT FIXTURE
- LIGHT FIXTURE
- 2x4 LIGHT FIXTURE
- 4" RECESSED DIRECTIONAL LIGHT. REFER TO ELECTRICAL LIGHTING SCHEDULE FOR SPECIFIC MODEL
- 6" RECESSED CAN LIGHT. REFER TO ELECTRICAL LIGHTING SCHEDULE FOR SPECIFIC MODEL
- EXIT SIGN
- EXTERIOR WALL MOUNTED FAN
- EXTERIOR GRADE RECESSED SPEAKER
- SLOT DIFFUSER
- 2x2 CEILING DIFFUSER
- 2x2 RETURN AIR GRILLE
- 2x4 RETURN AIR GRILLE
- RESTROOM DIFFUSER
- RESTROOM EXHAUST
- ACOUSTICAL CEILING TILE
- GYPSUM WALL BOARD CEILING
- EXTERIOR SOFFIT CEILING MATERIAL - EIFS (EF-1)
- EXTERIOR SOFFIT CEILING MATERIAL - COLOR TO MATCH SW #6113 INTERACTIVE CREAM